

















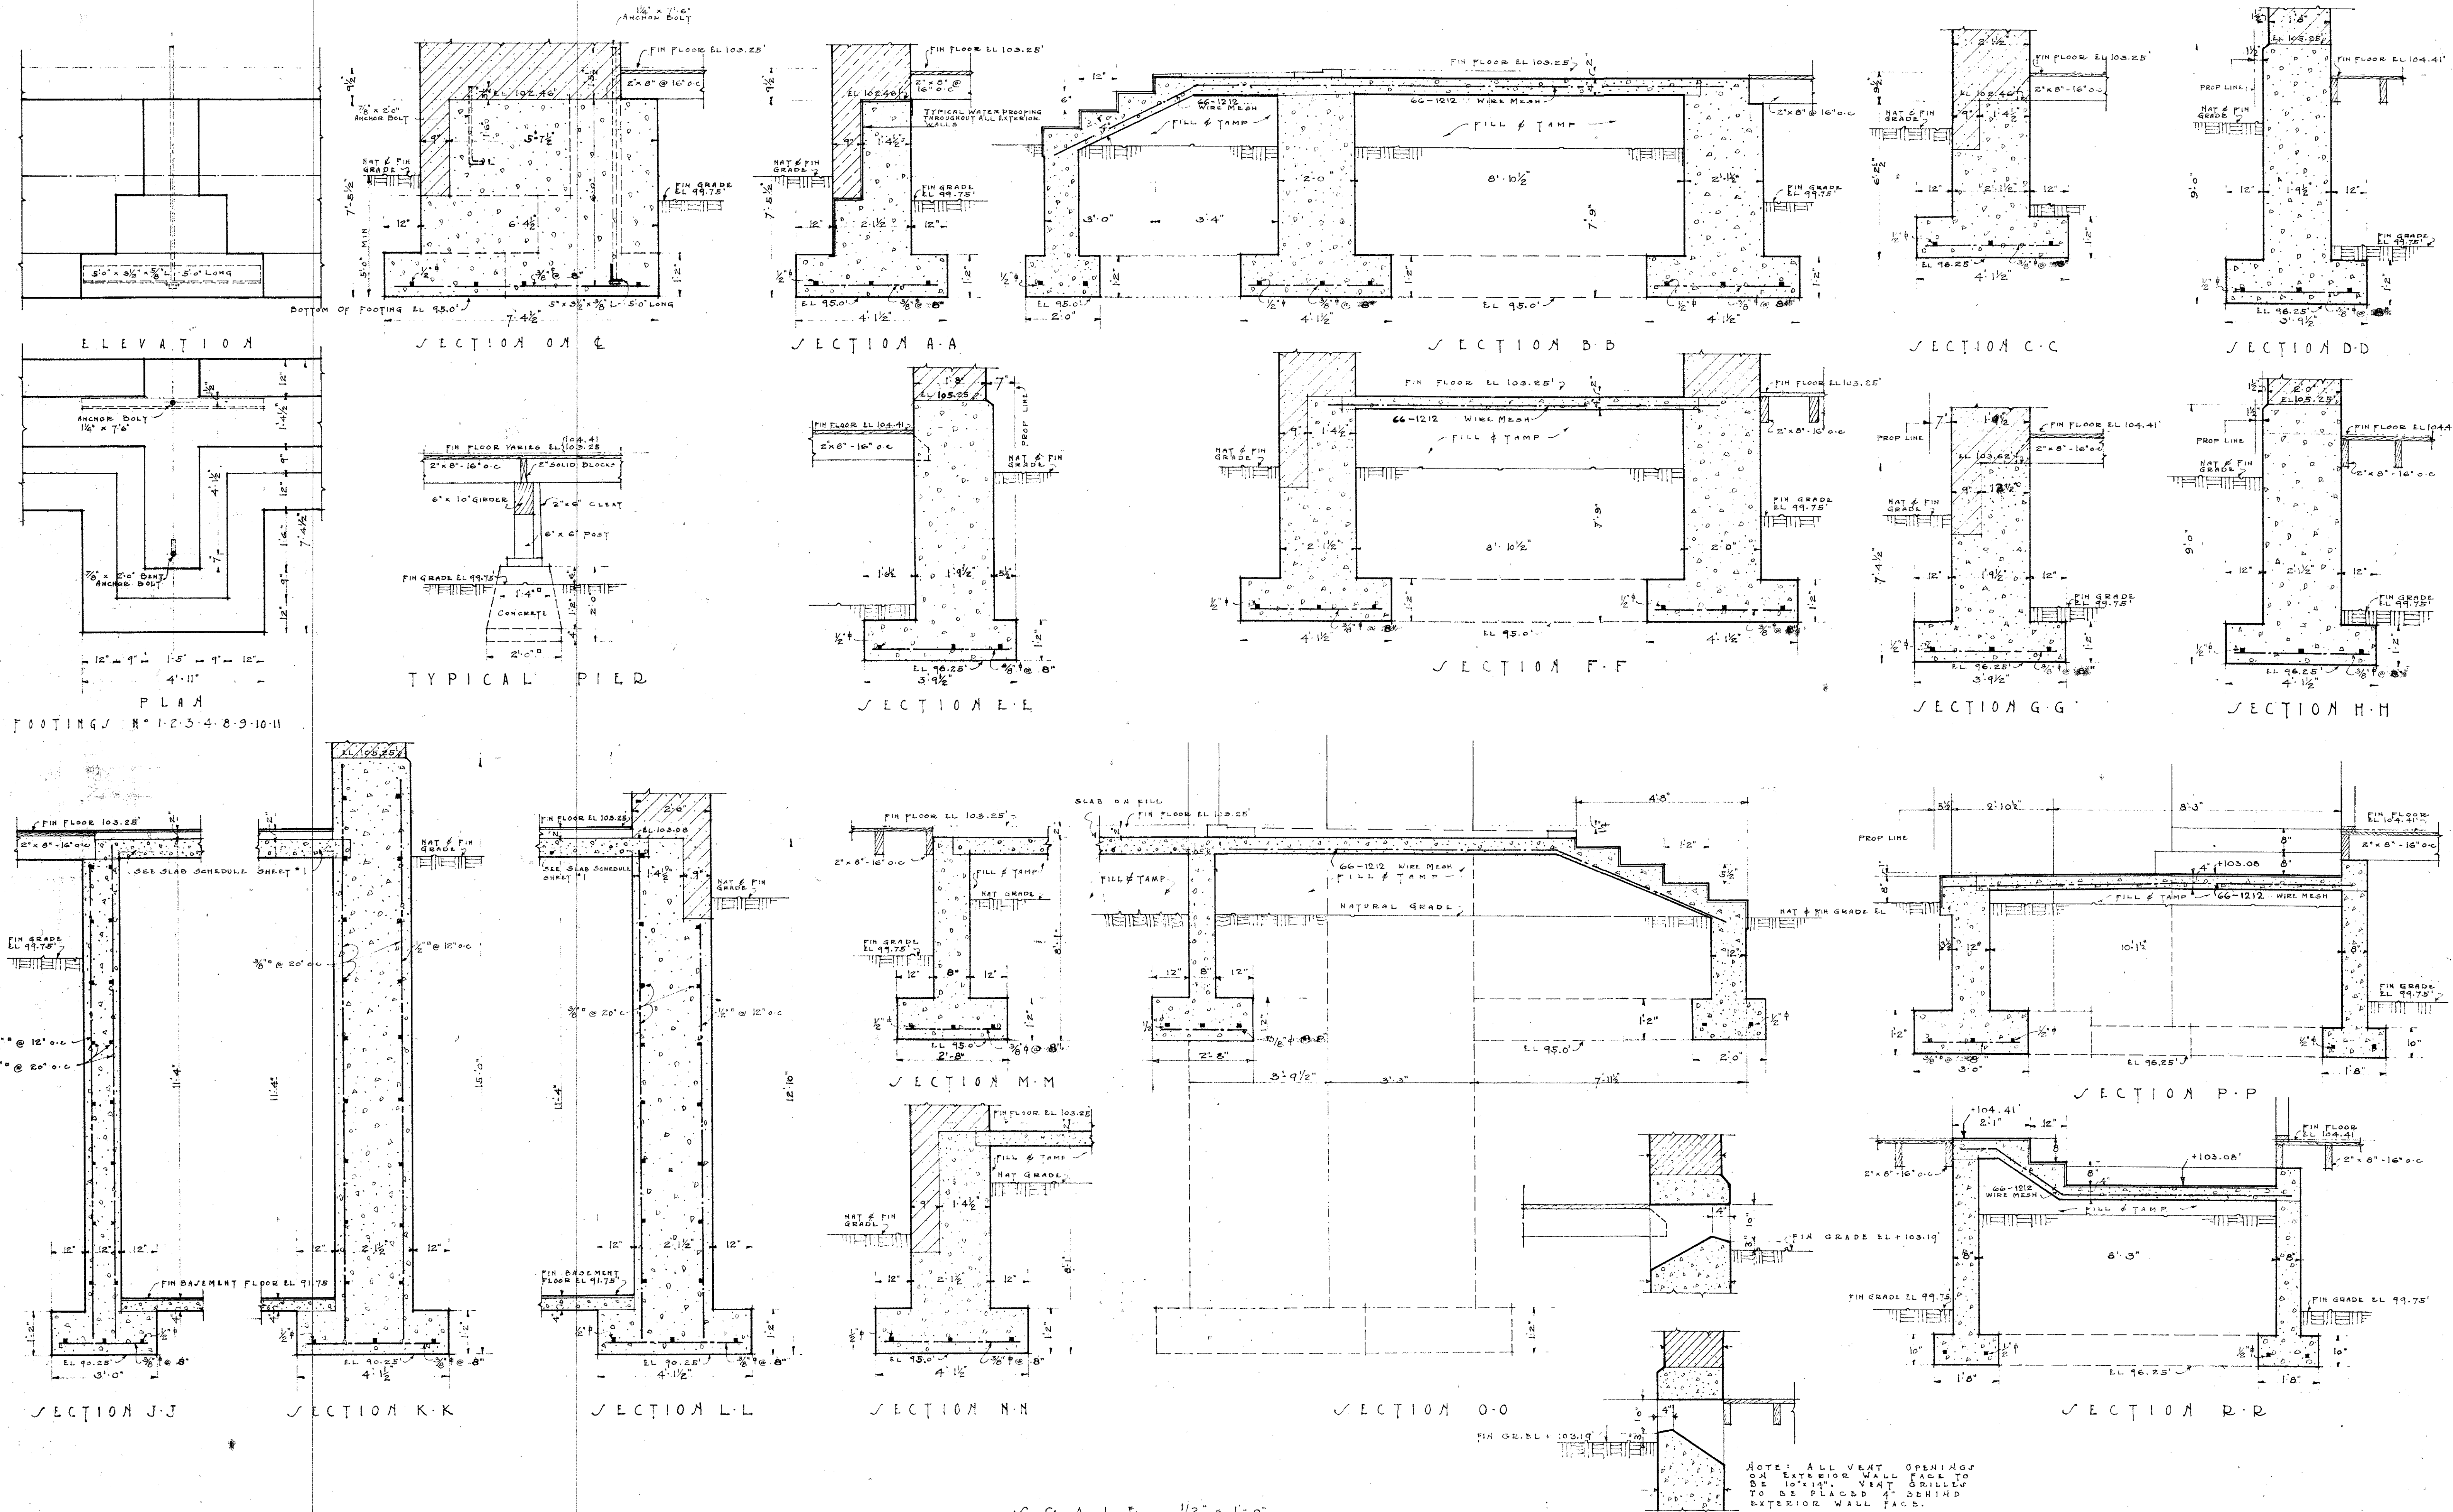



DATE SEPTEMBER 14 1929	REV. EDWARD ALBOUY RECTOR
LOCATION NORTH EAST COR. DEANER & CHERRY STREETS	

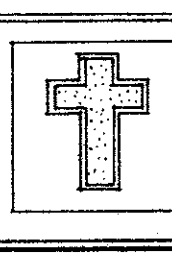


CHURCH OF THE NATIVITY
 PLACESTAFF ARIZONA
 FOR THE REV. BISHOP
 OF THE DIOCESE OF TUCSON

COMM. CHM ET G MARTIN ARCHITECT	SHEET NO 131
821 CHESTER WILLIAMS BLDG LOS ANGELES CAL	2

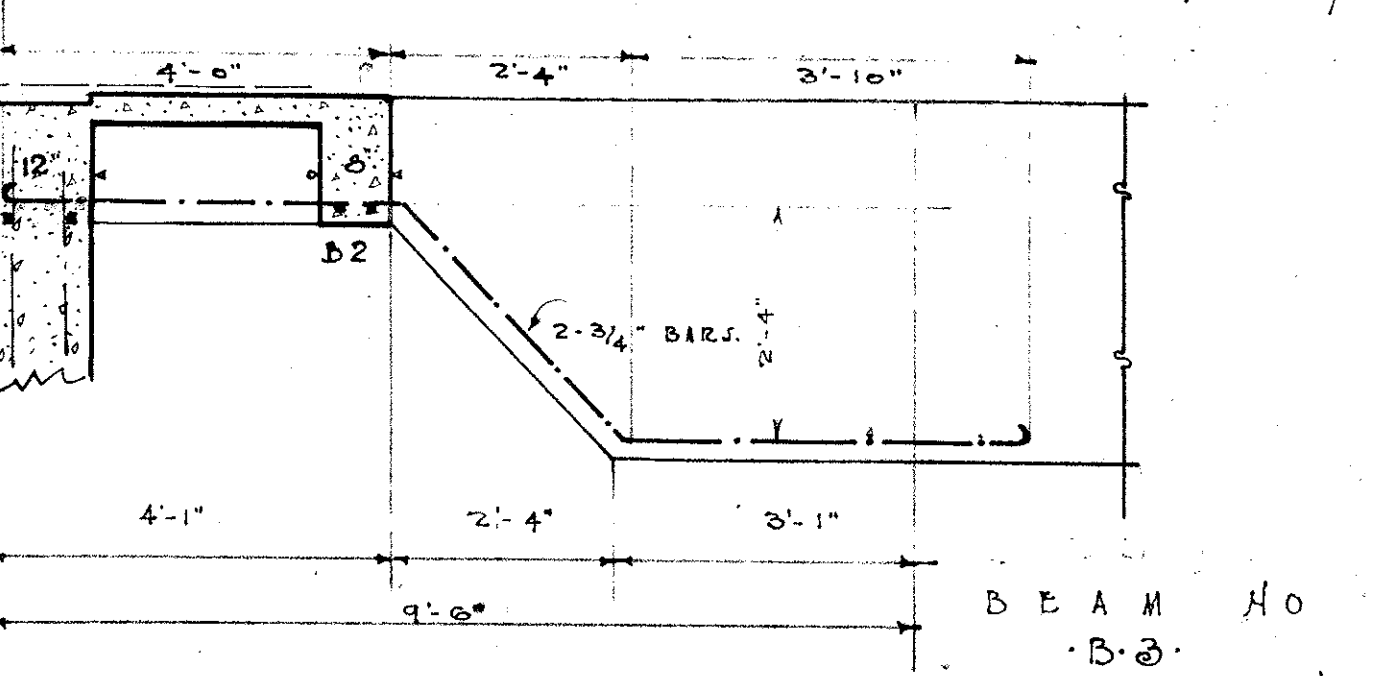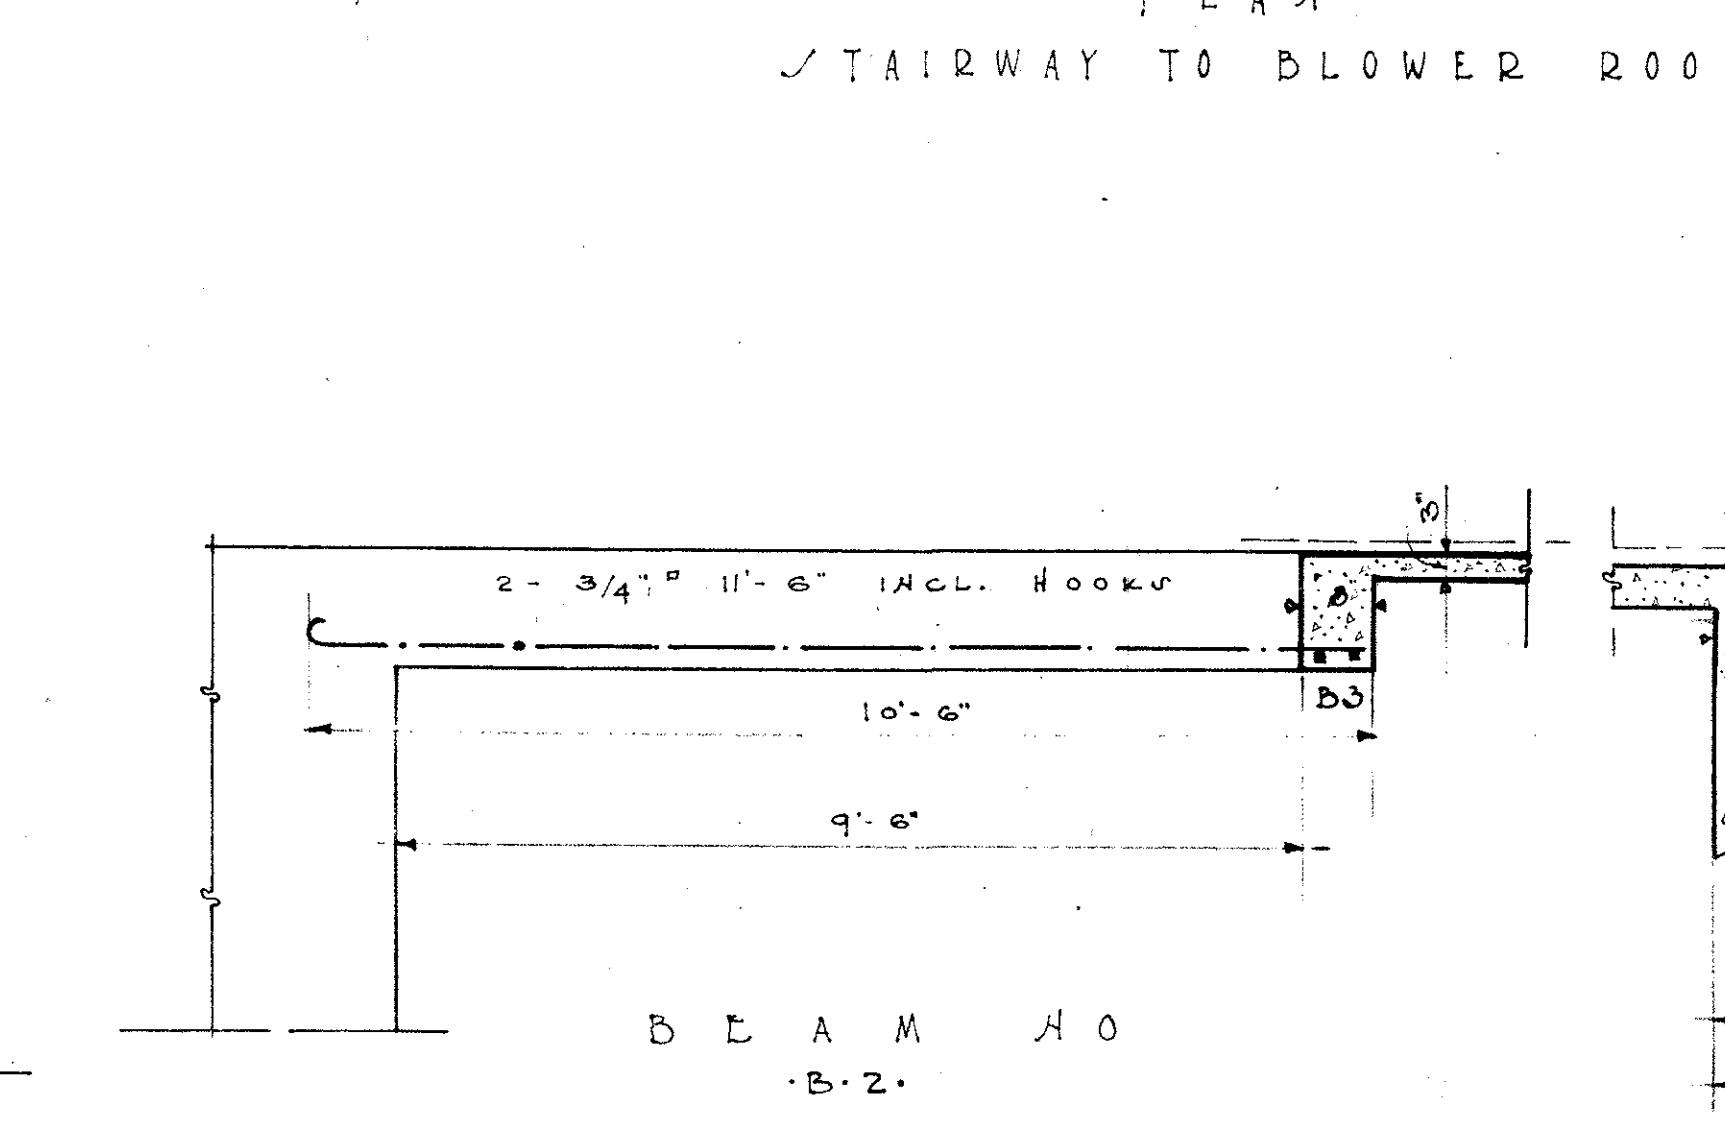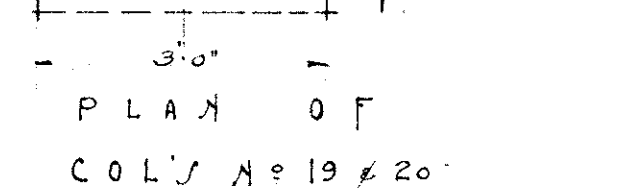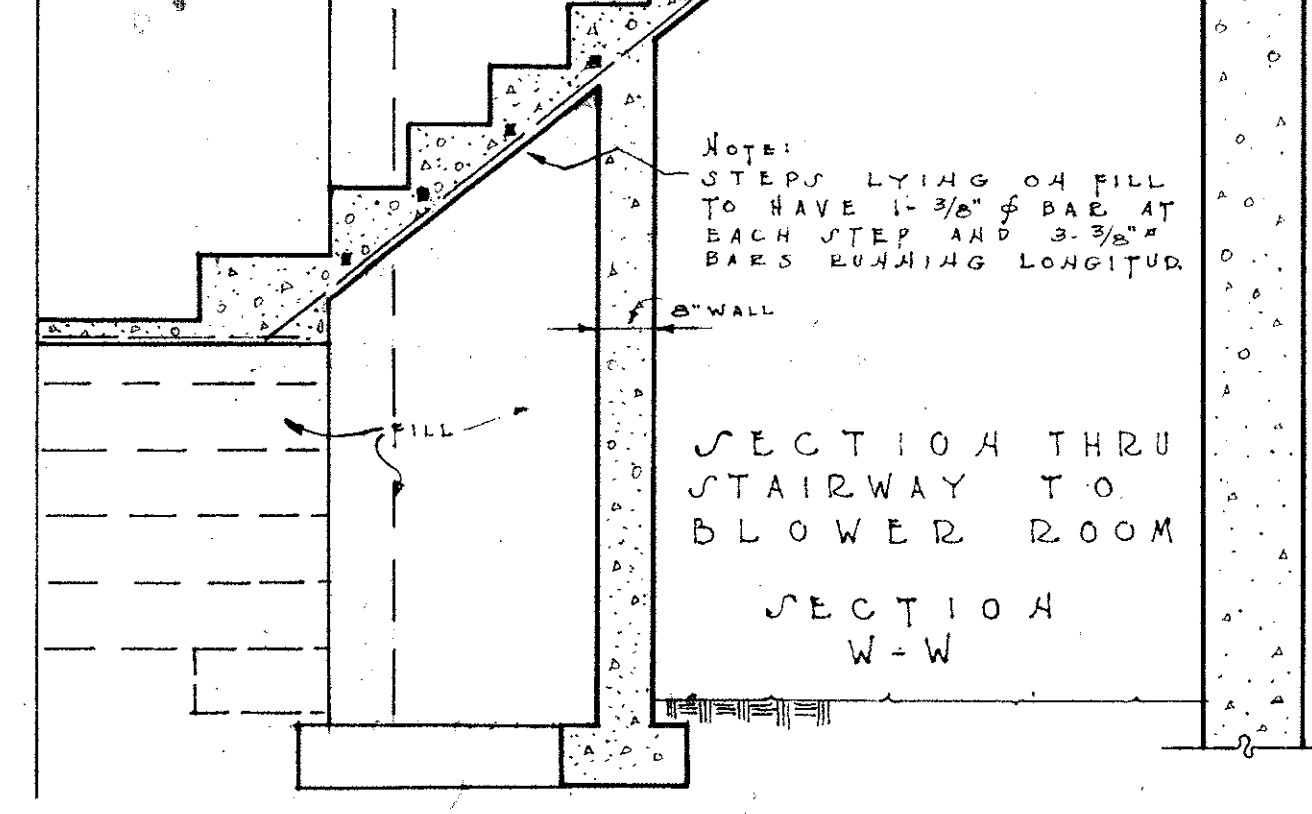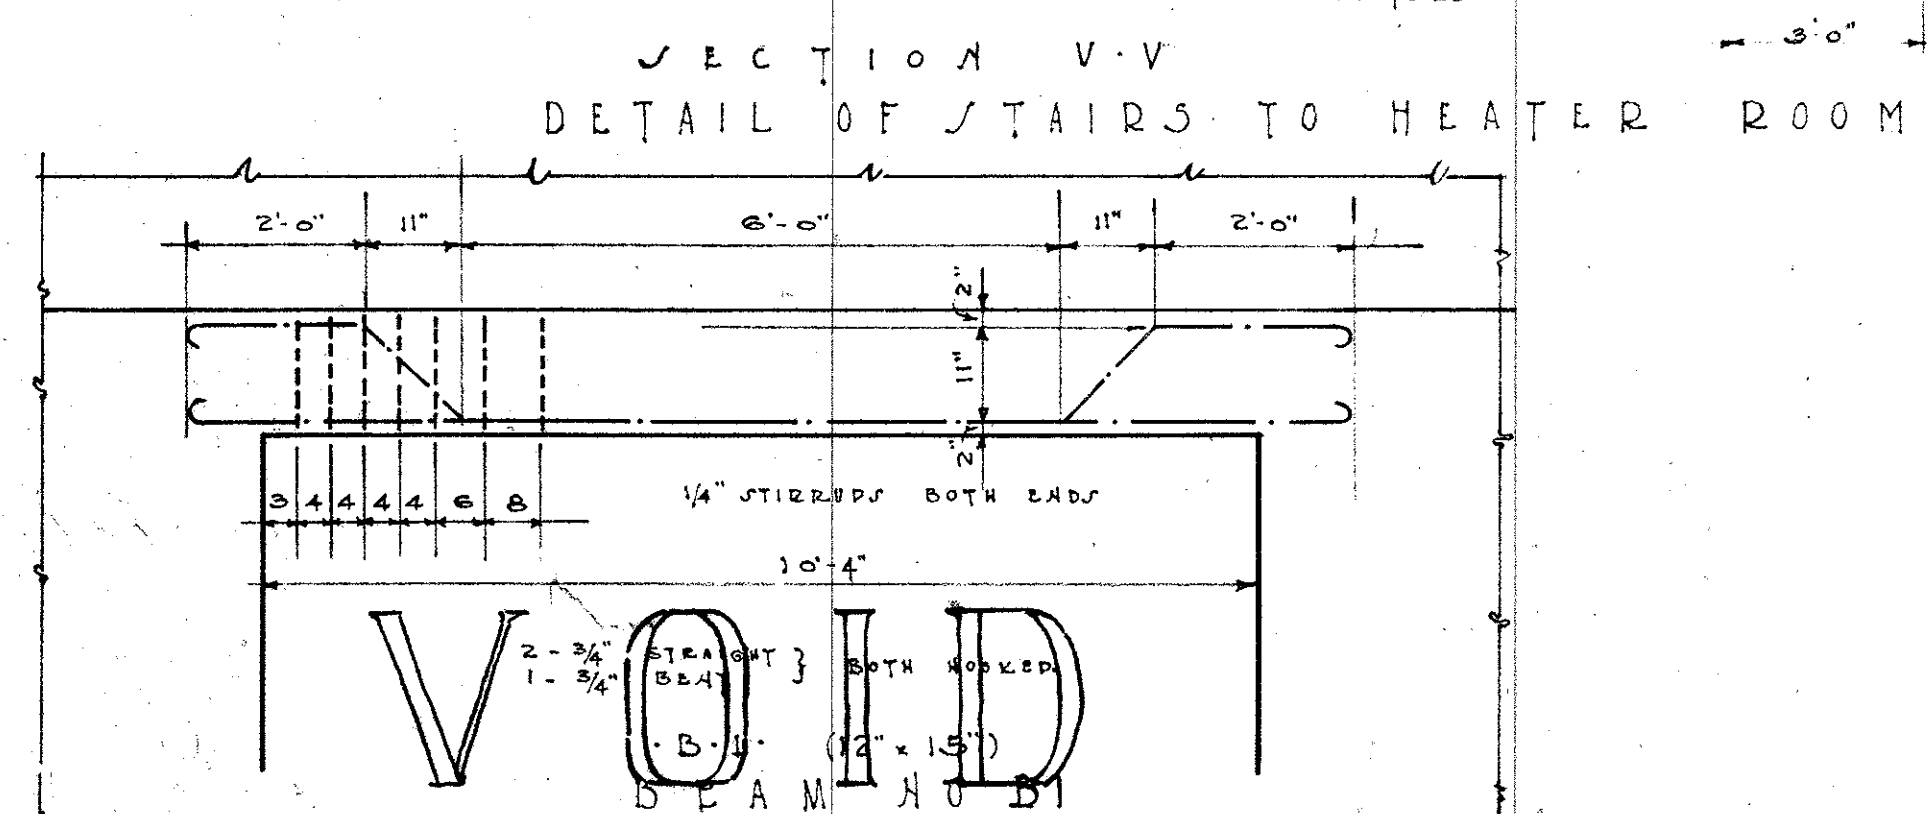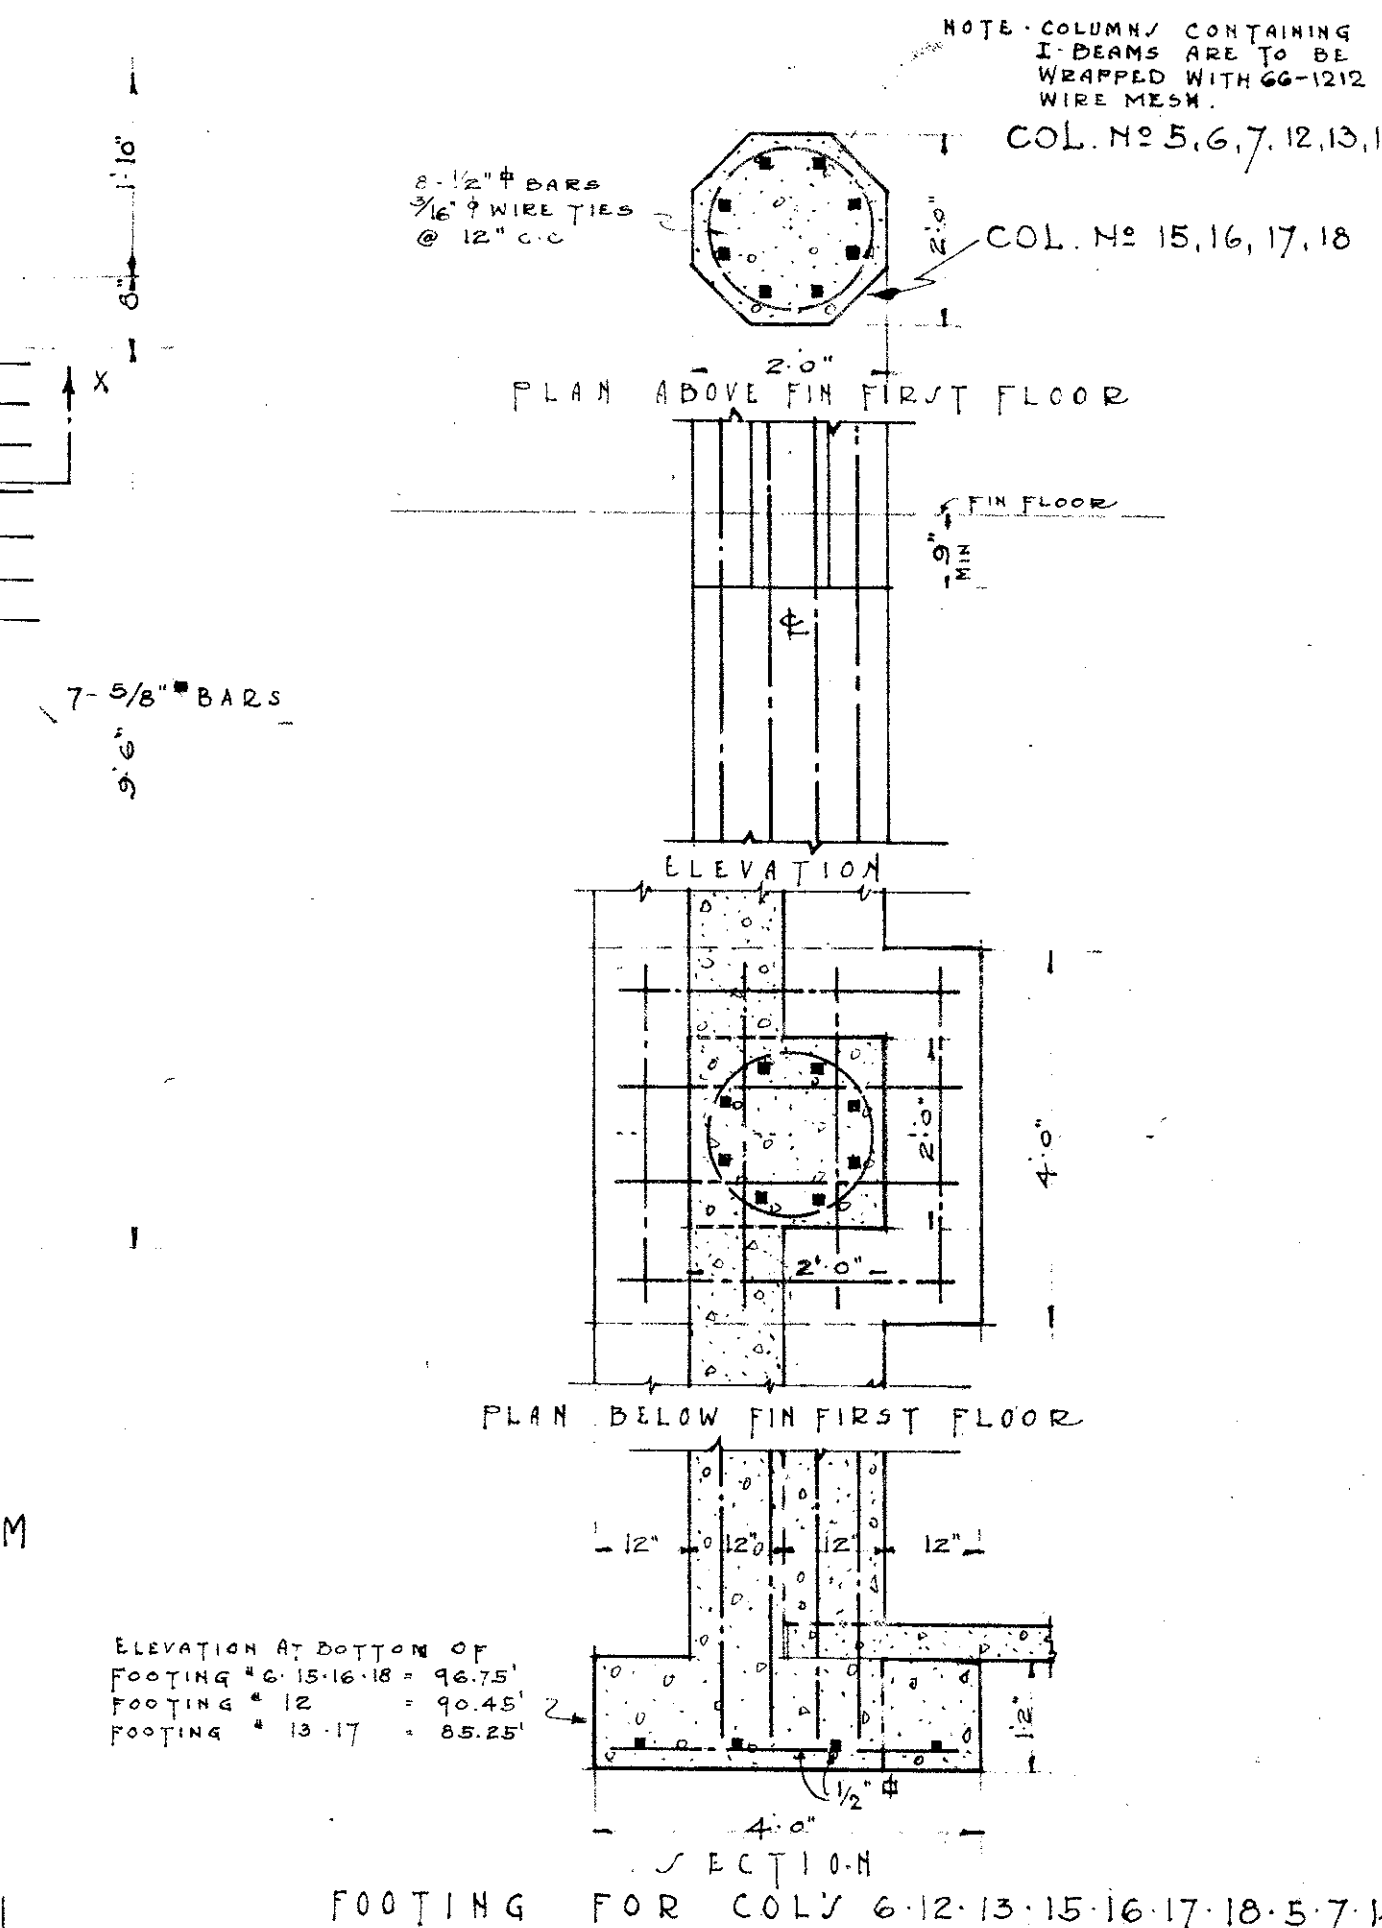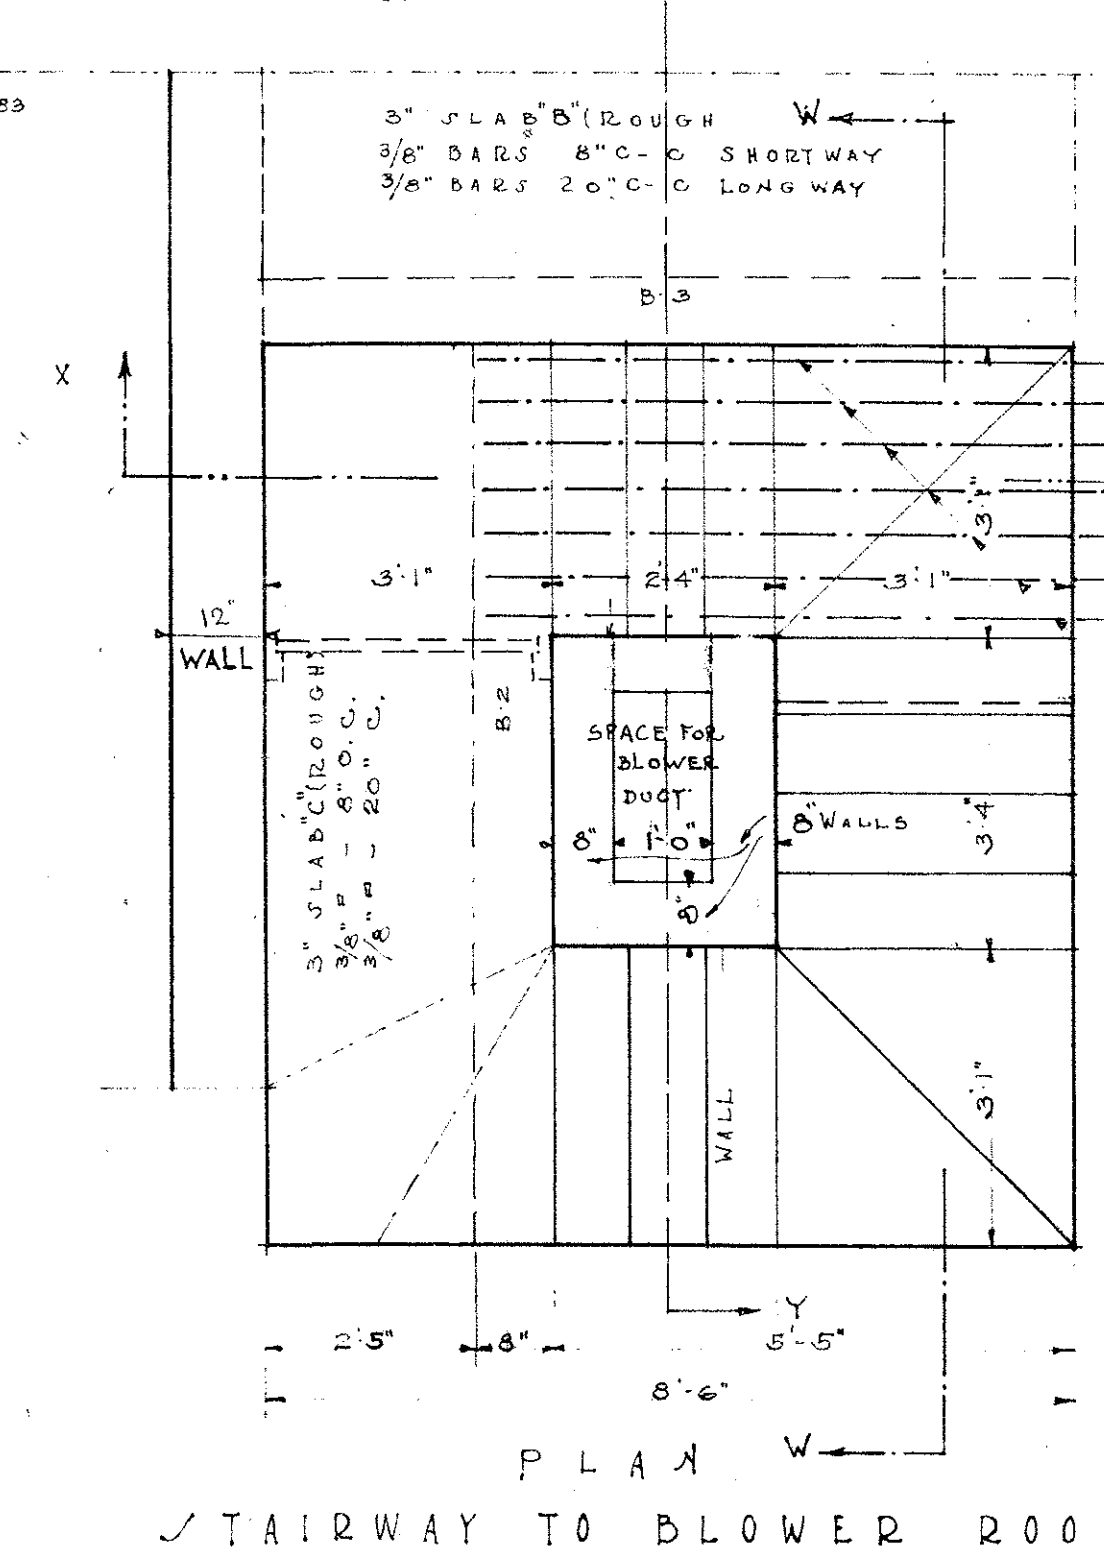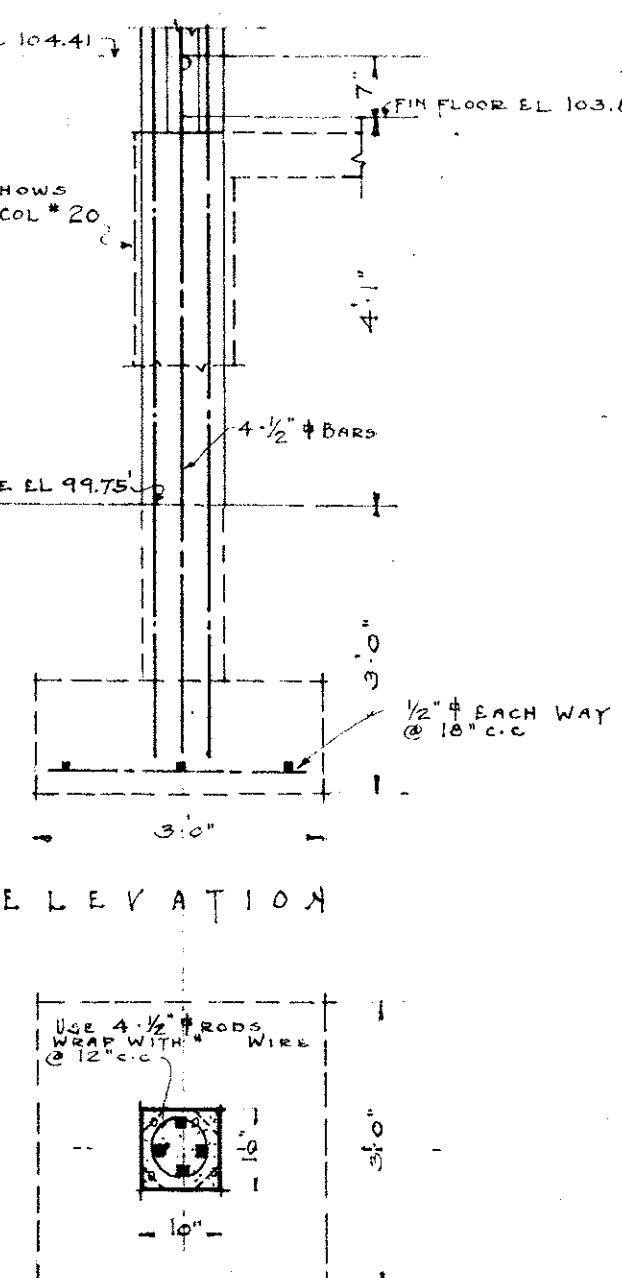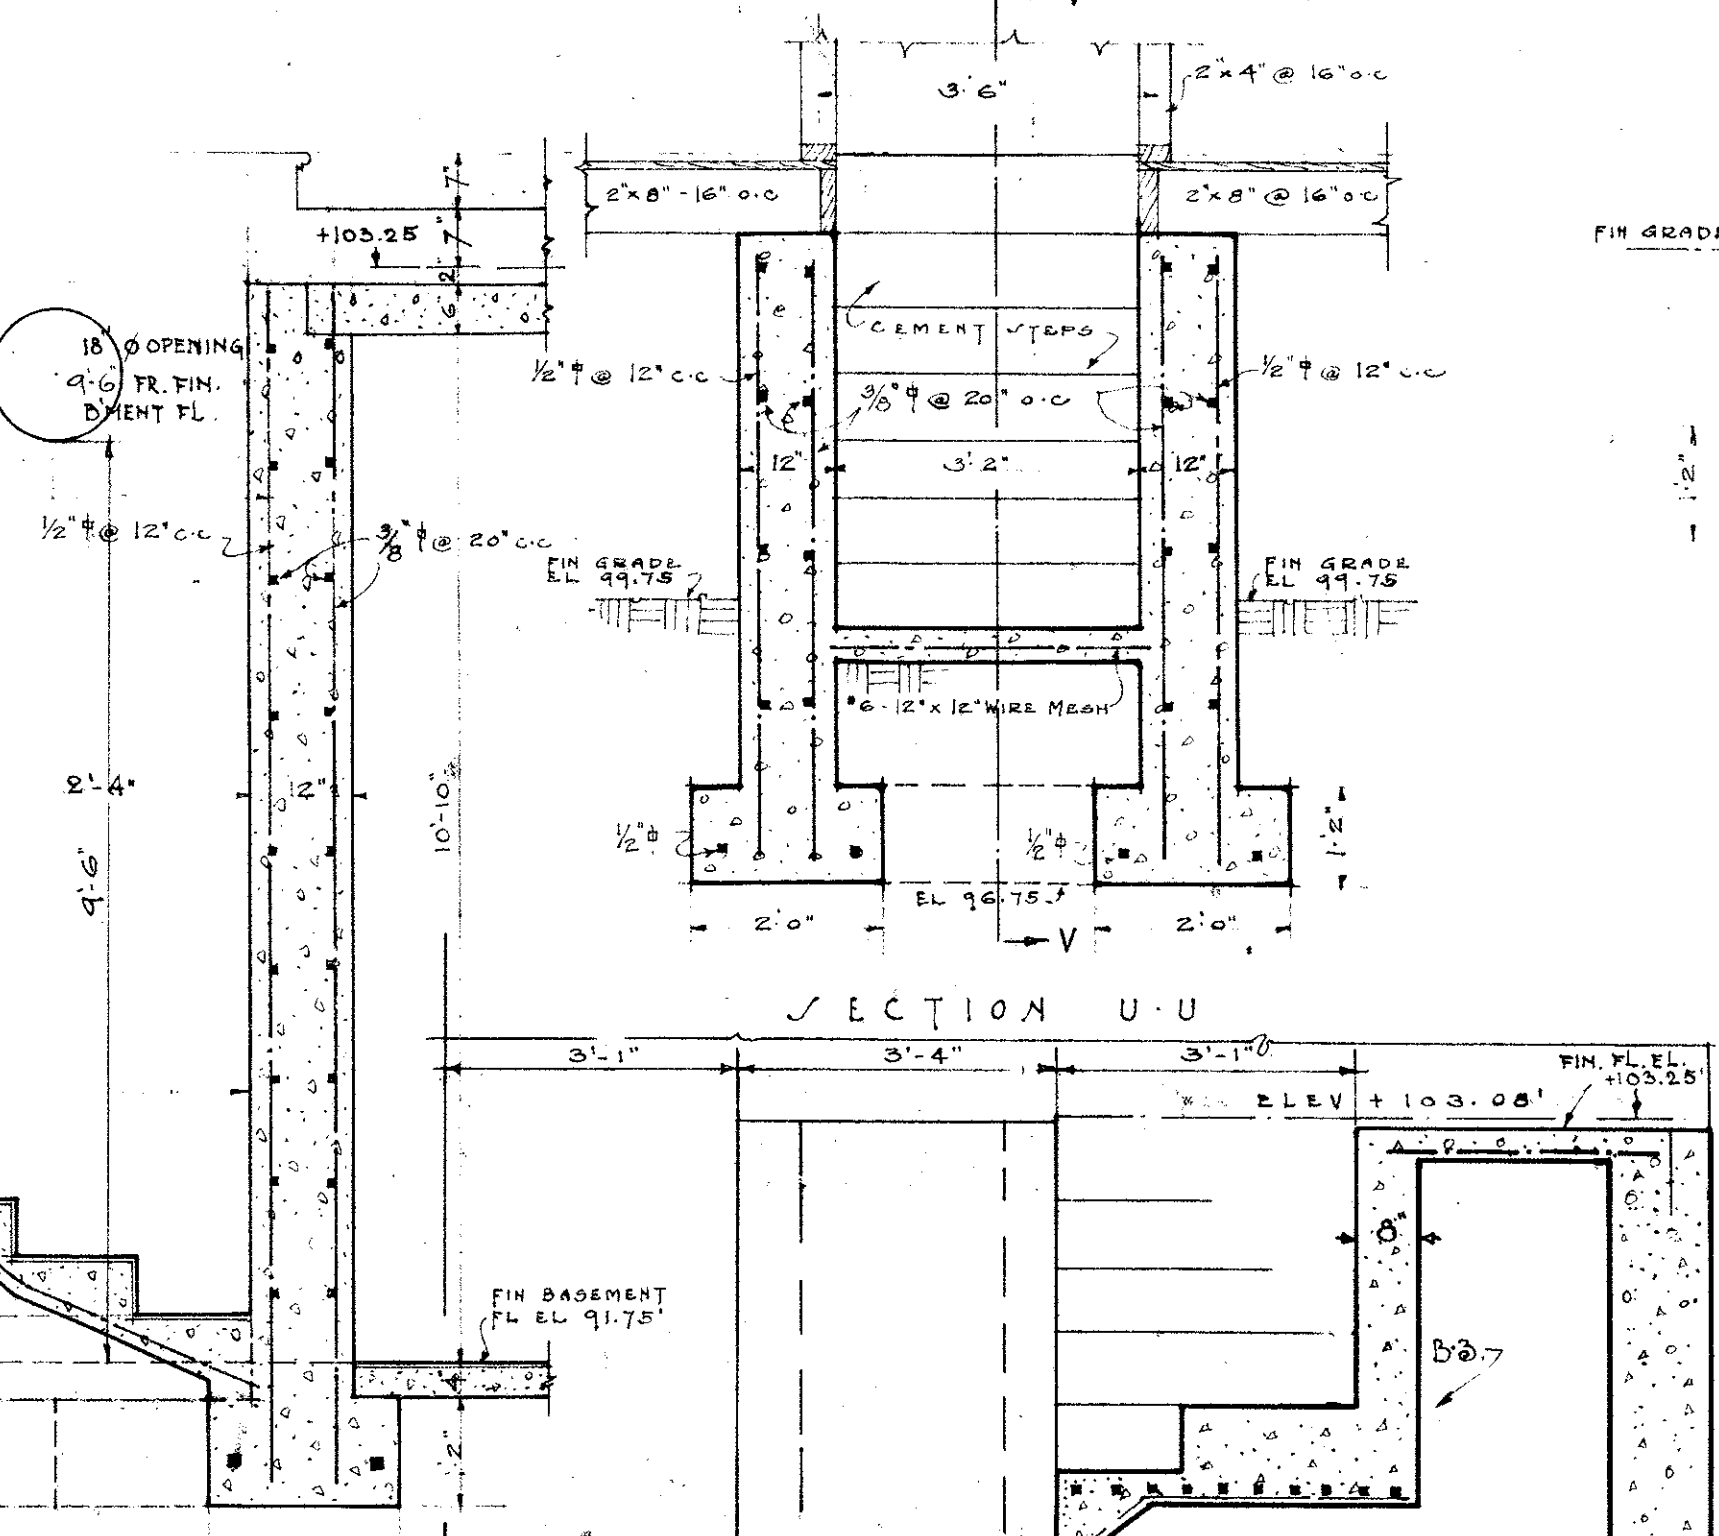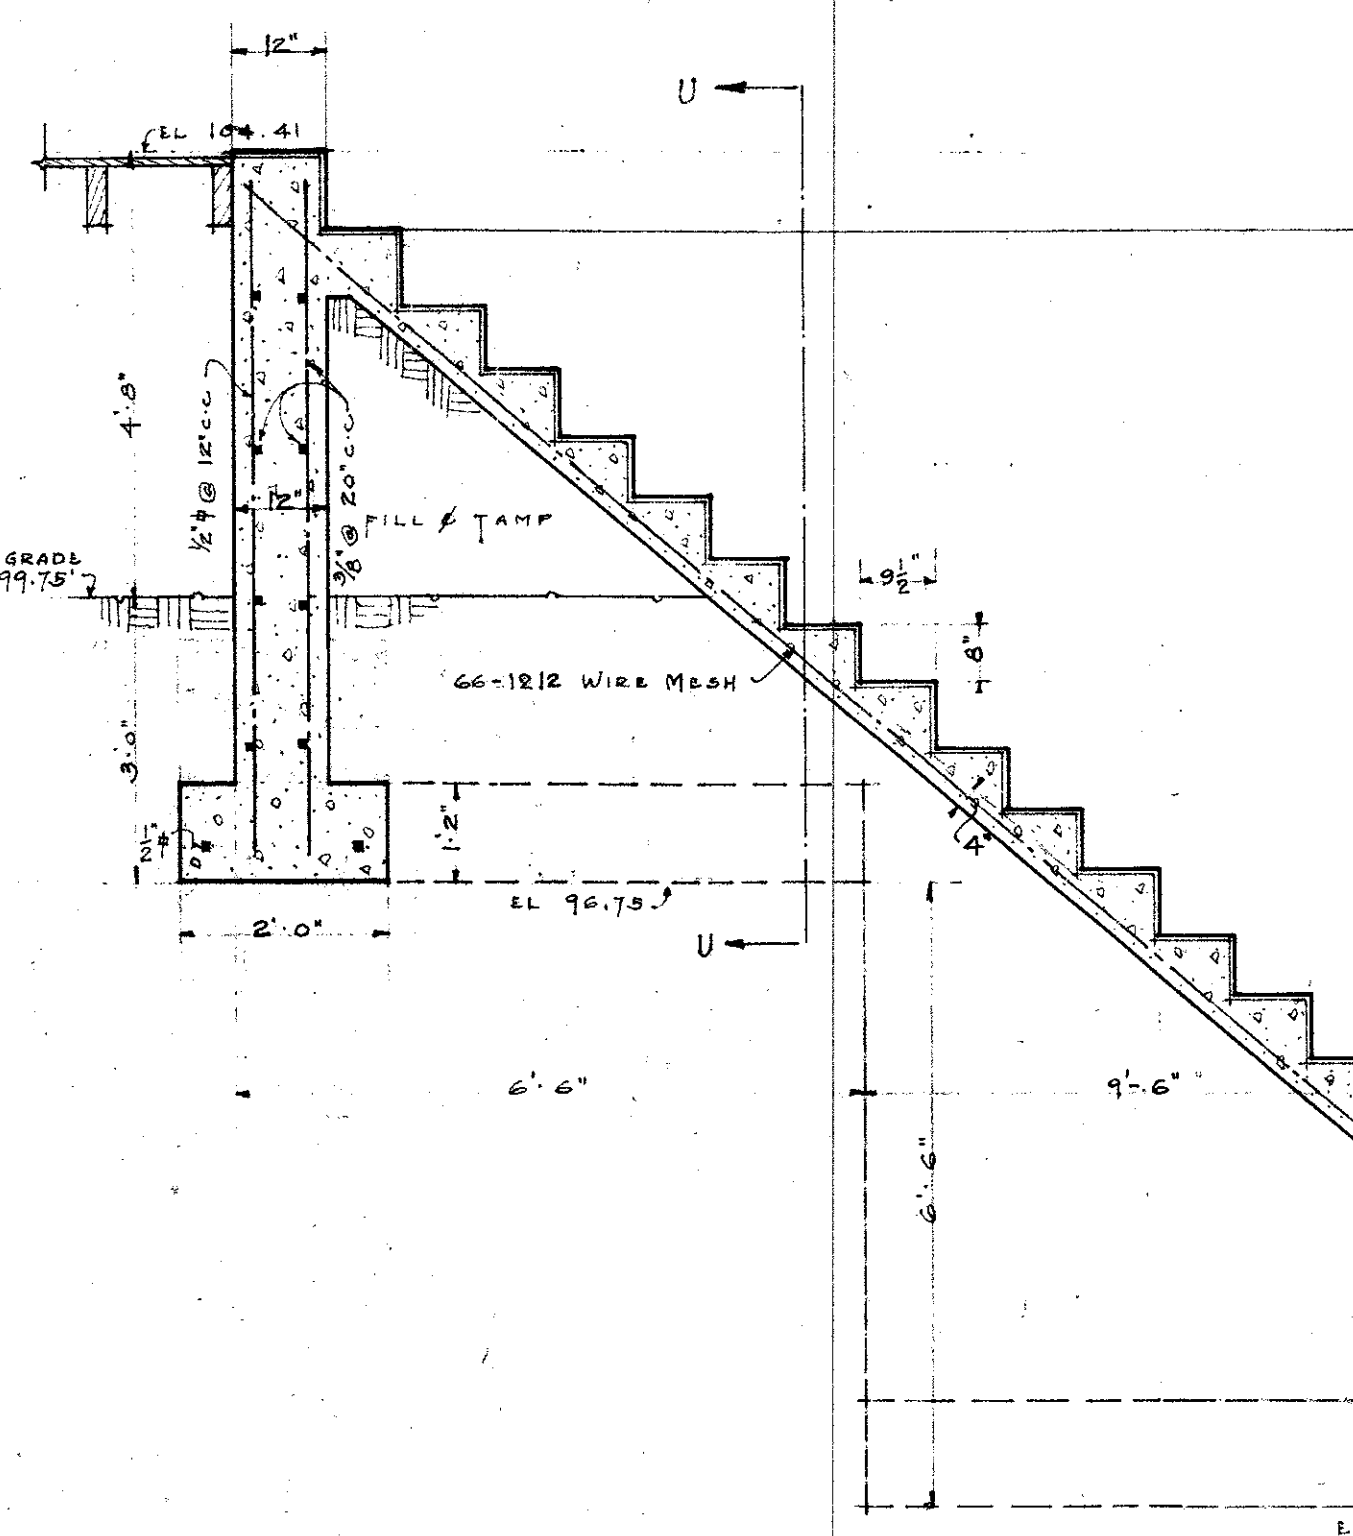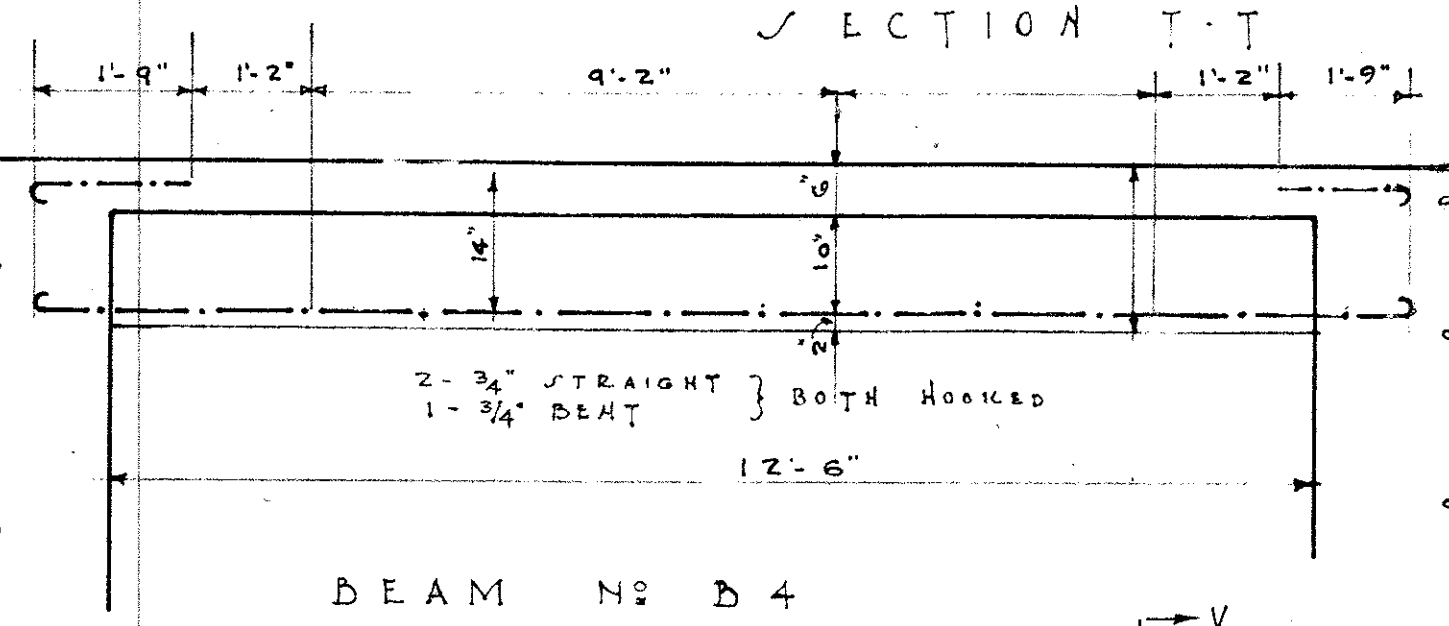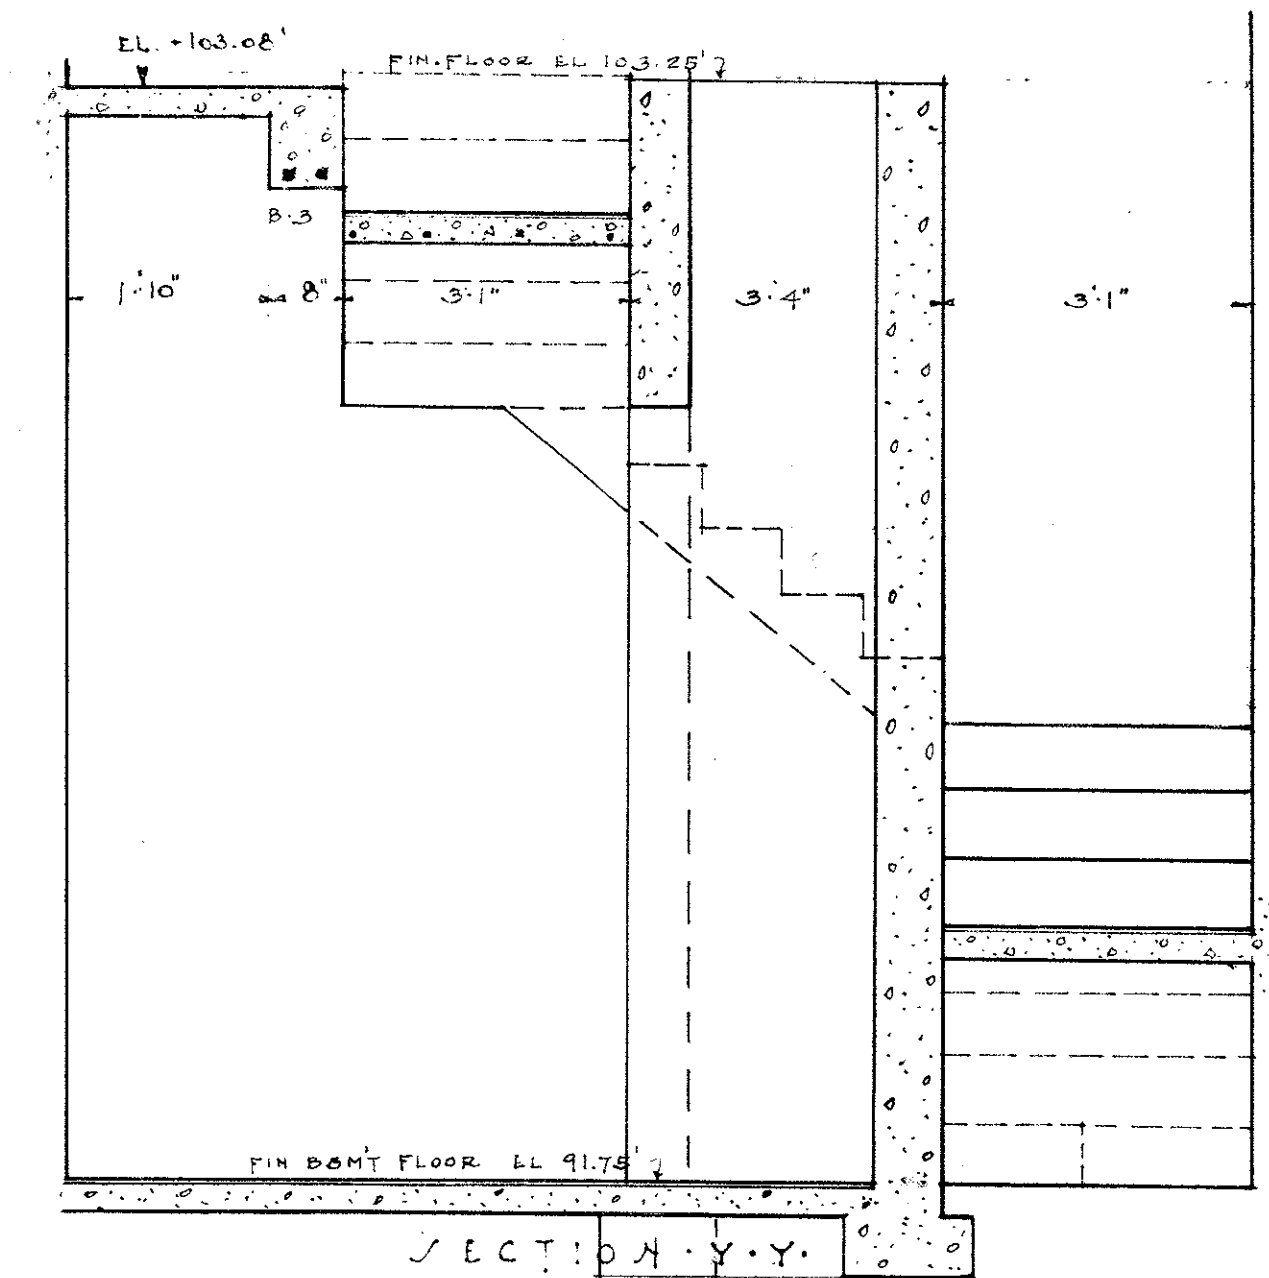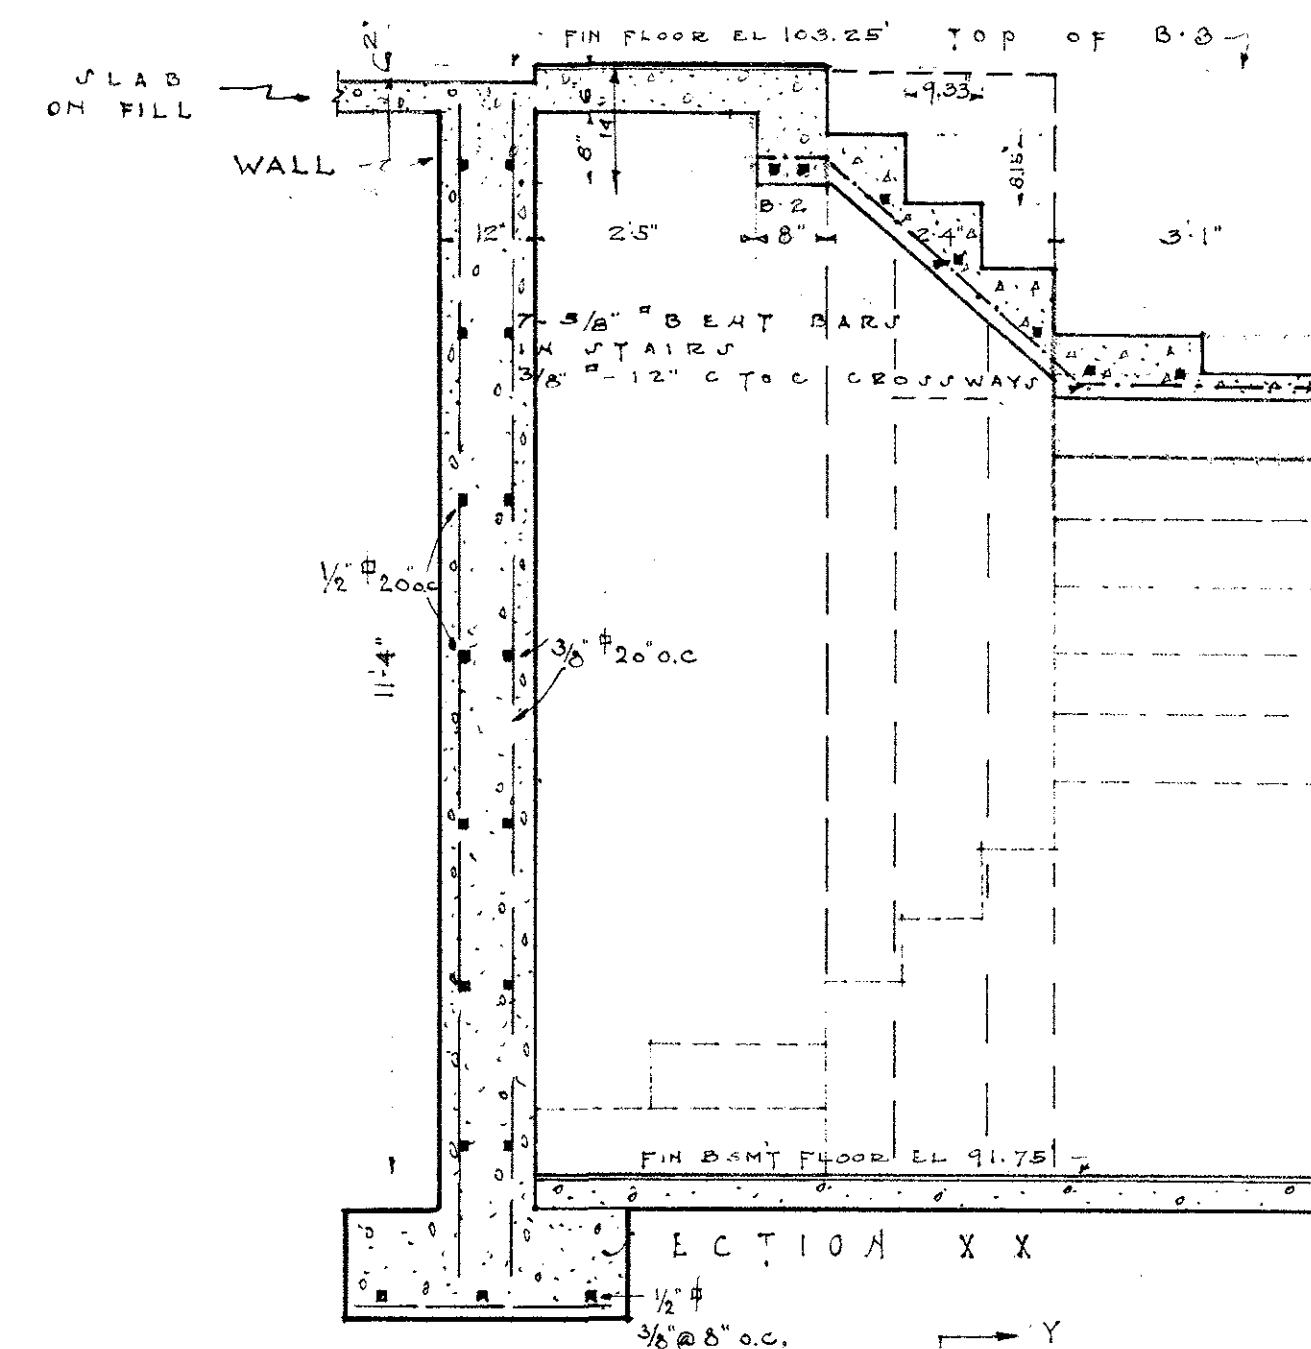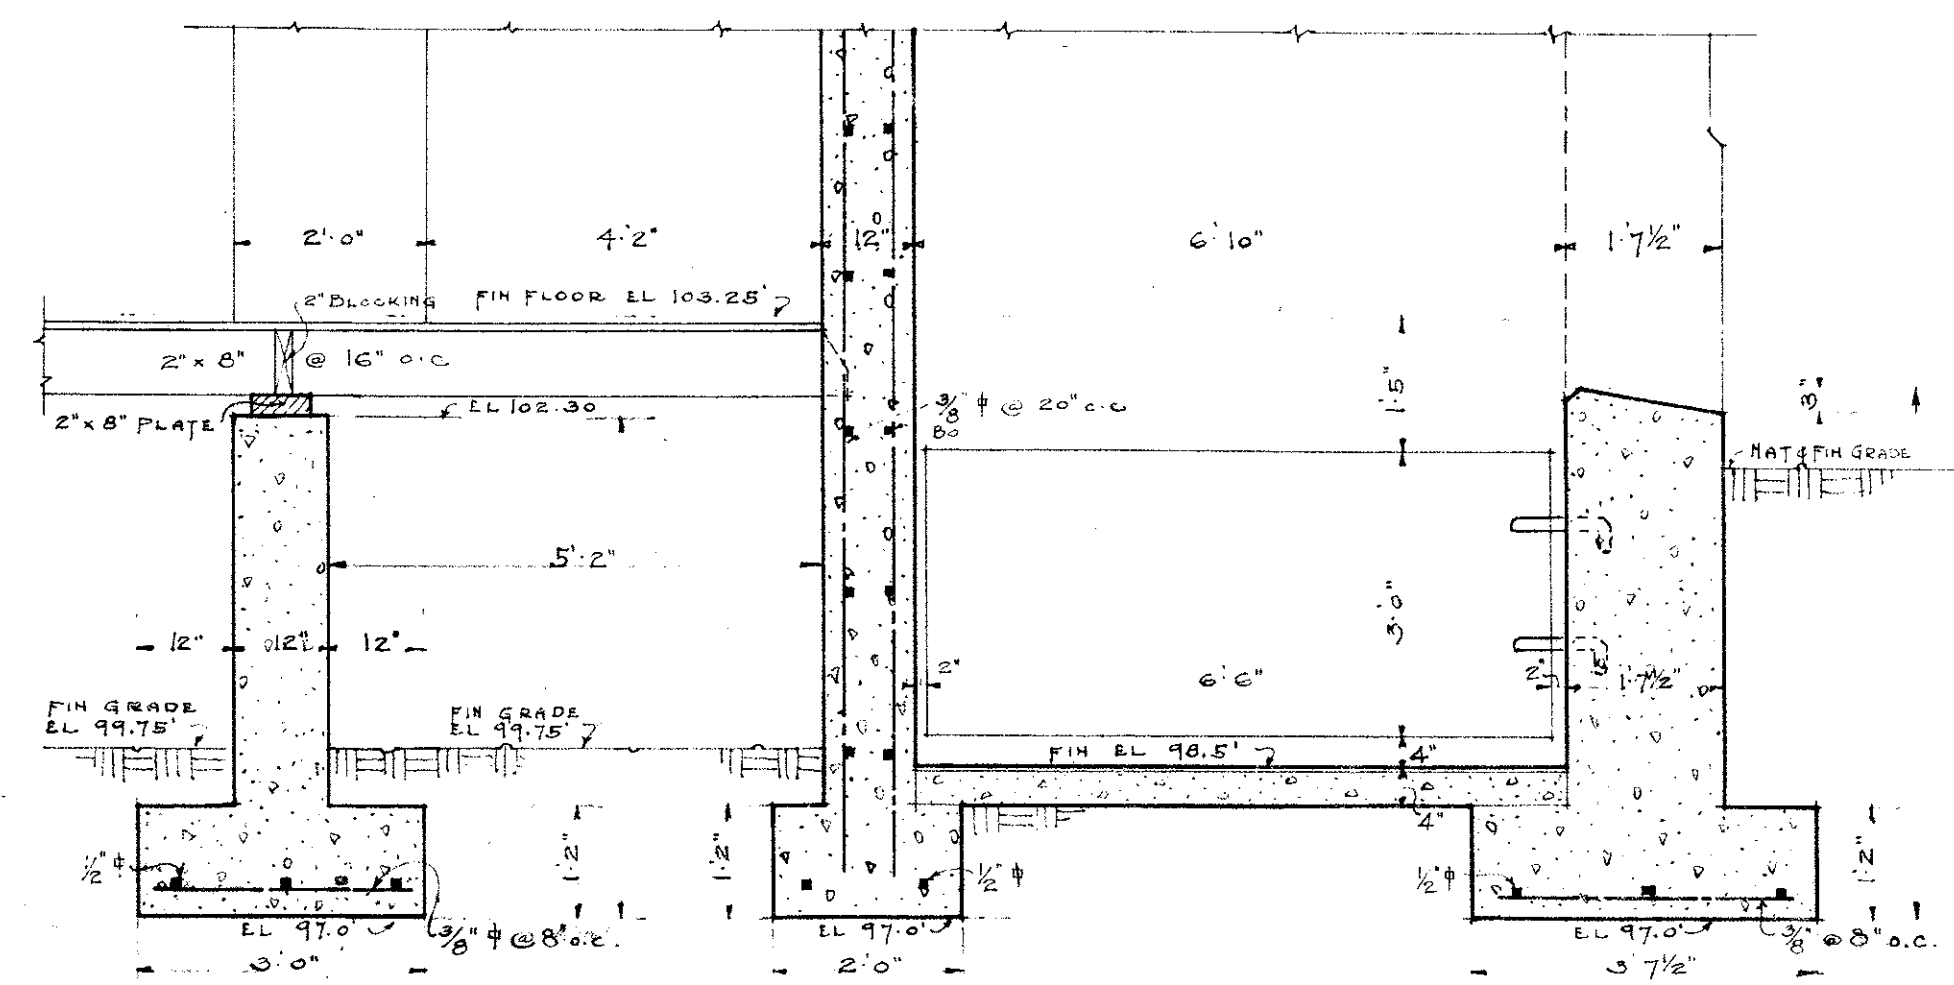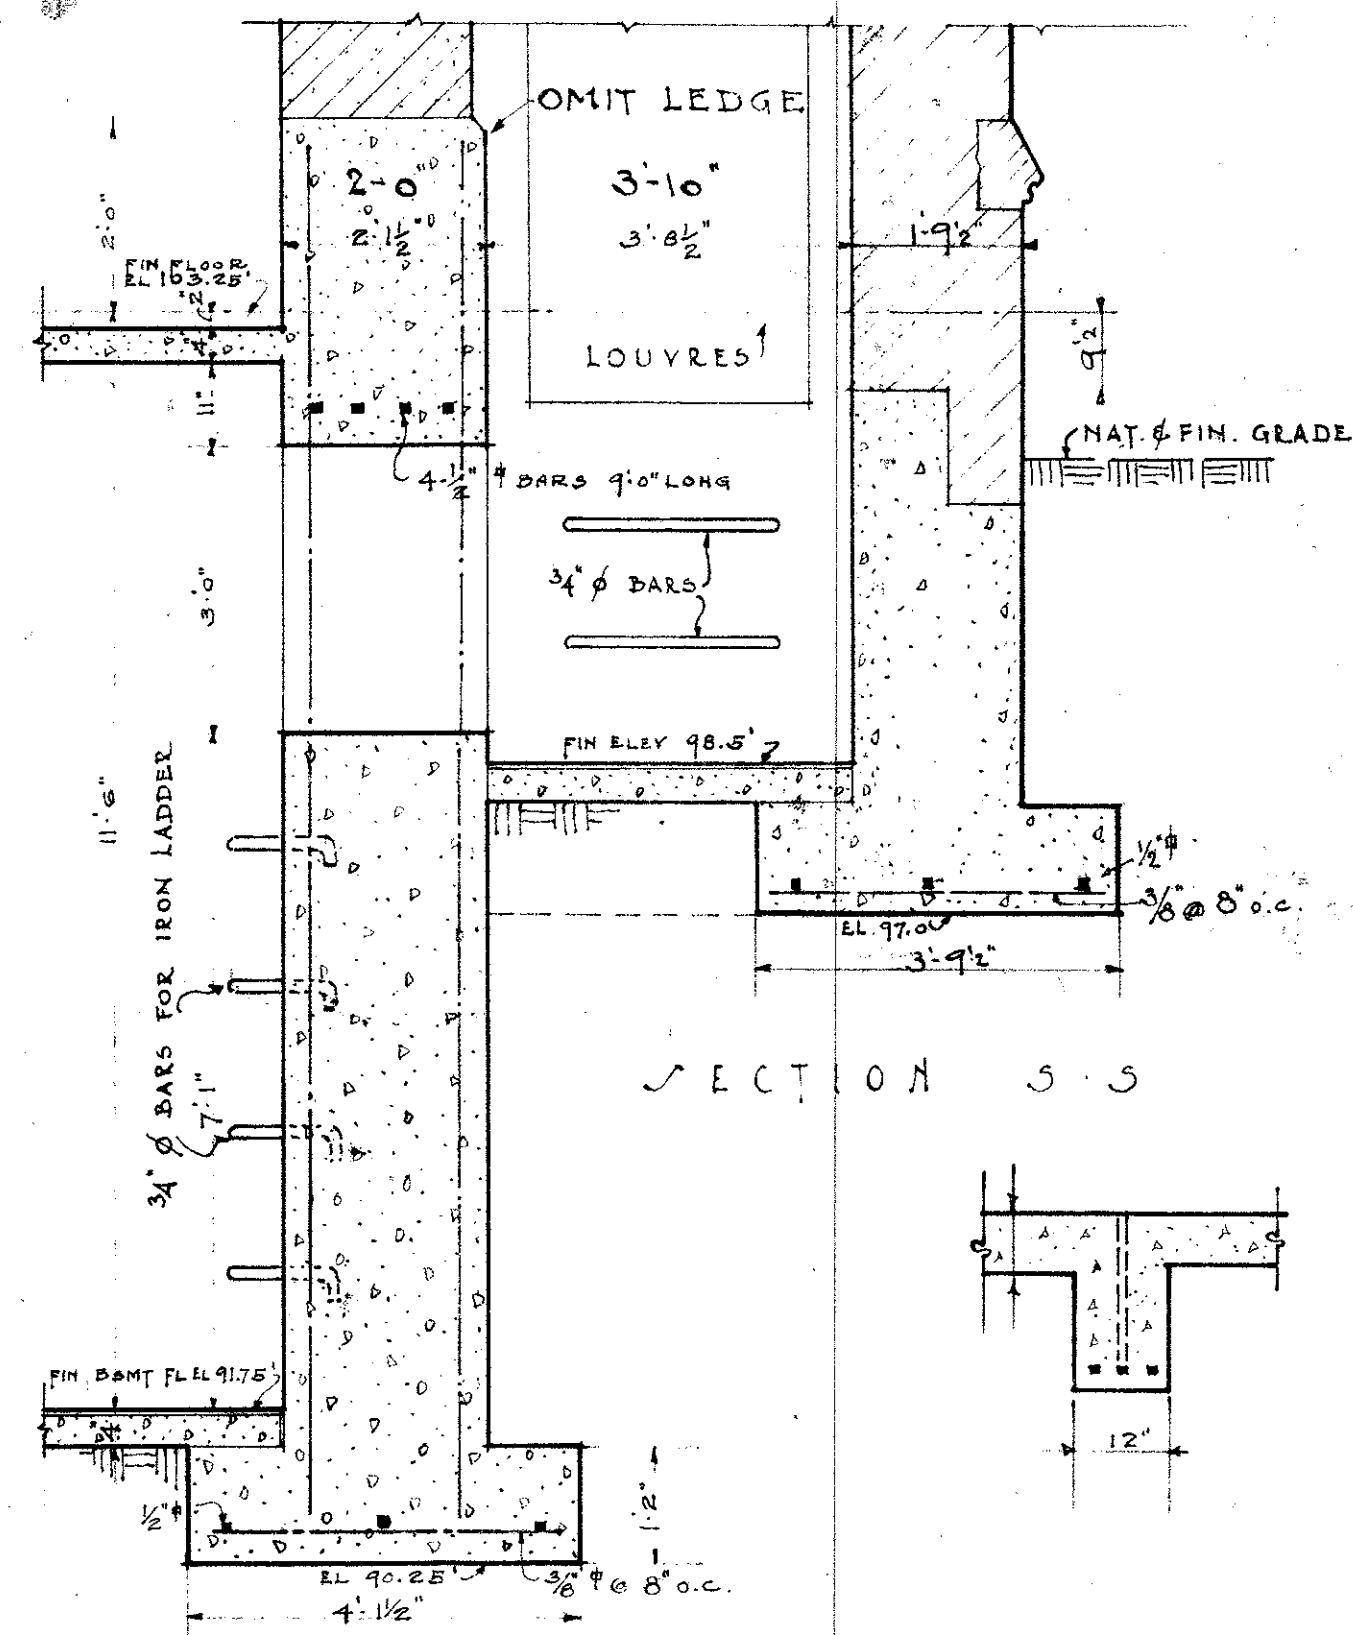


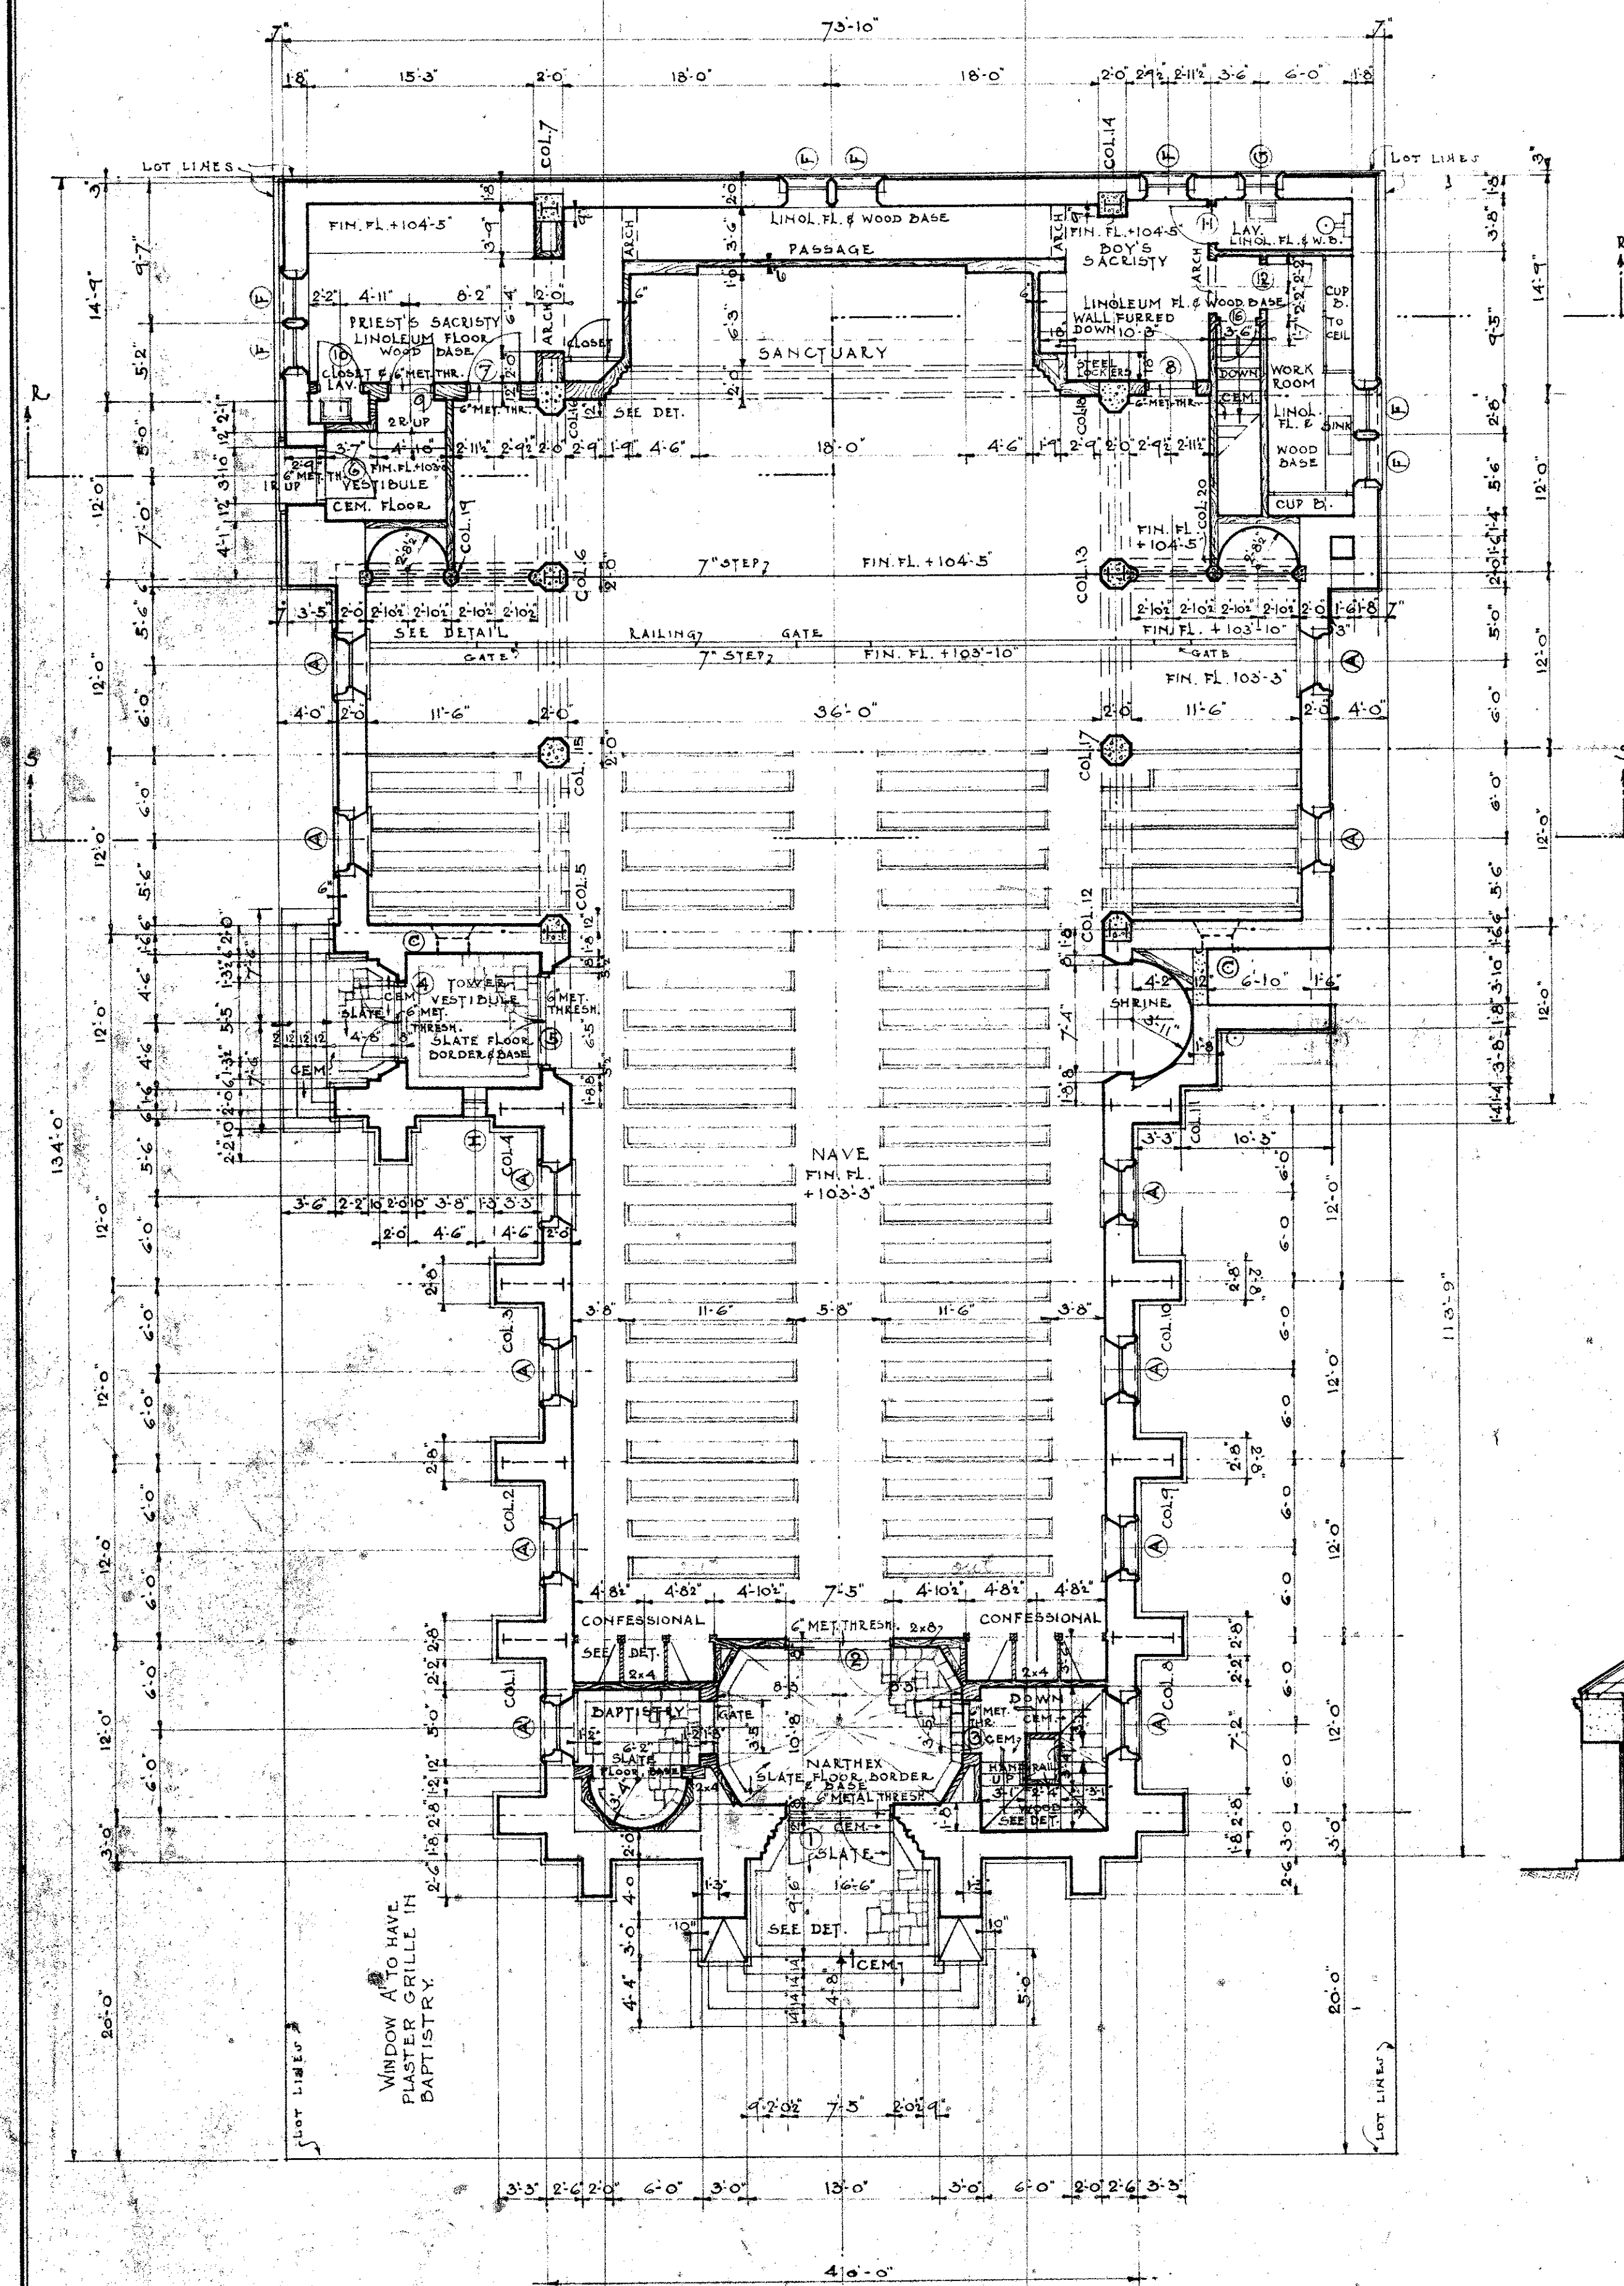


MAIN FLOOR PLAN
SCALE 1/8" = 1'-0"

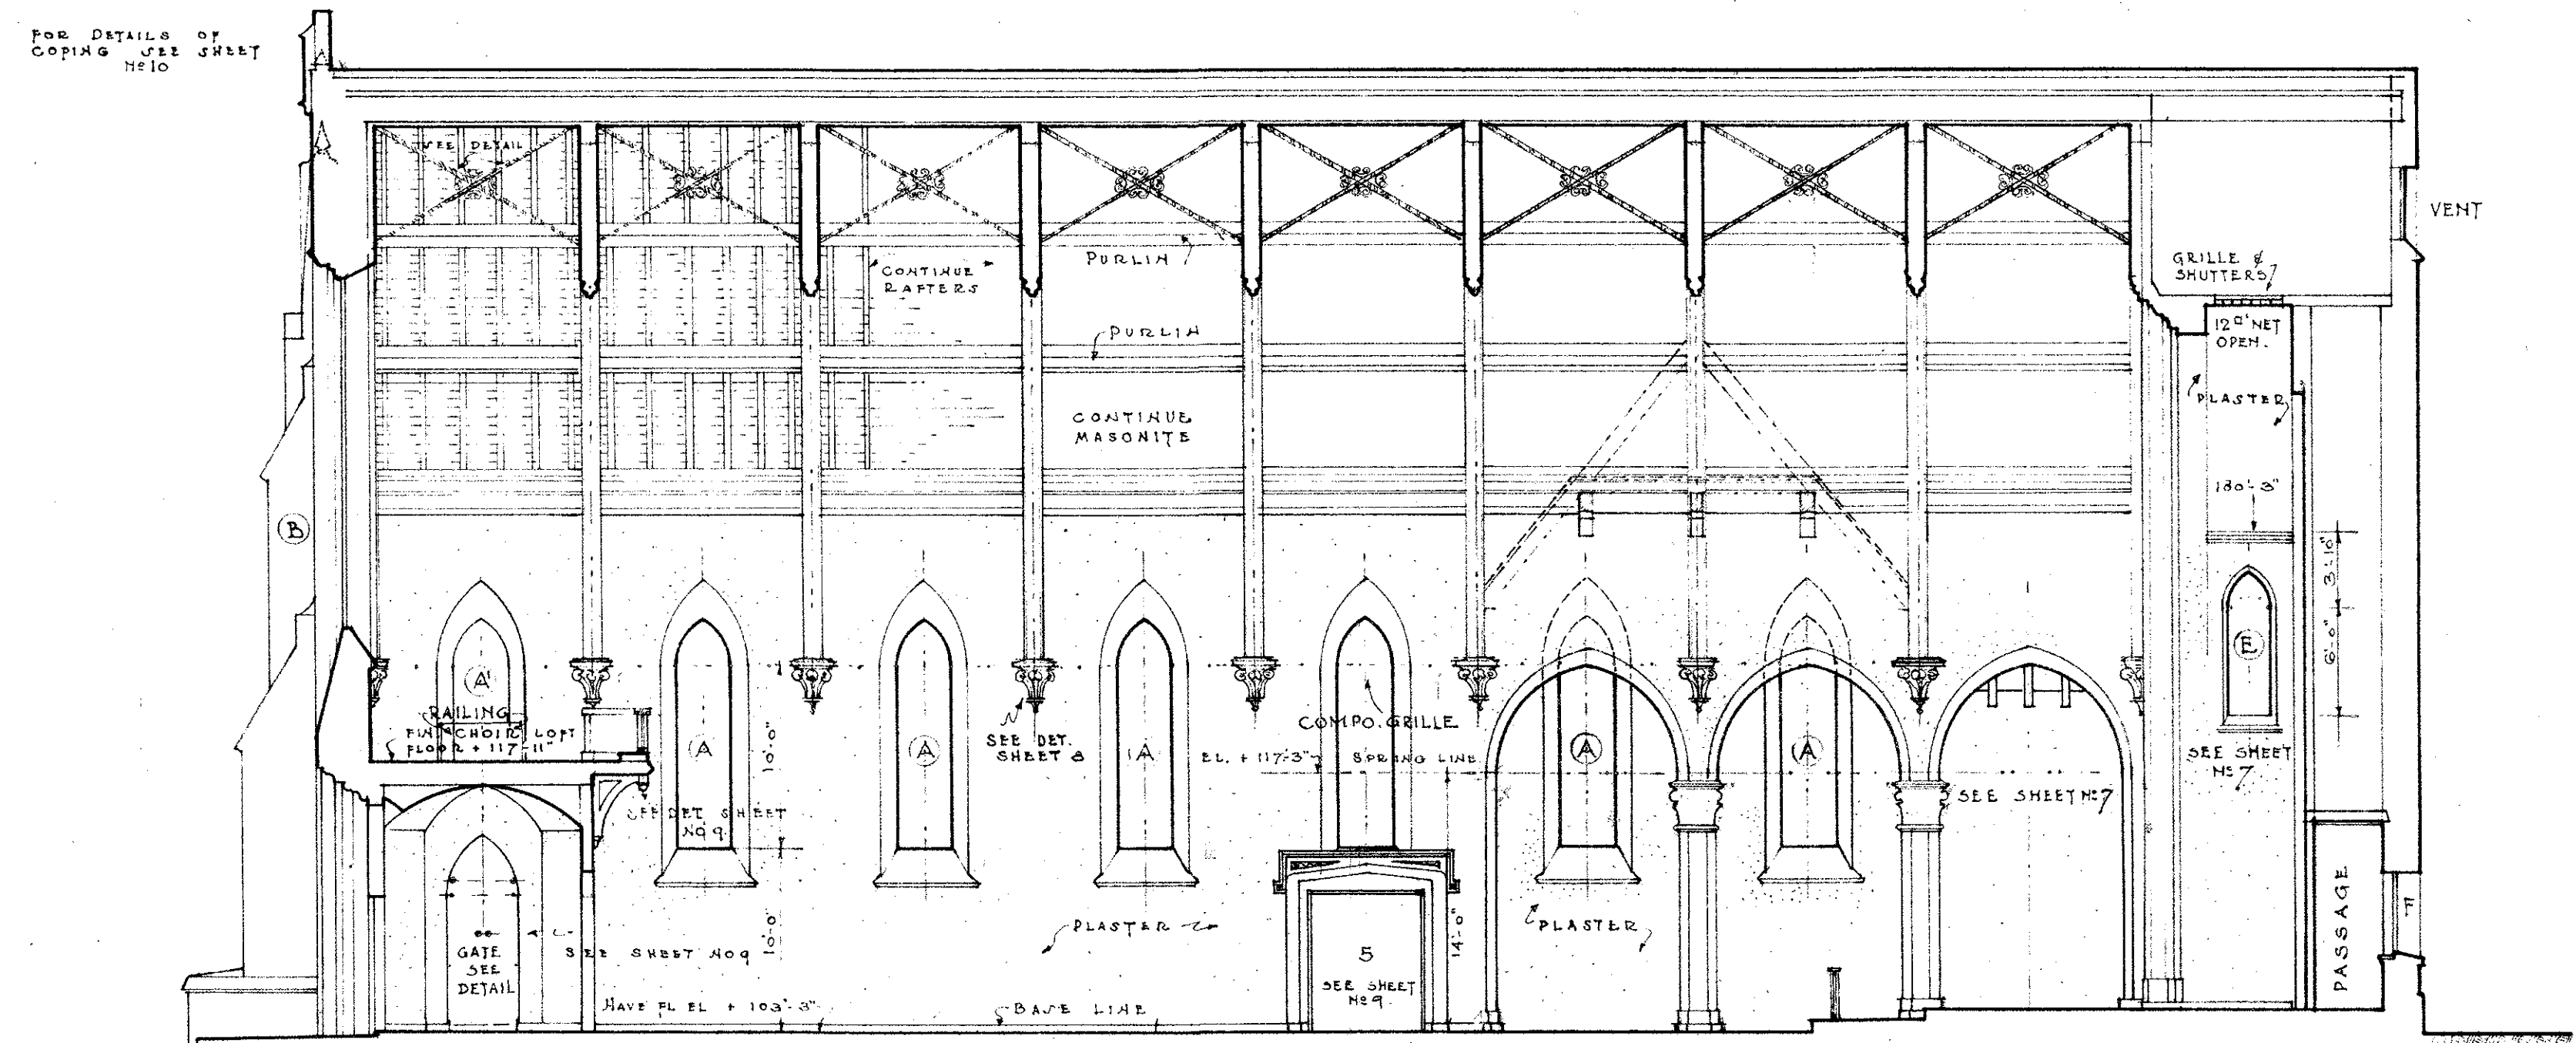


LONGITUDINAL SECTION

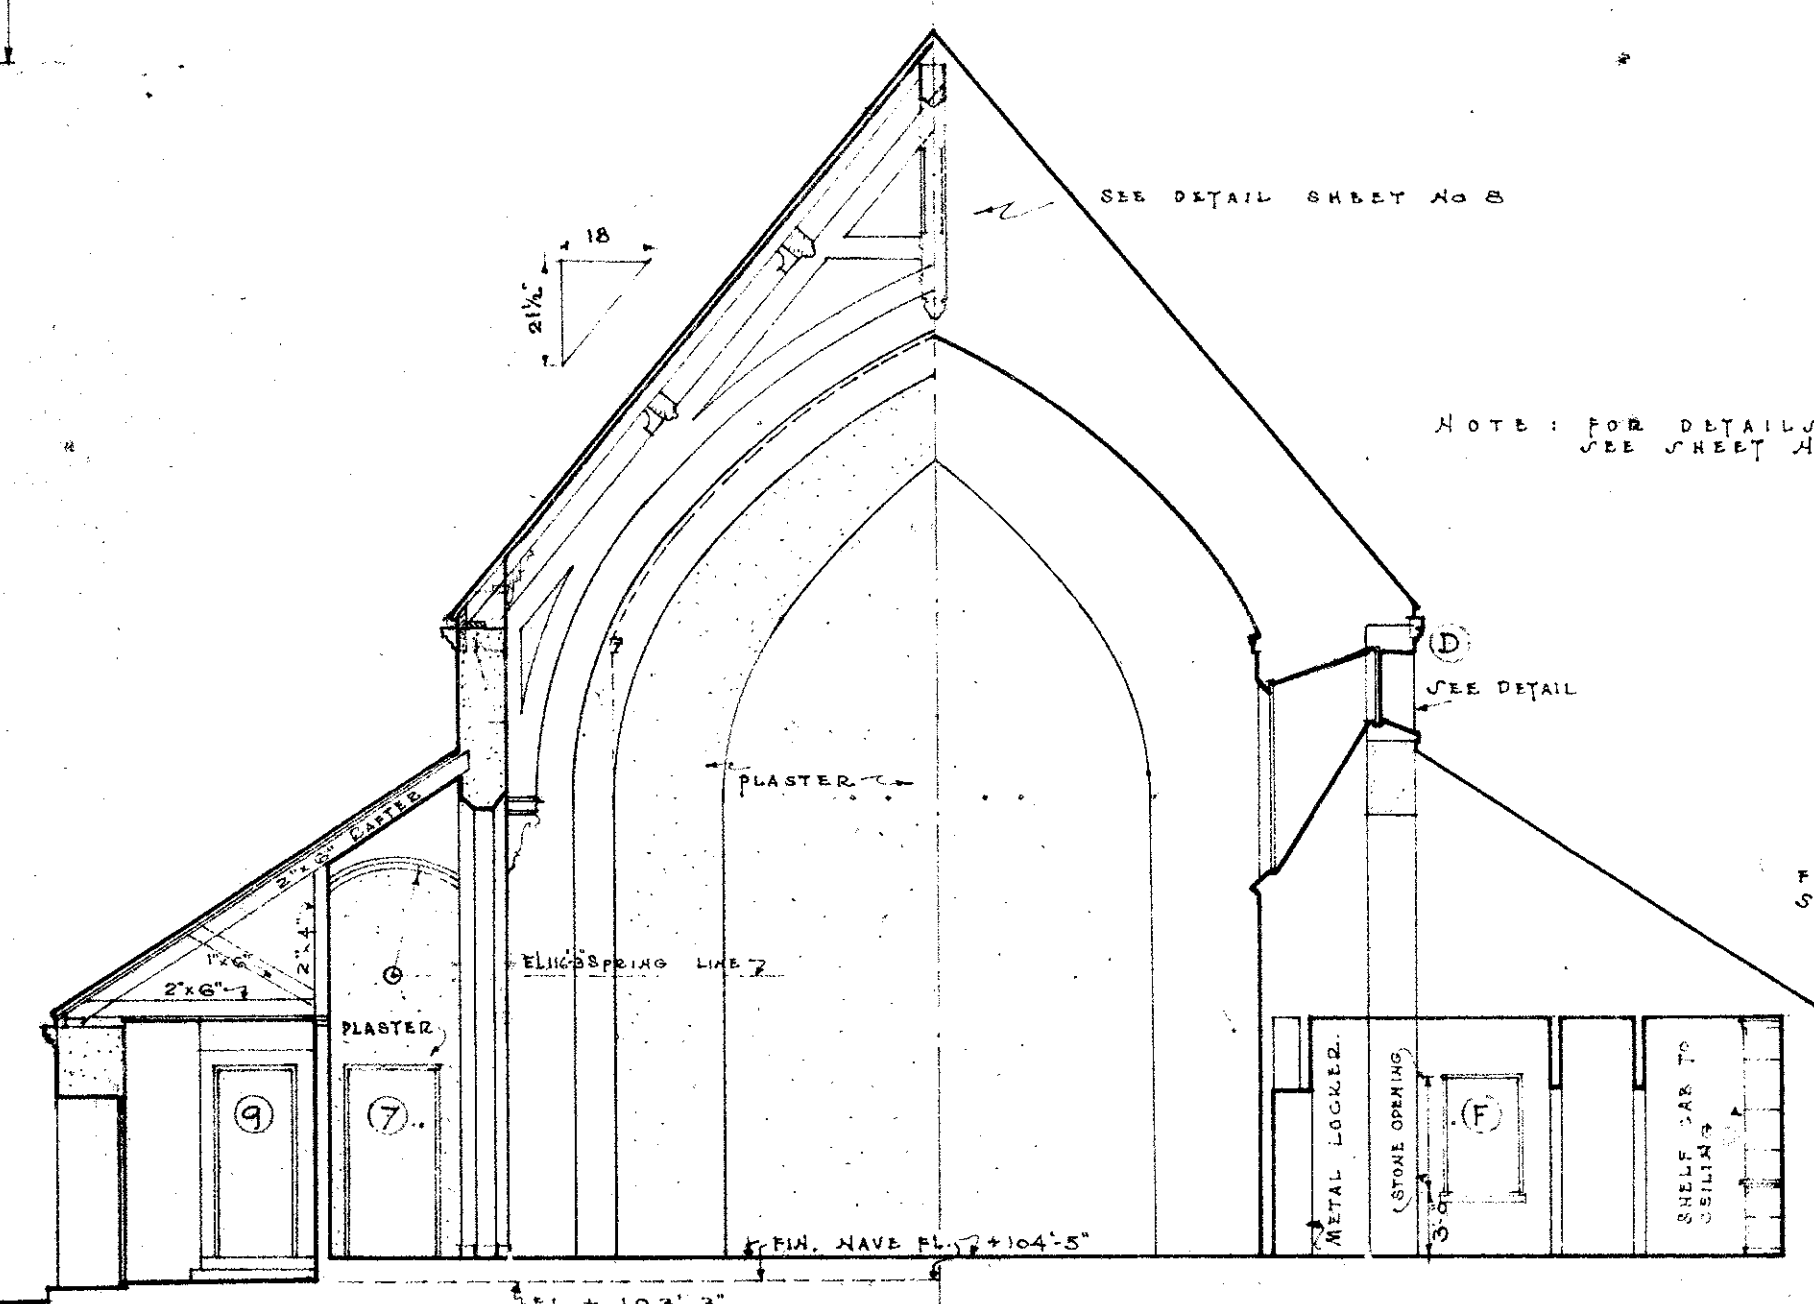

CROSS SECTION R-R

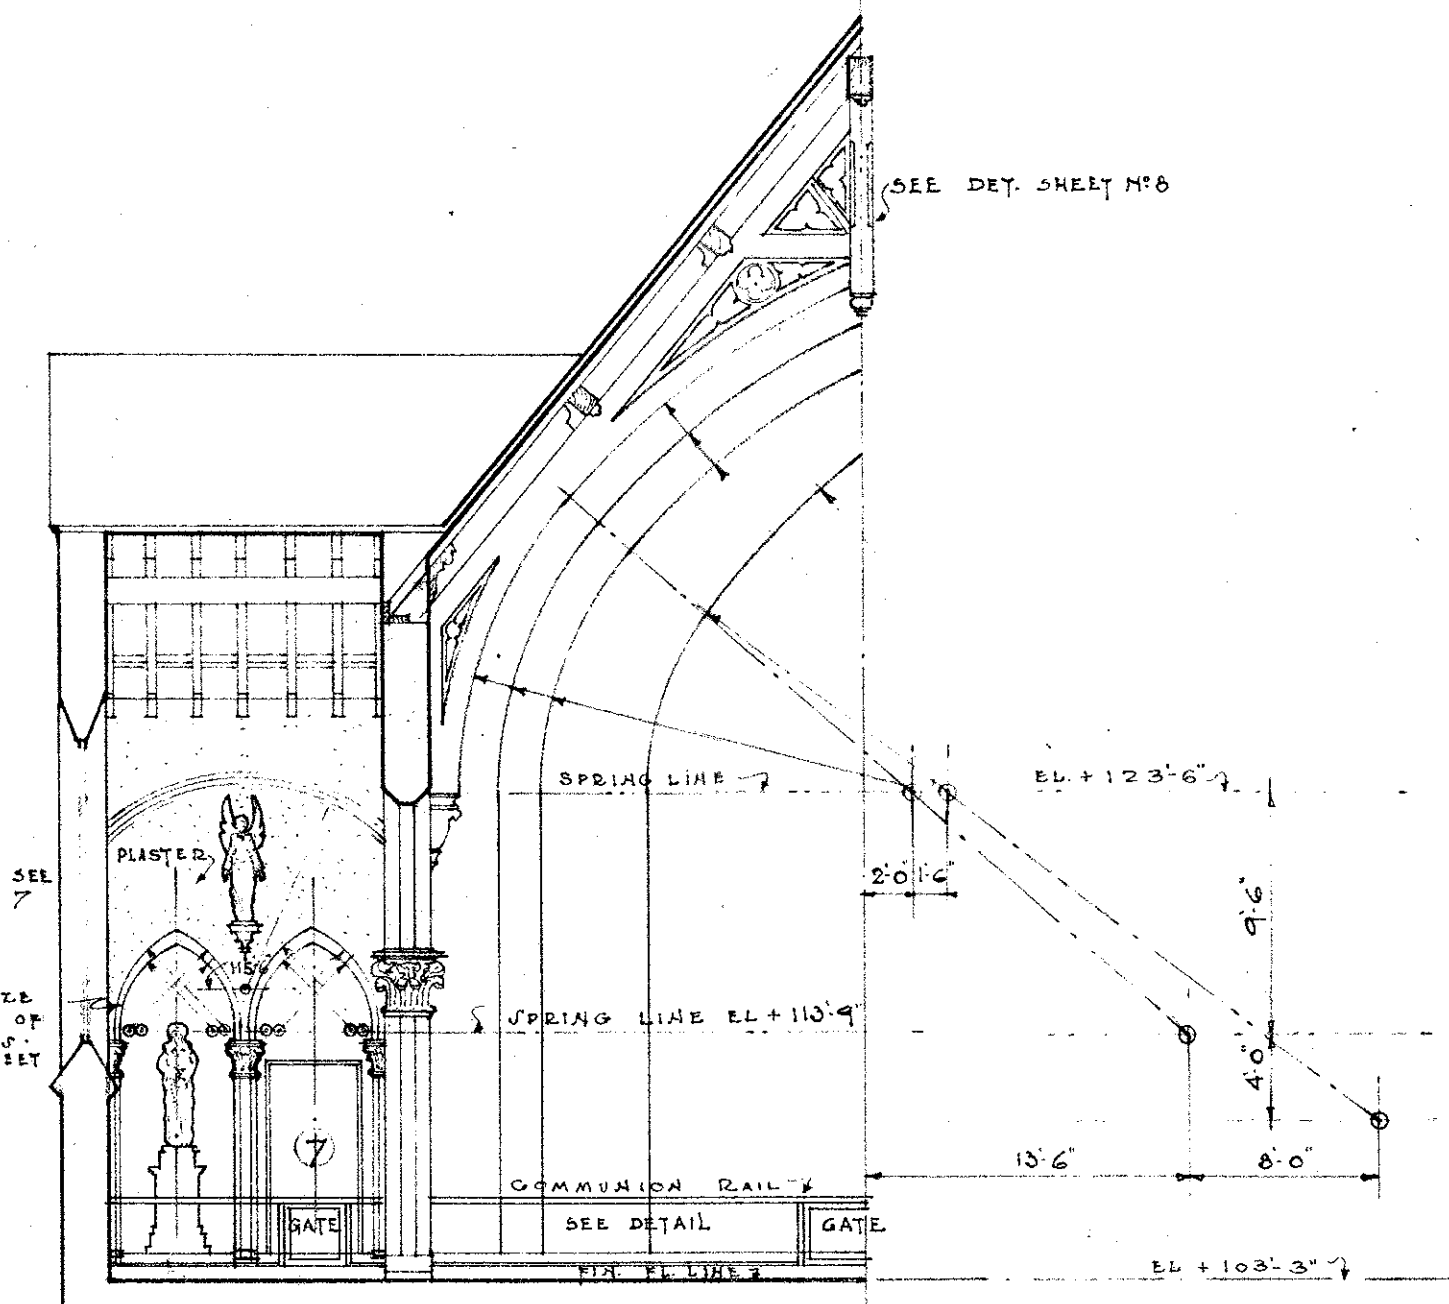

CROSS SECTION S-S

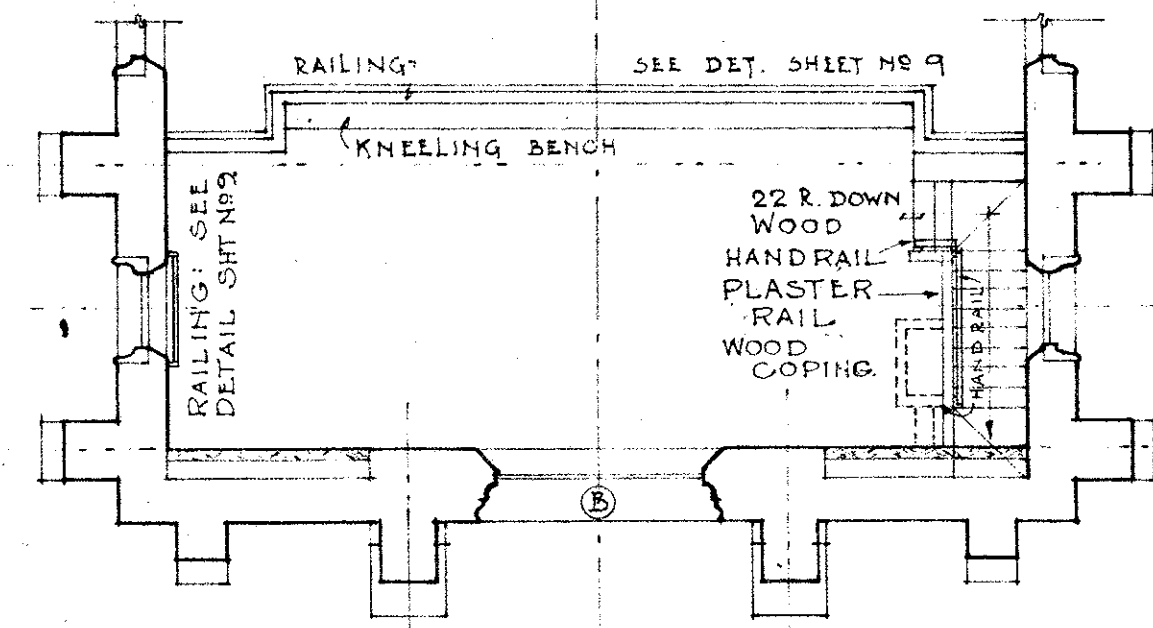


BALCONY FLOOR PLAN

DATE
SEPT. 14
OCT. 12
1929

REV EDWARD ALBOUY
RECTOR

LOCATED
NORTH EAST COR BEAVER & CHERRY
STREETS


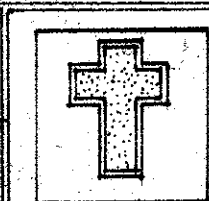


CHURCH OF THE NATIVITY
FLAG STAFF ARIZONA
FOR THE R.T. REV BISHOP
OF THE DIOCESE OF TUCSON


COMM EMMET G MARTIN
ARCHITECT

131 821 CHESTER WILLIAMS BLDG
LOS ANGELES CAL


SHEET 4

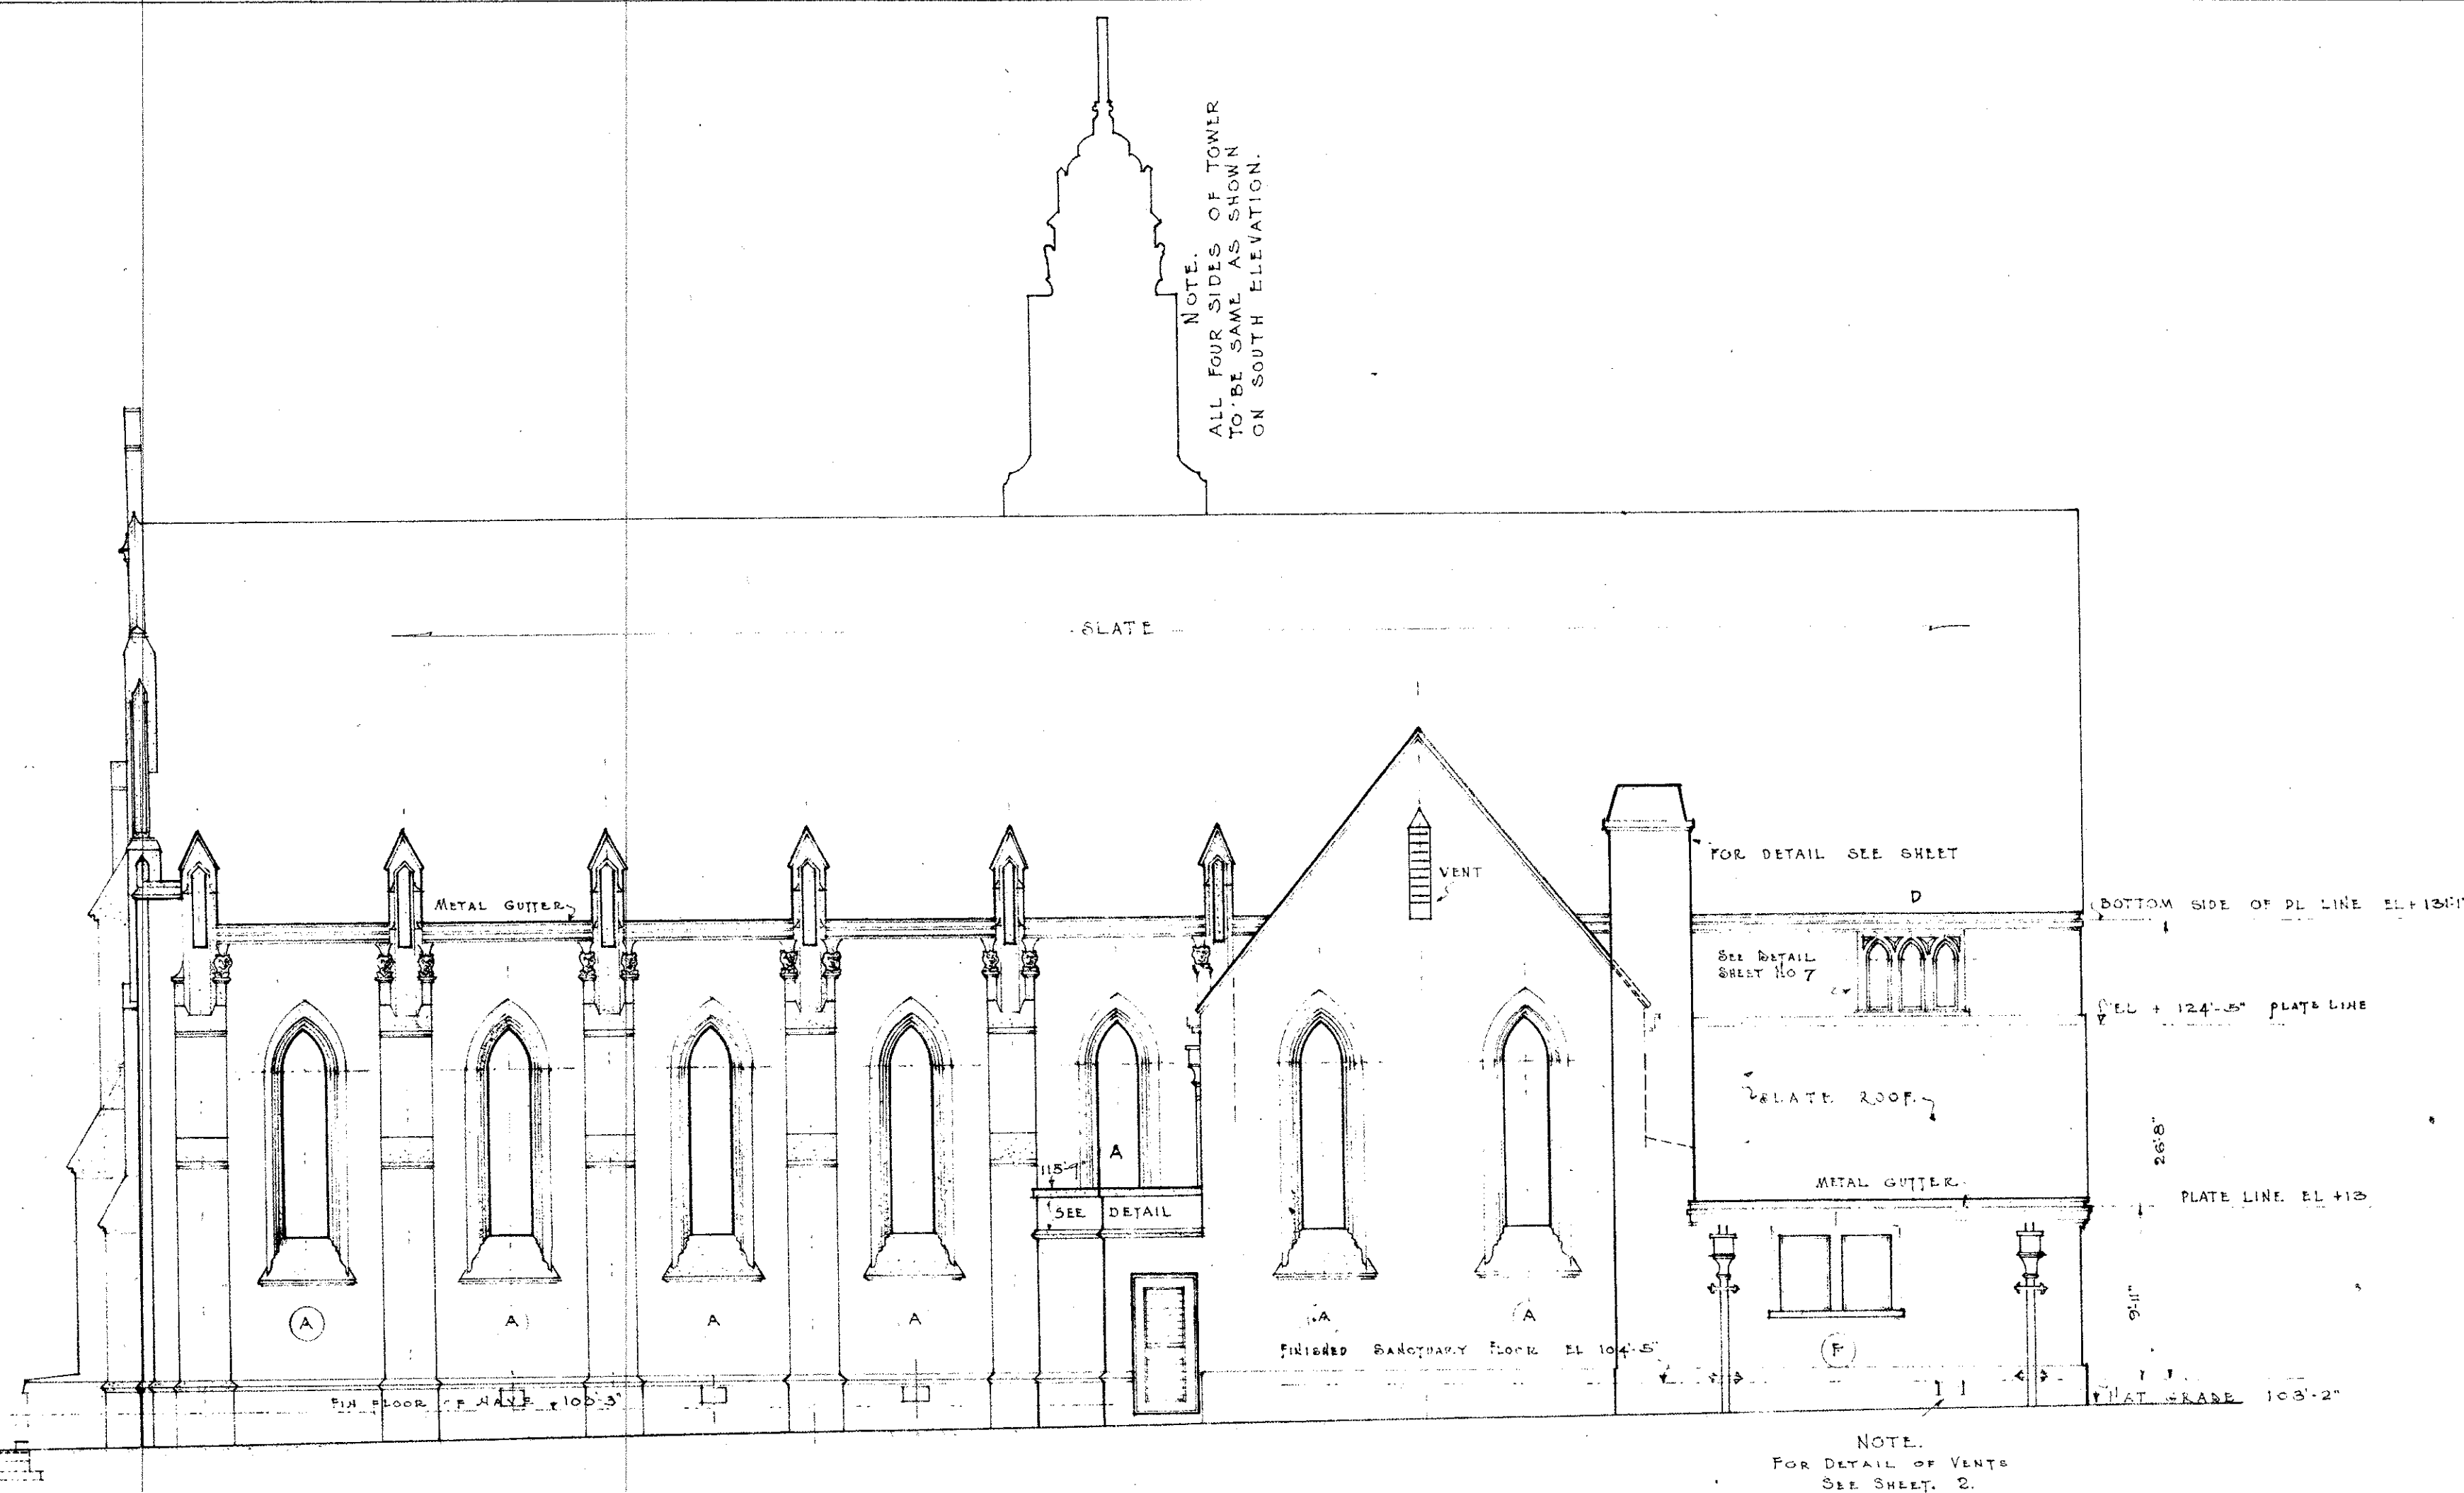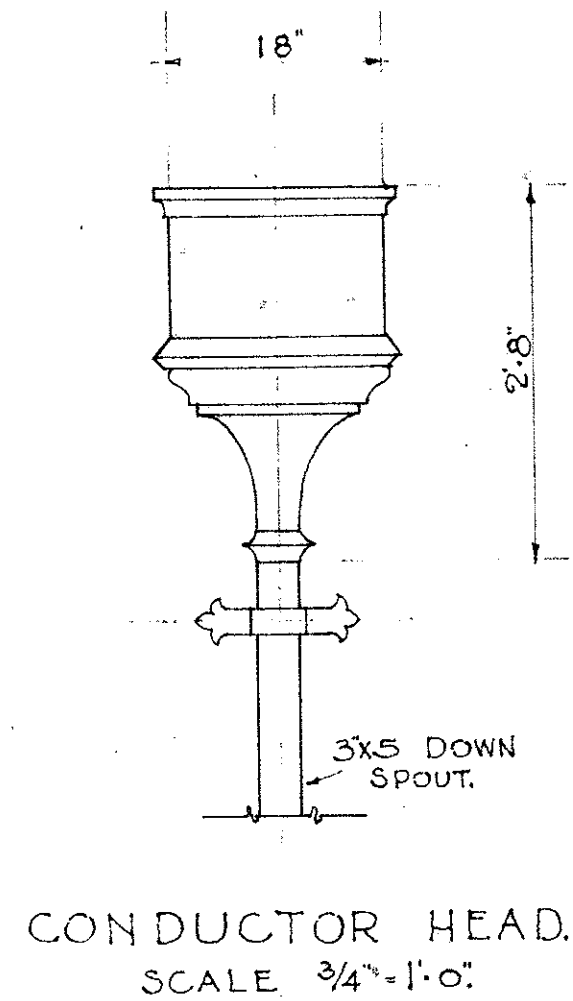


EAST ELEVATION
SCALE 1/8"=1'-0"

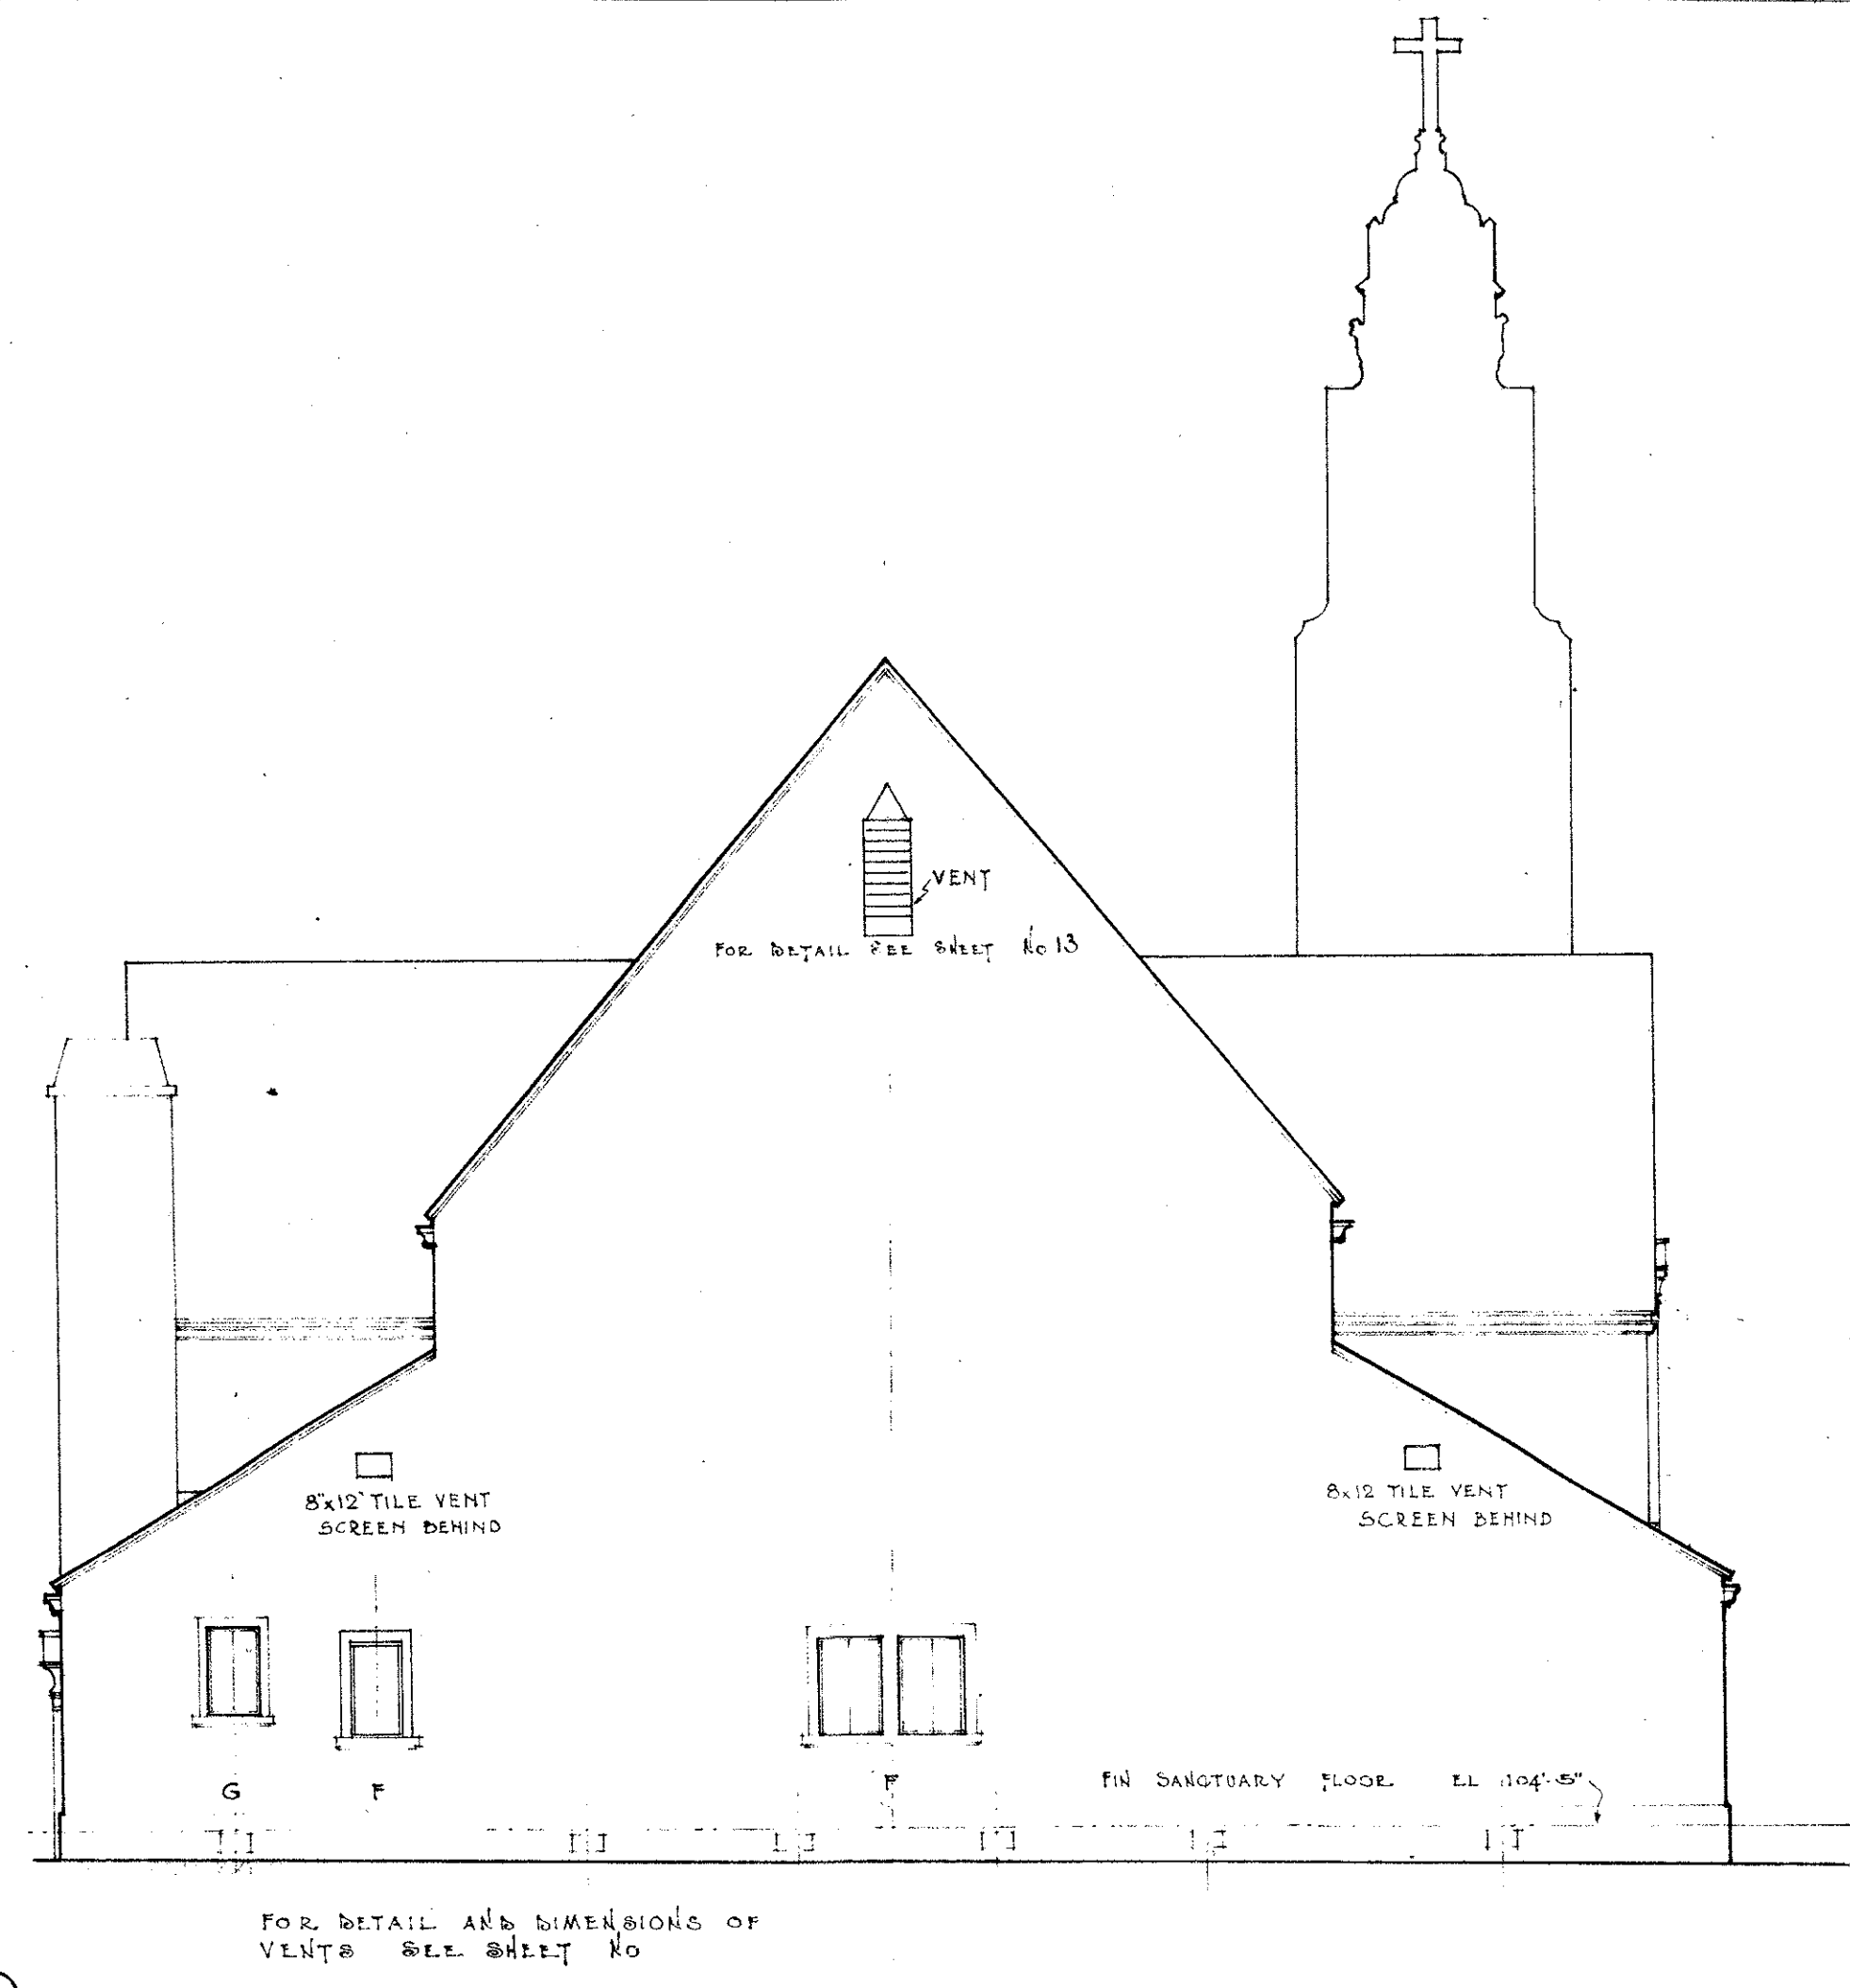


NORTH ELEVATION
SCALE 1/8"=1'-0"

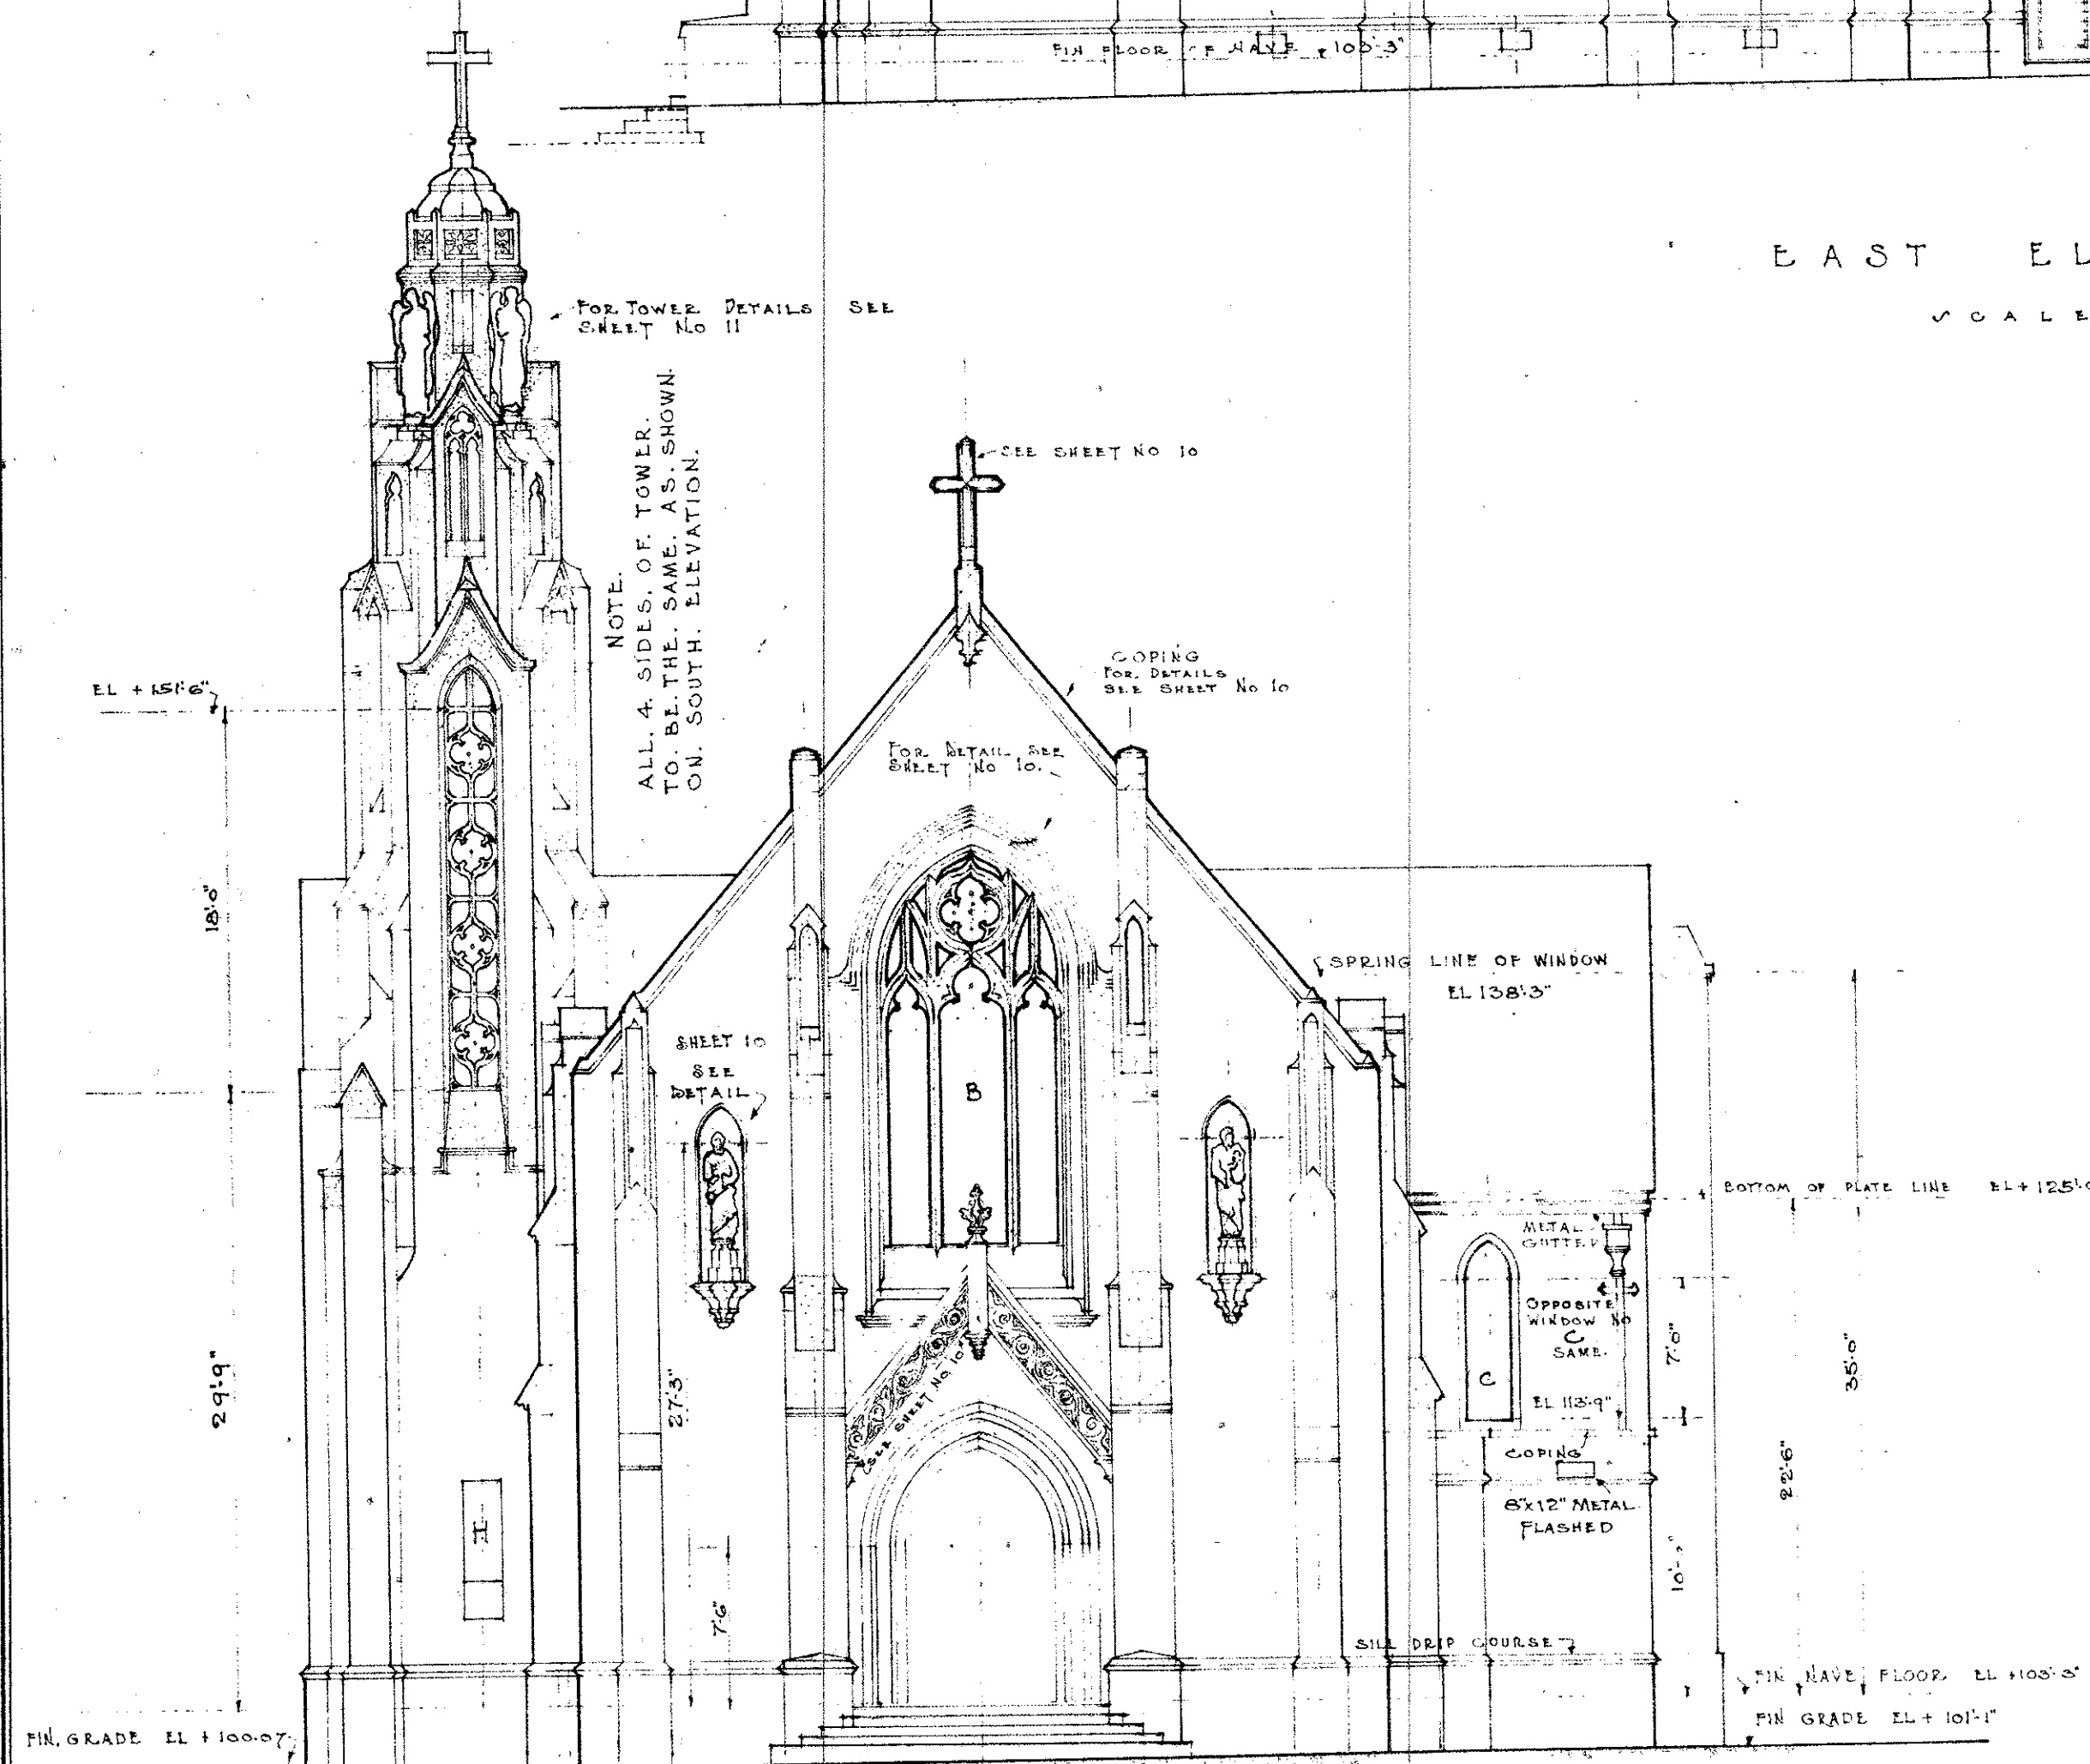


SOUTH ELEVATION
SCALE 1/8"=1'-0"

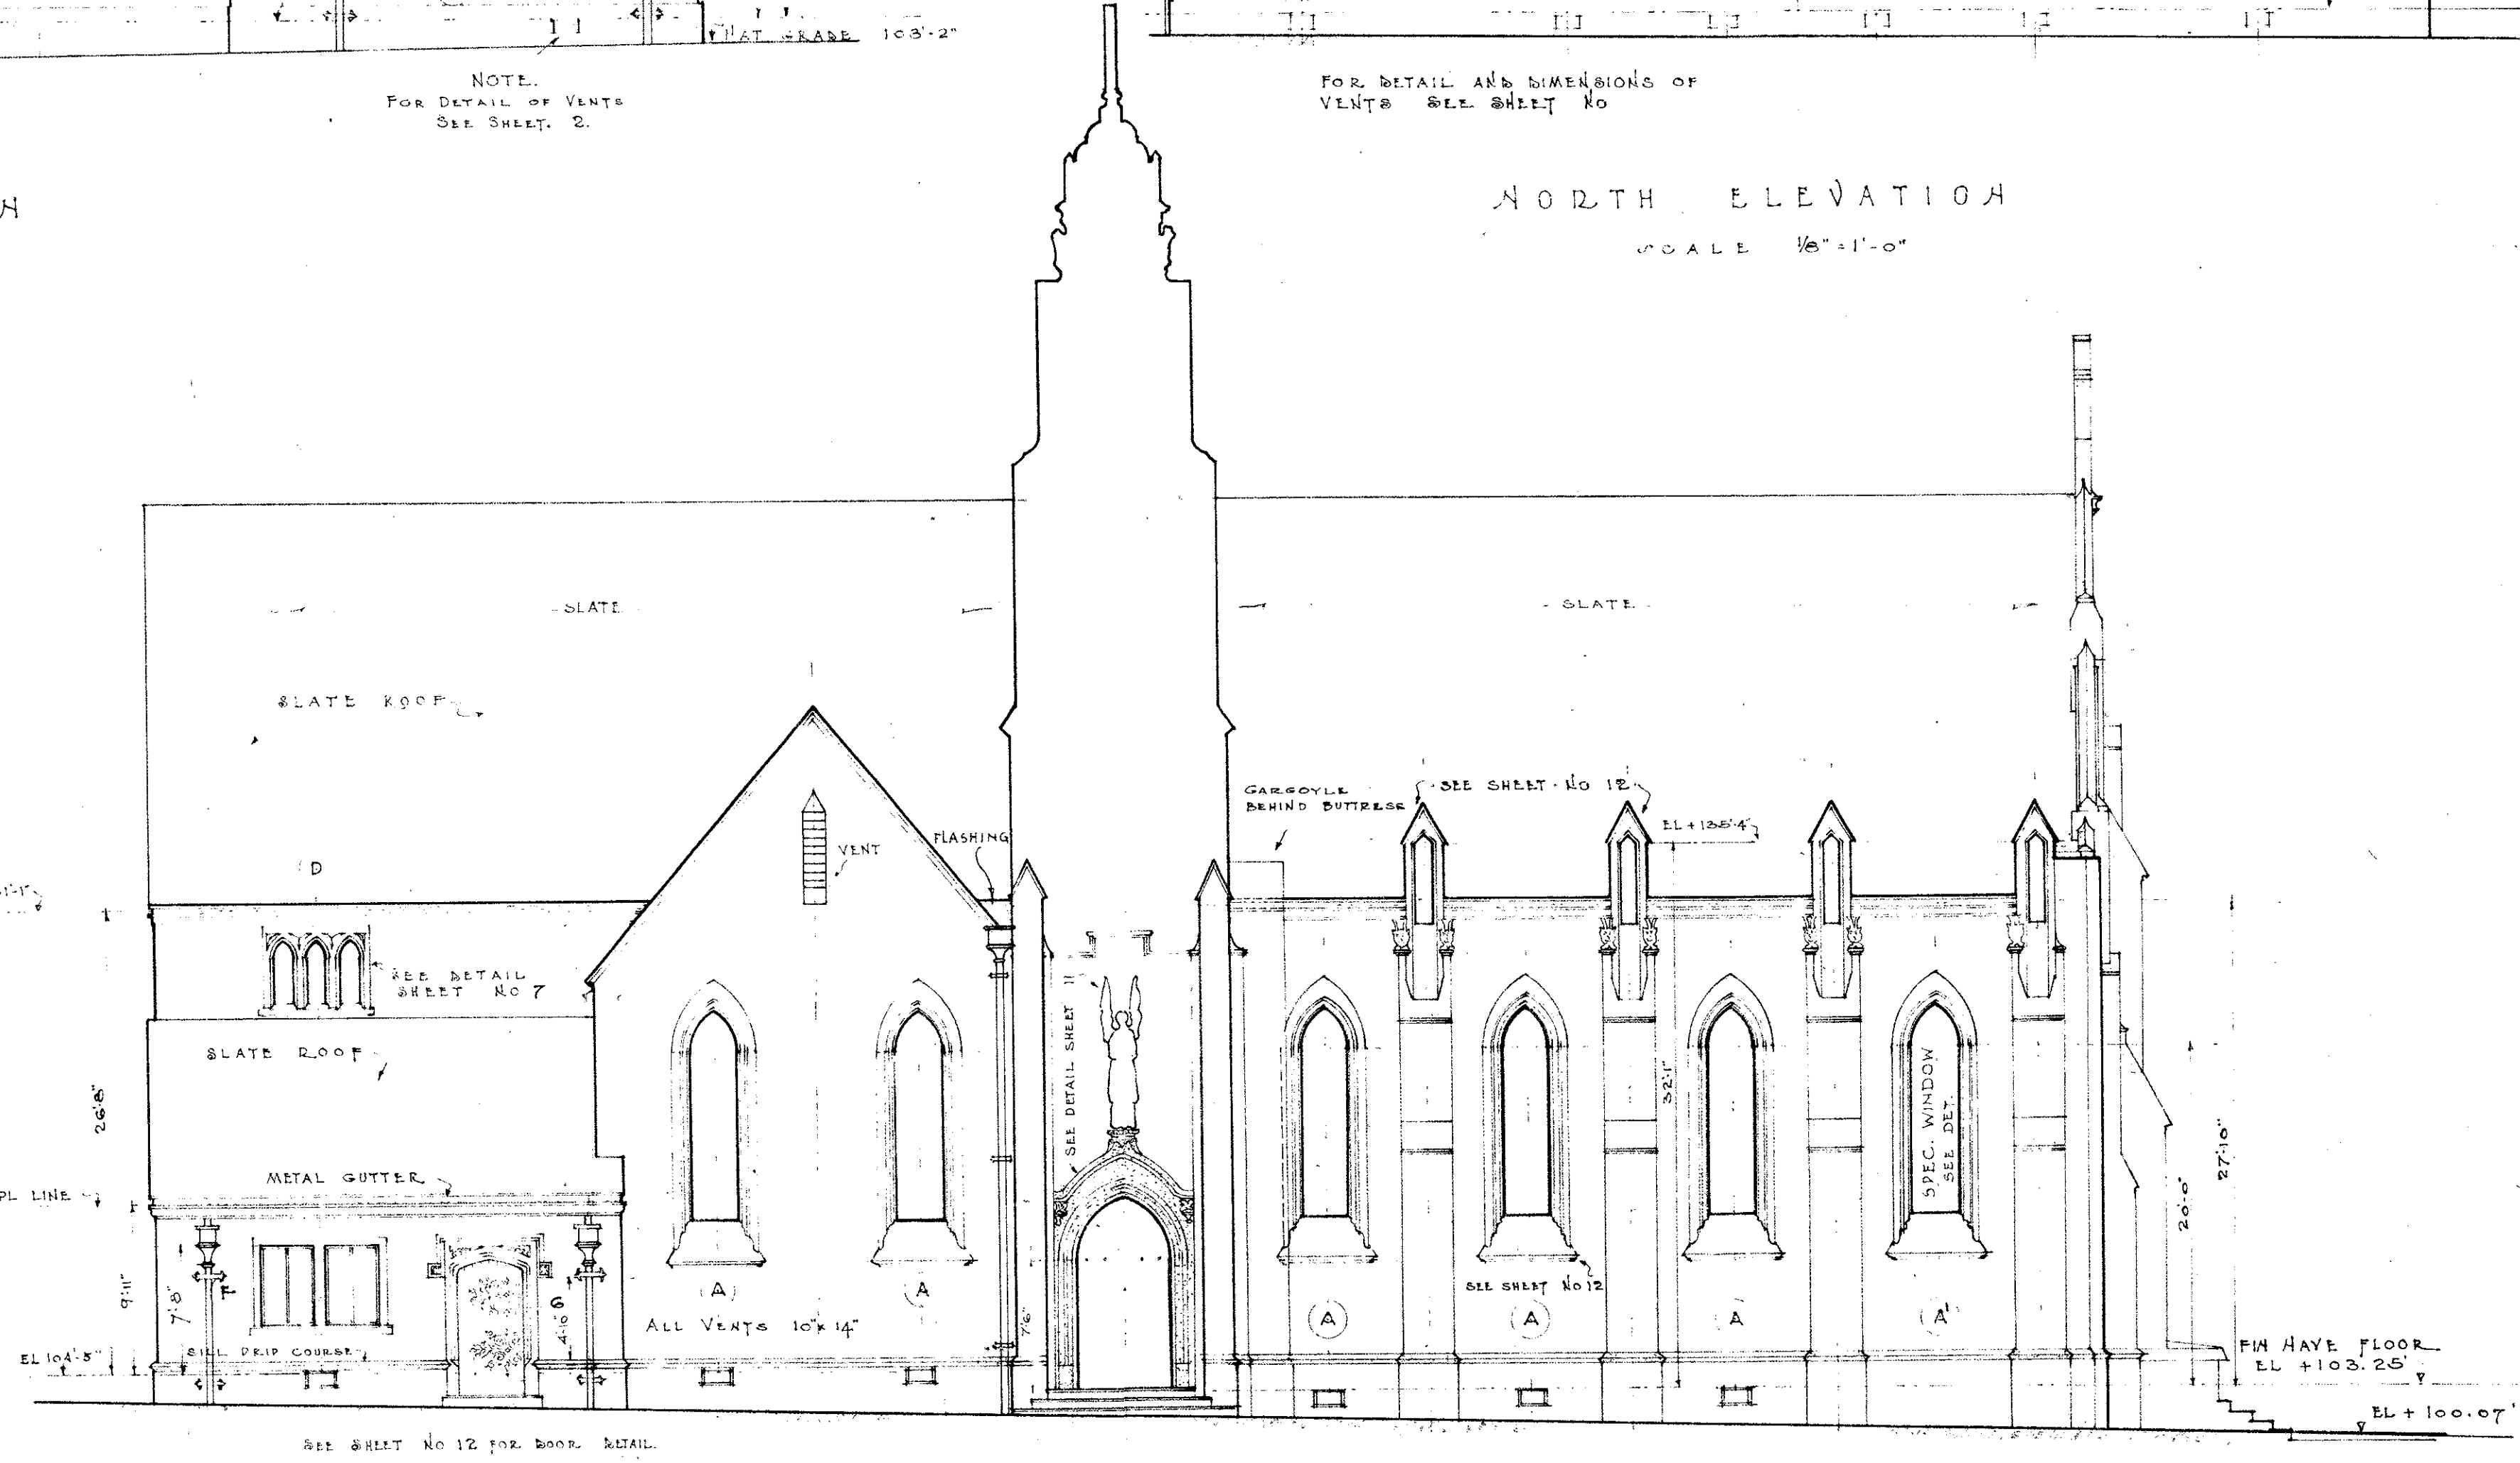

WEST ELEVATION
SCALE 1/8"=1'-0"

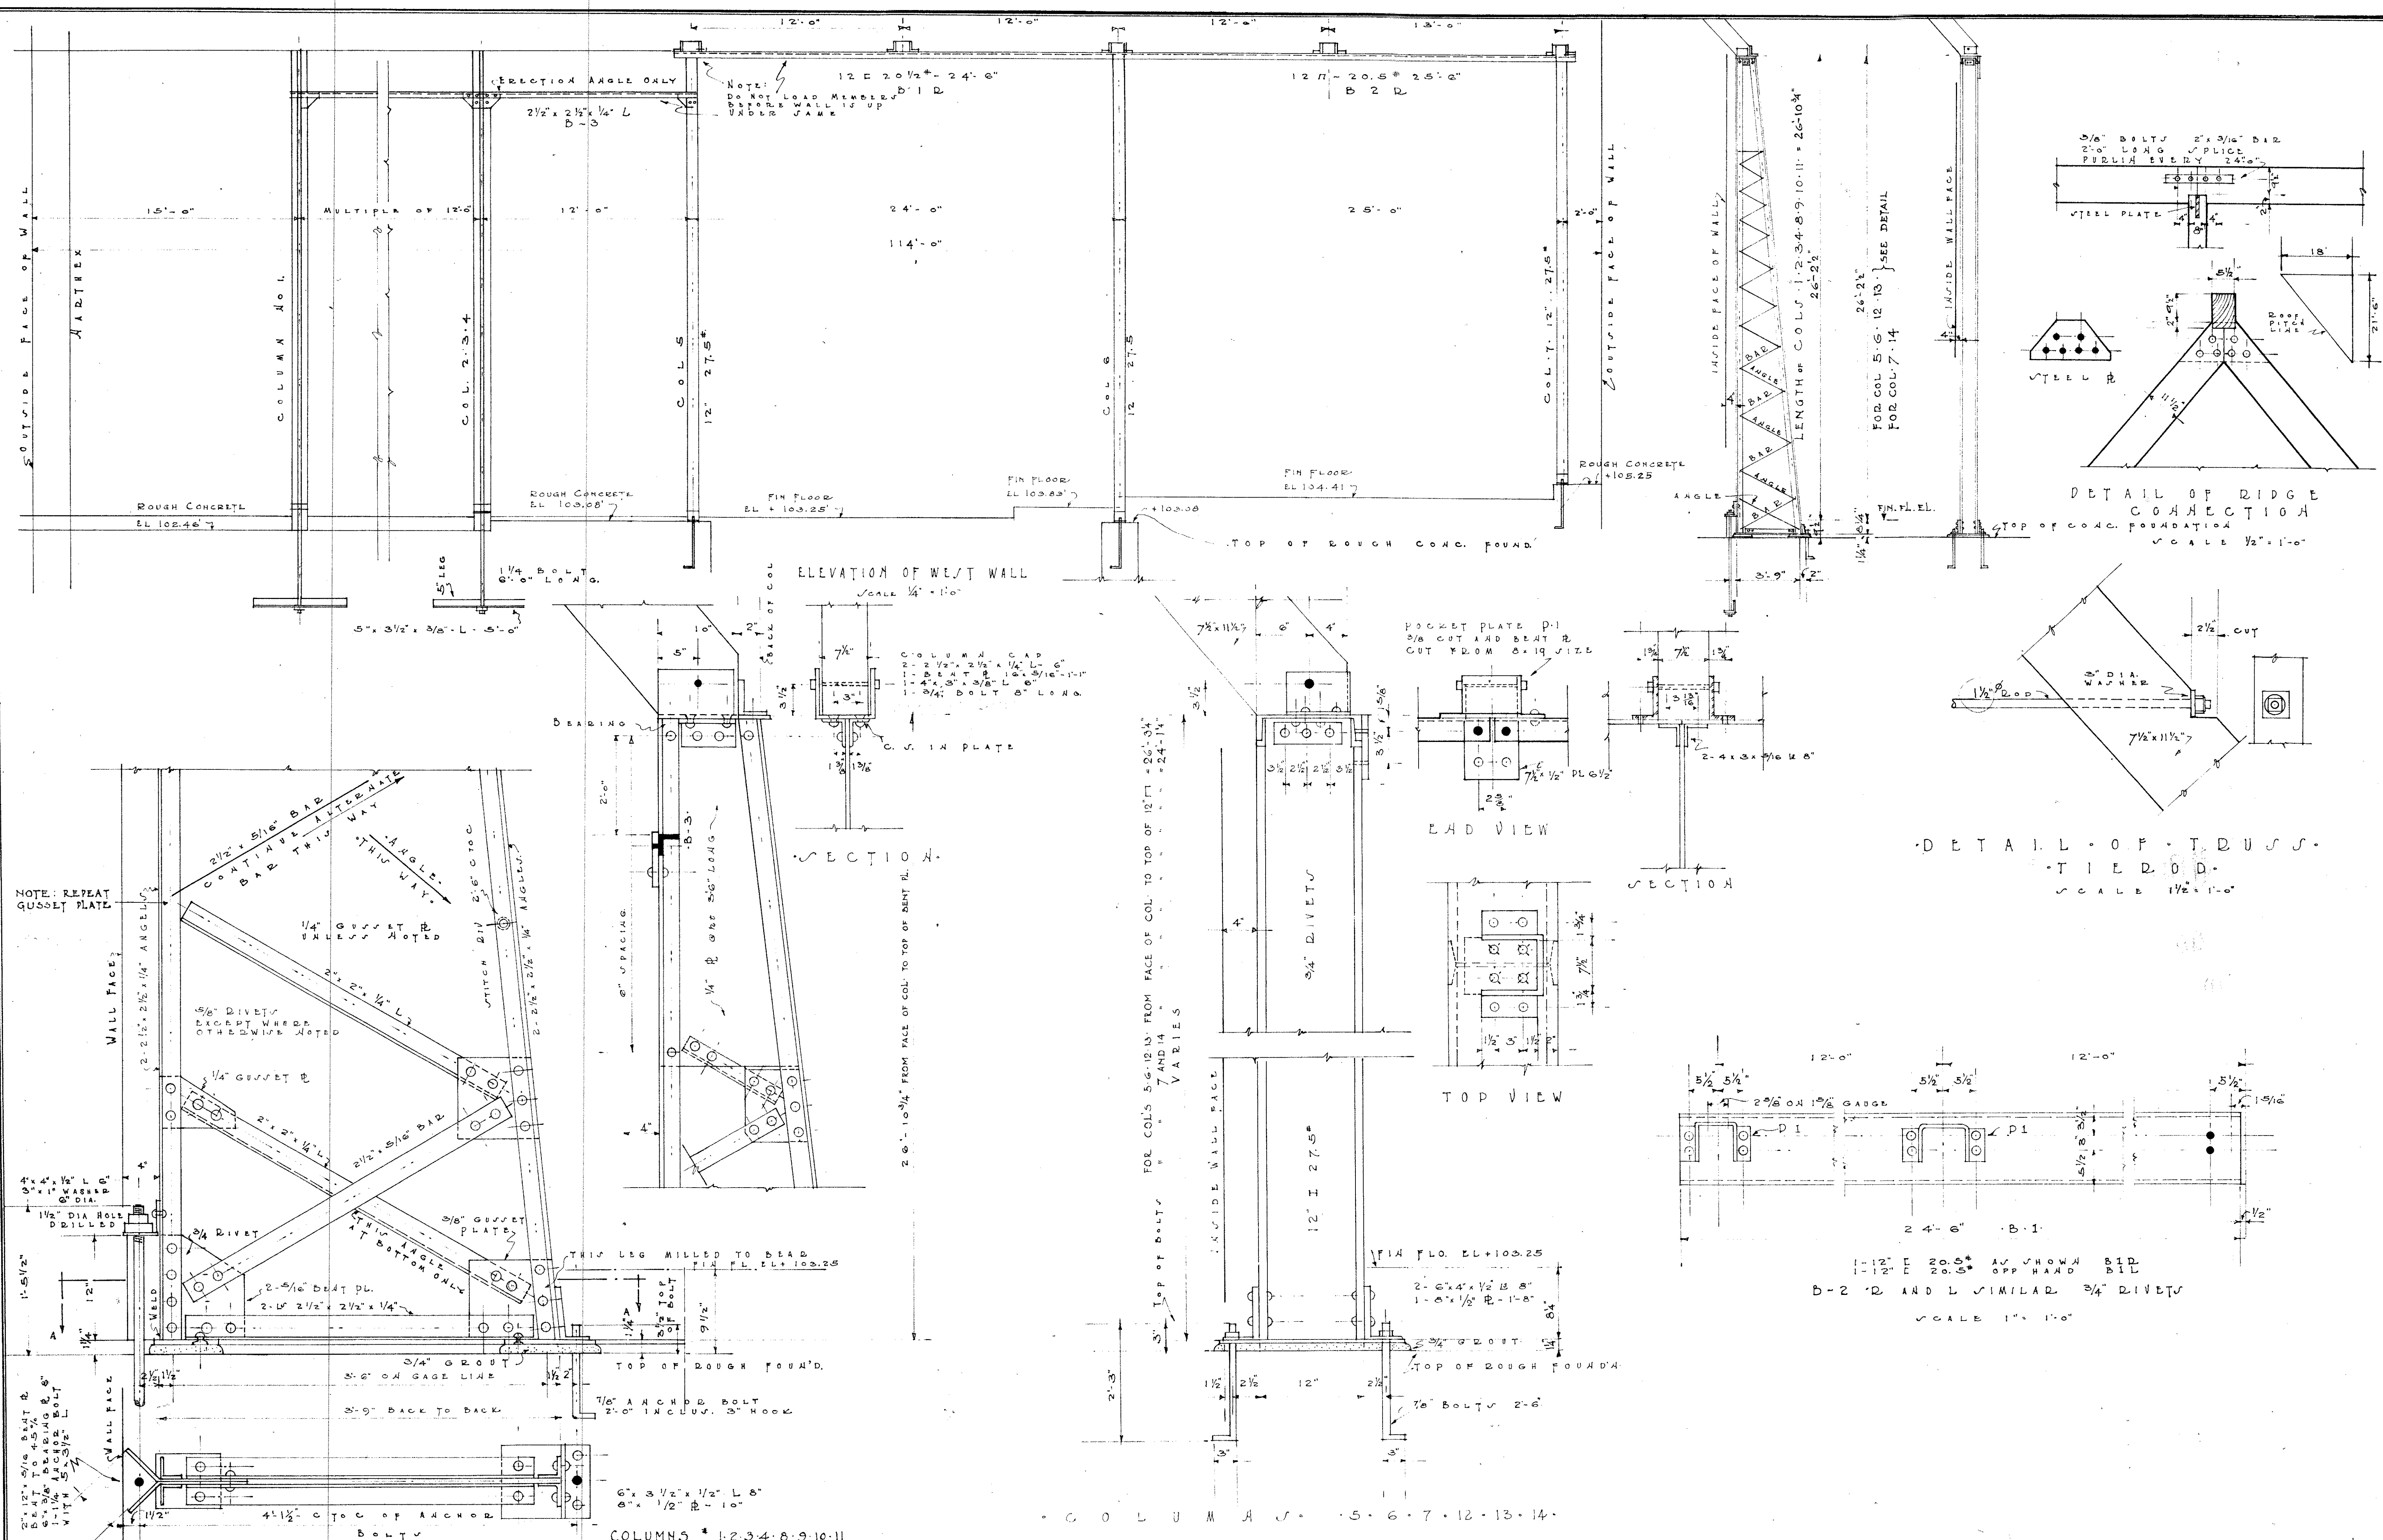


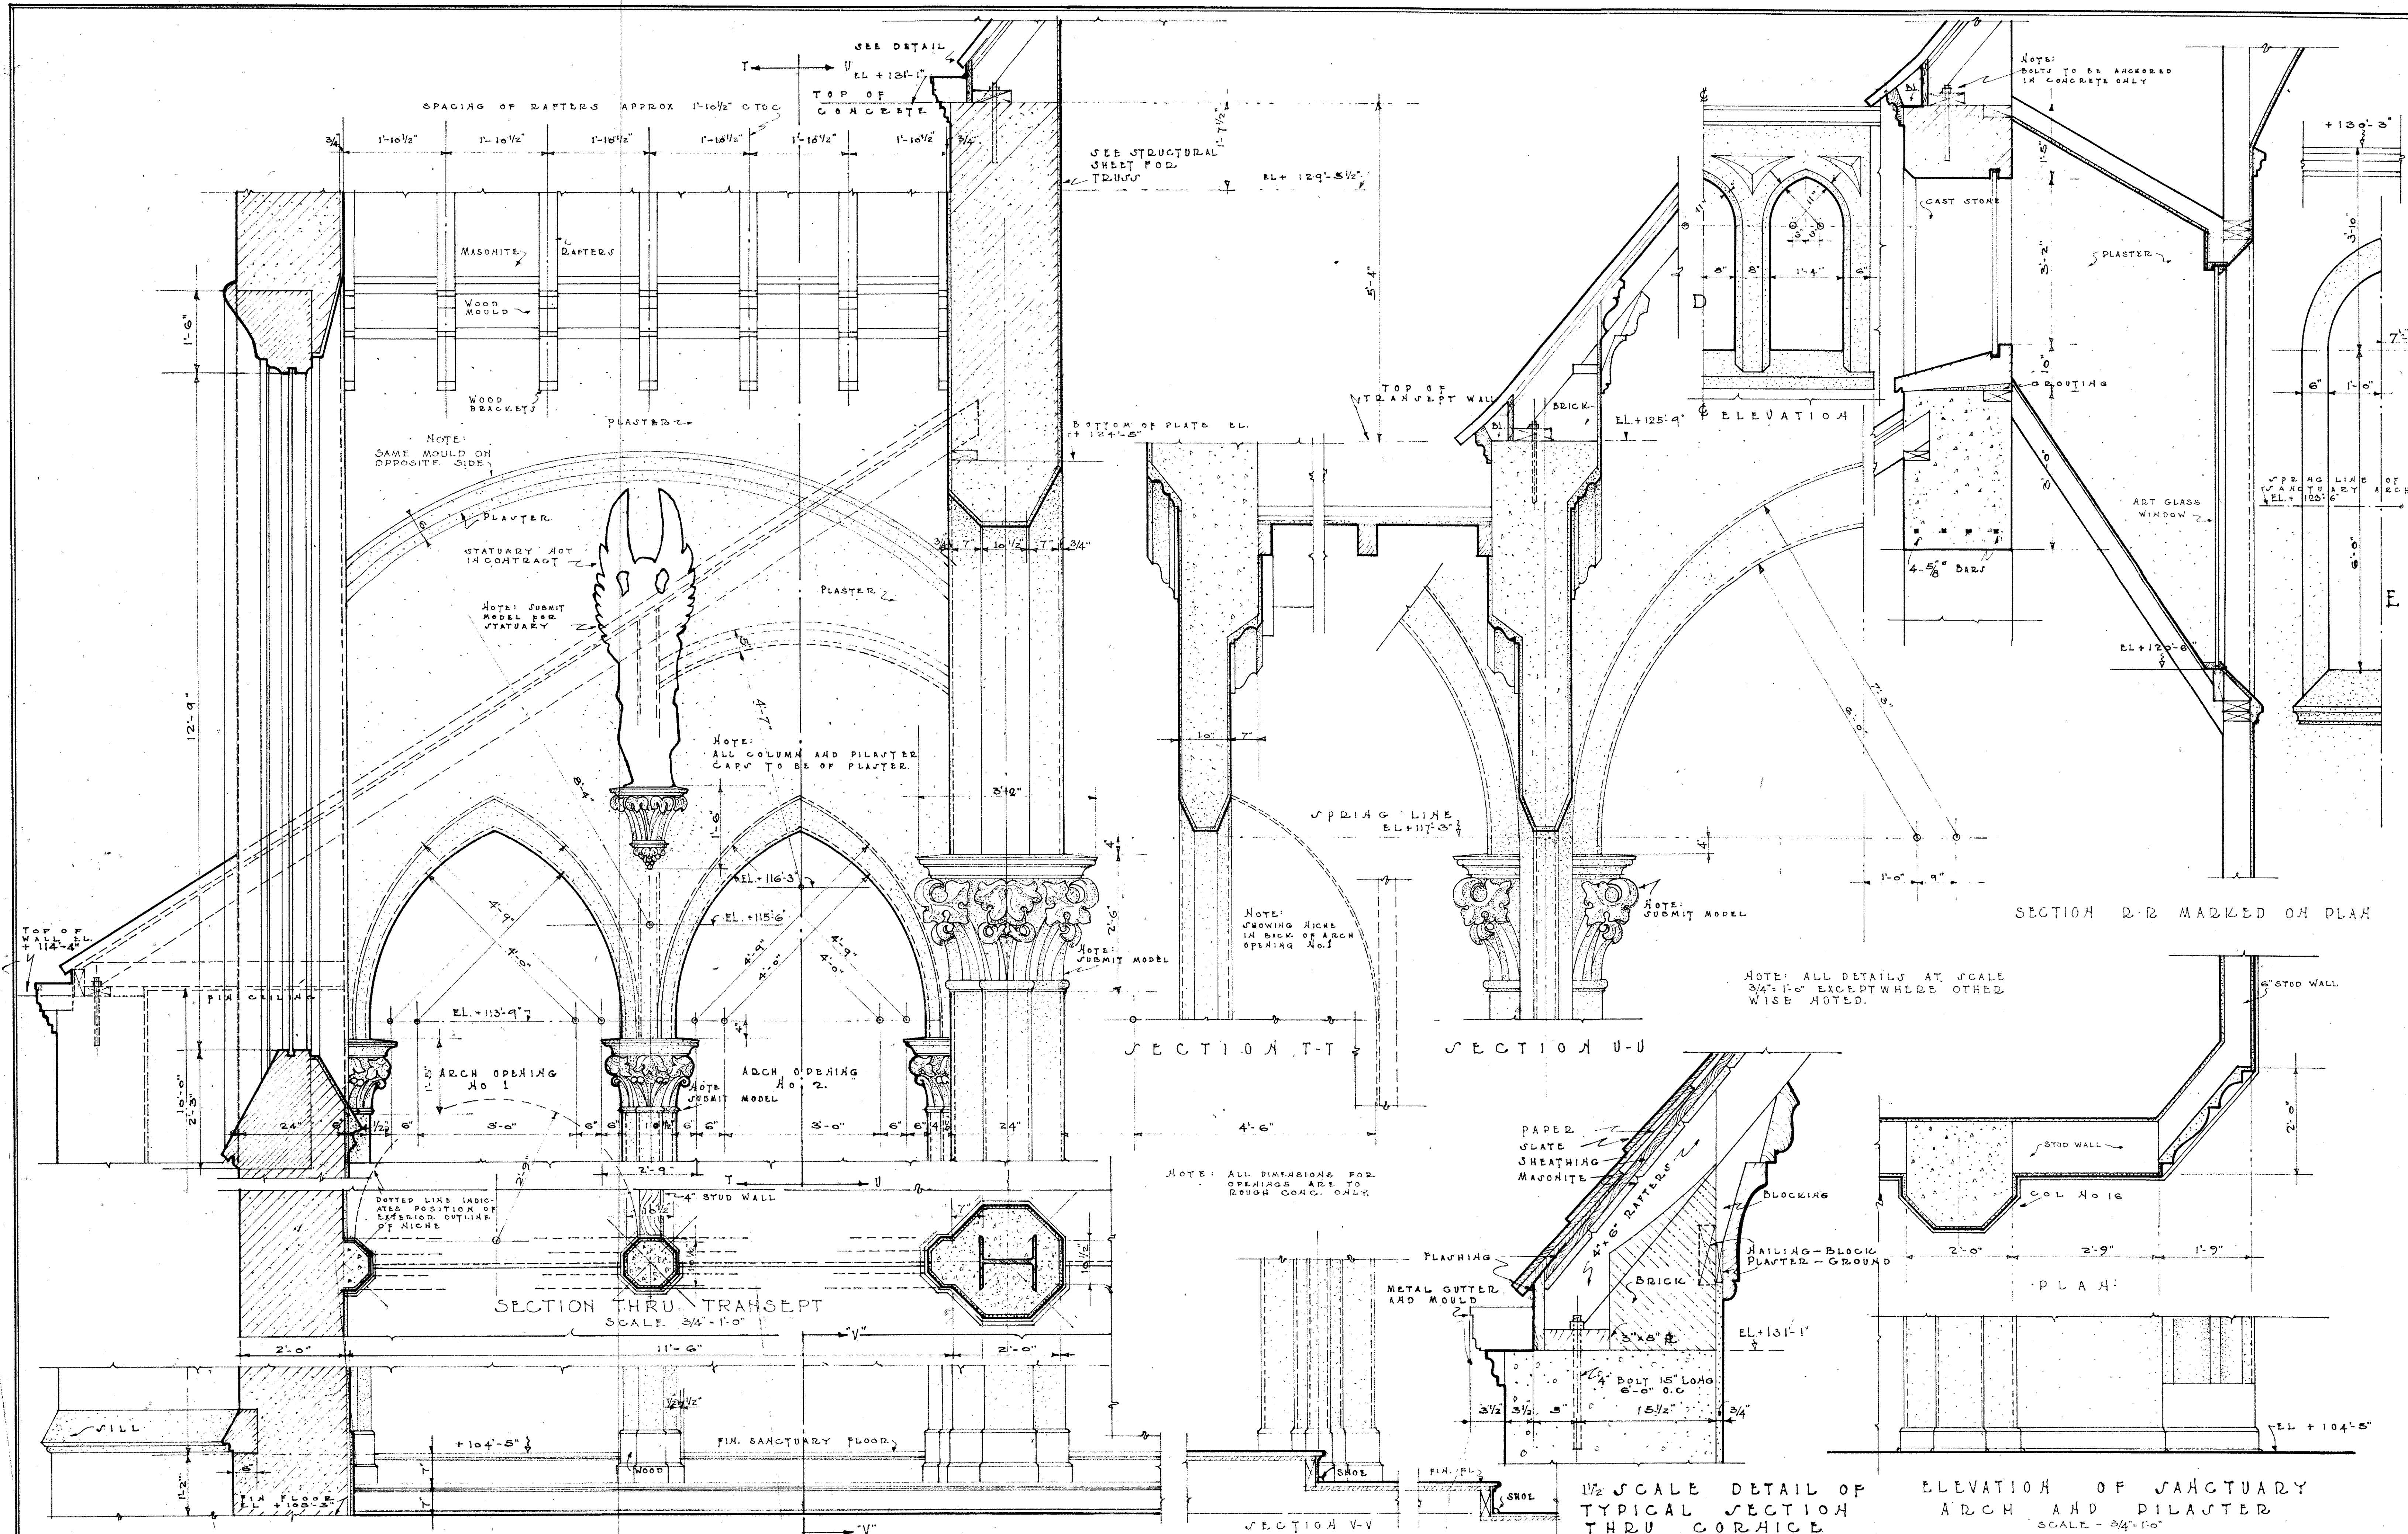

DATE
SEPT. 14,
OCT. 12,
1929

REV EDWARD ALBOUY
RECTOR

LOCATION
NORTH EAST CORNER
OF CHERRY STREET

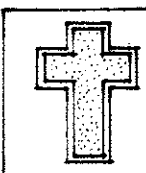



CHURCH OF THE ACTIVITIES
FLAGSTAFF ARIZONA
FOR THE REV BISHOP
OF THE DIOCESE OF TUCSON

COMM EMMET G. MARTIN
ARCHITECT

821 CHESTER WILLIAMS BLDG
LOS ANGELES CAL


SHEET
7

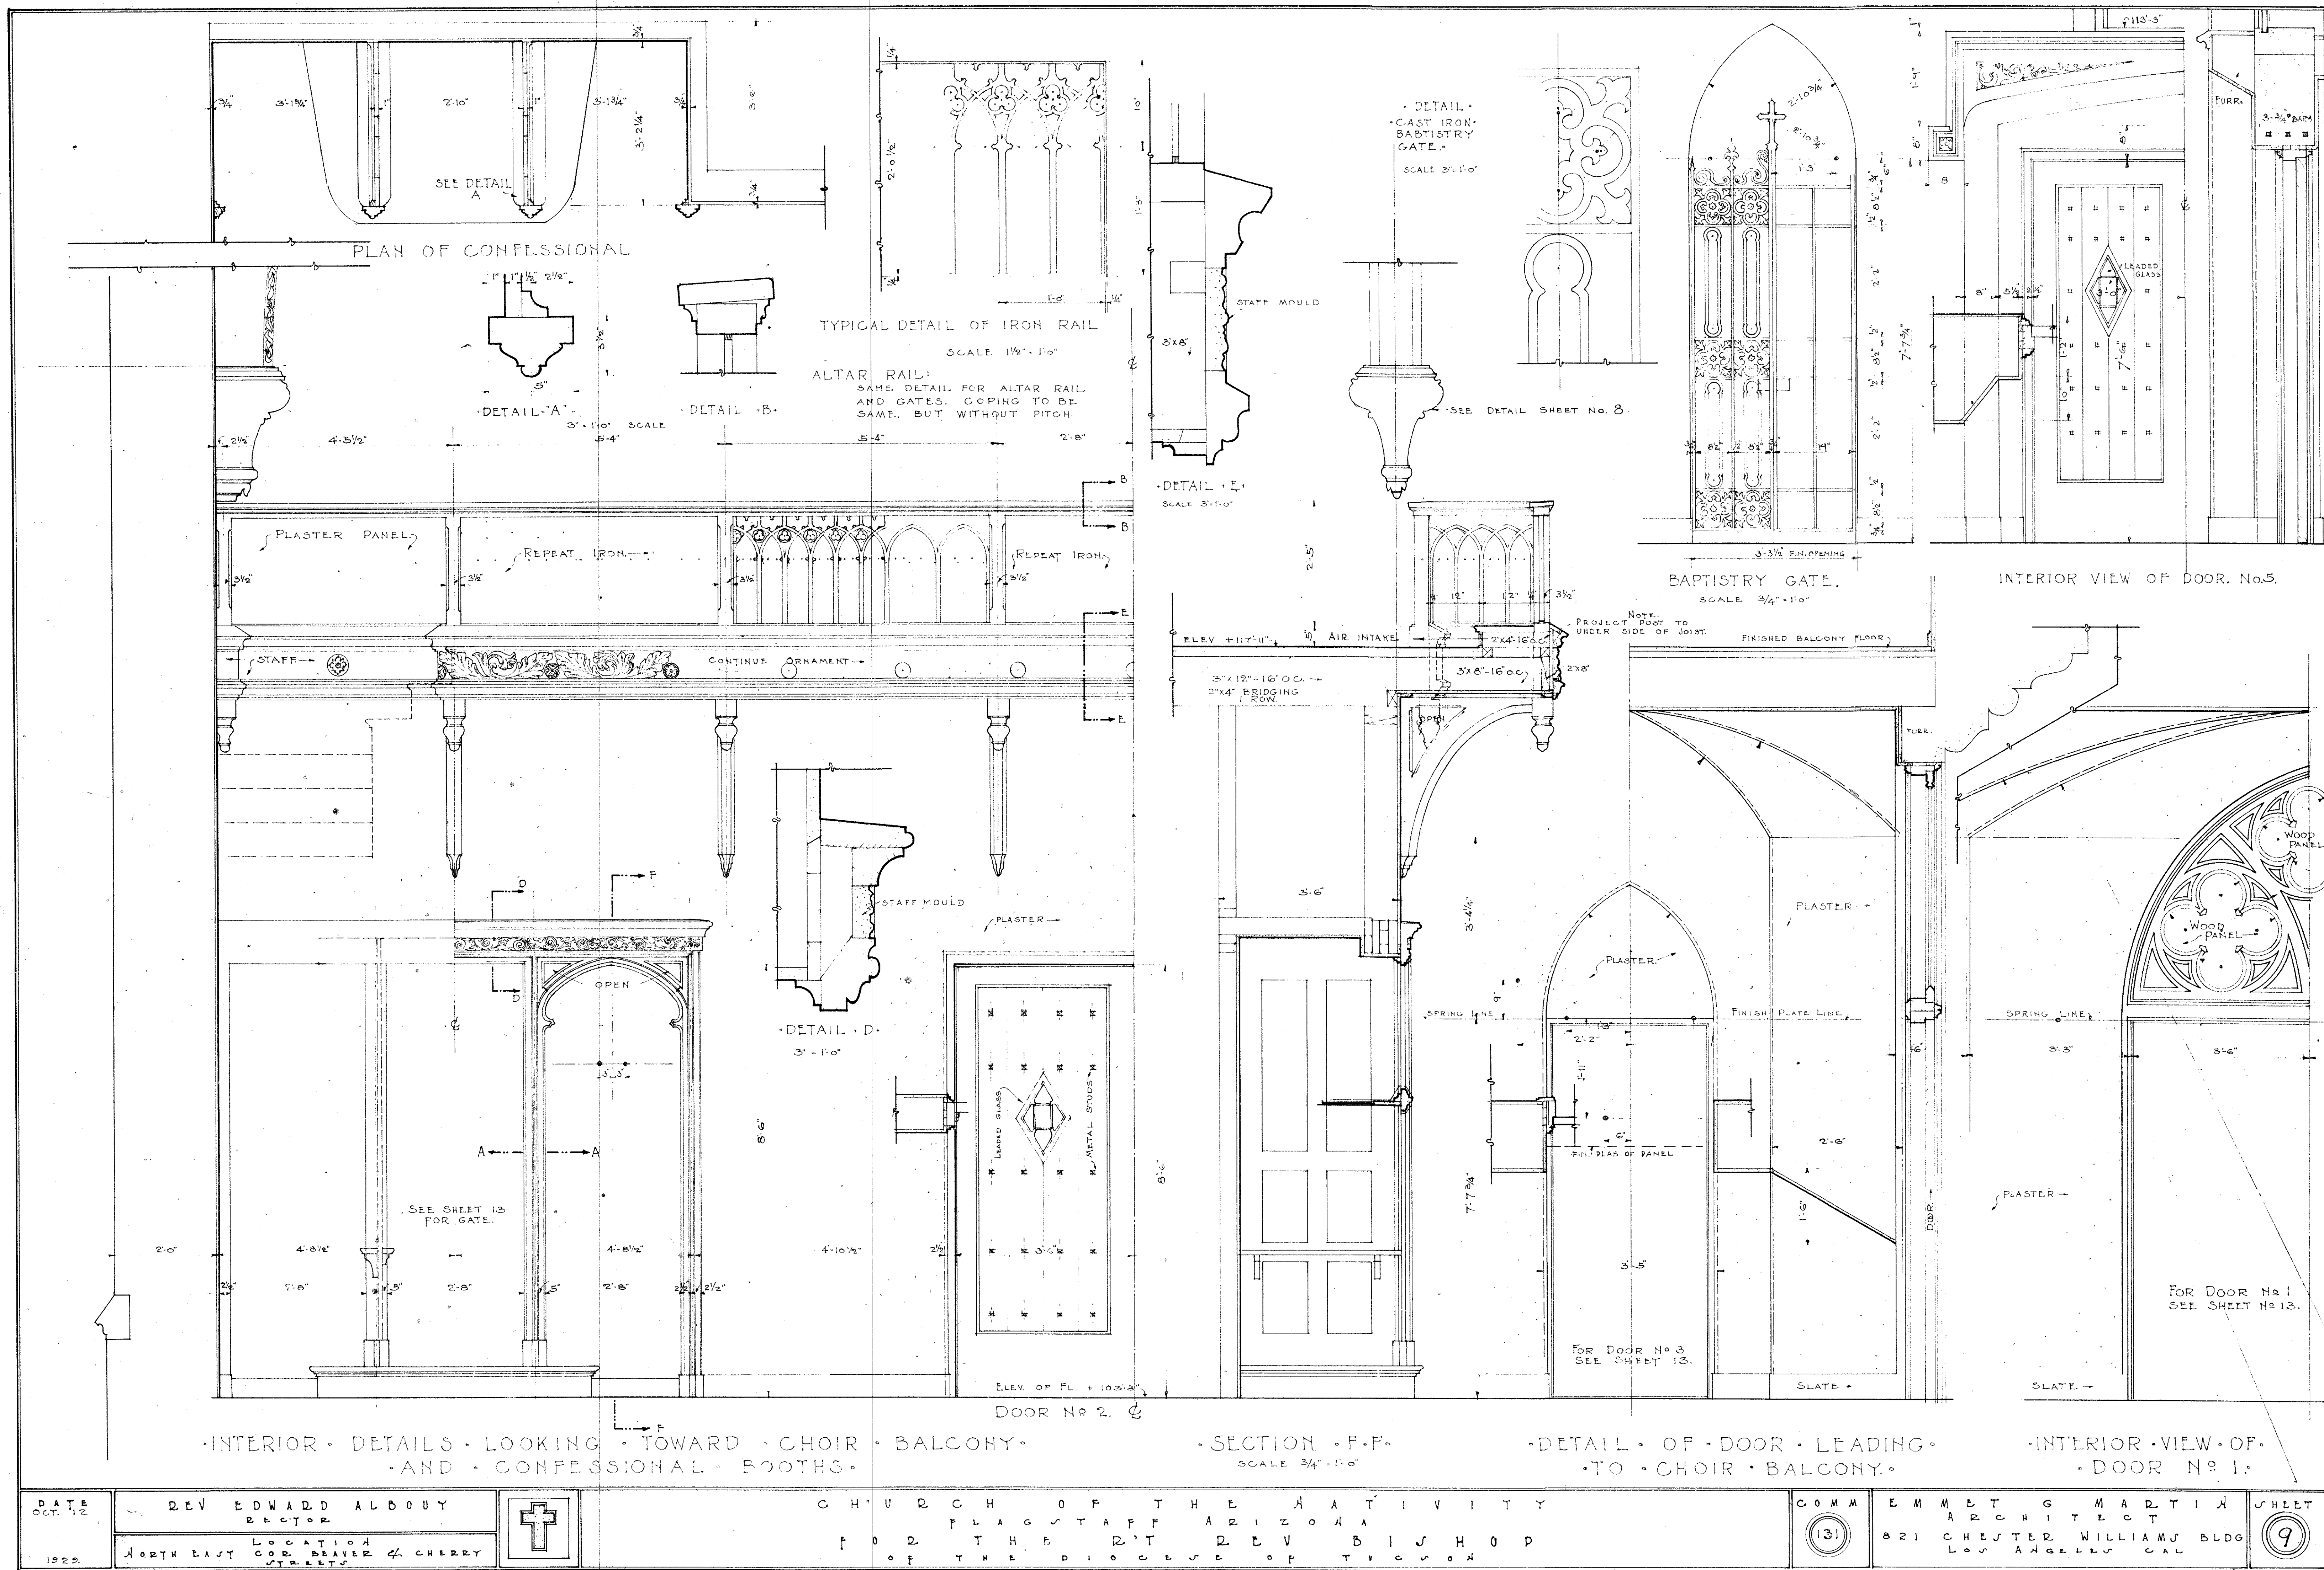

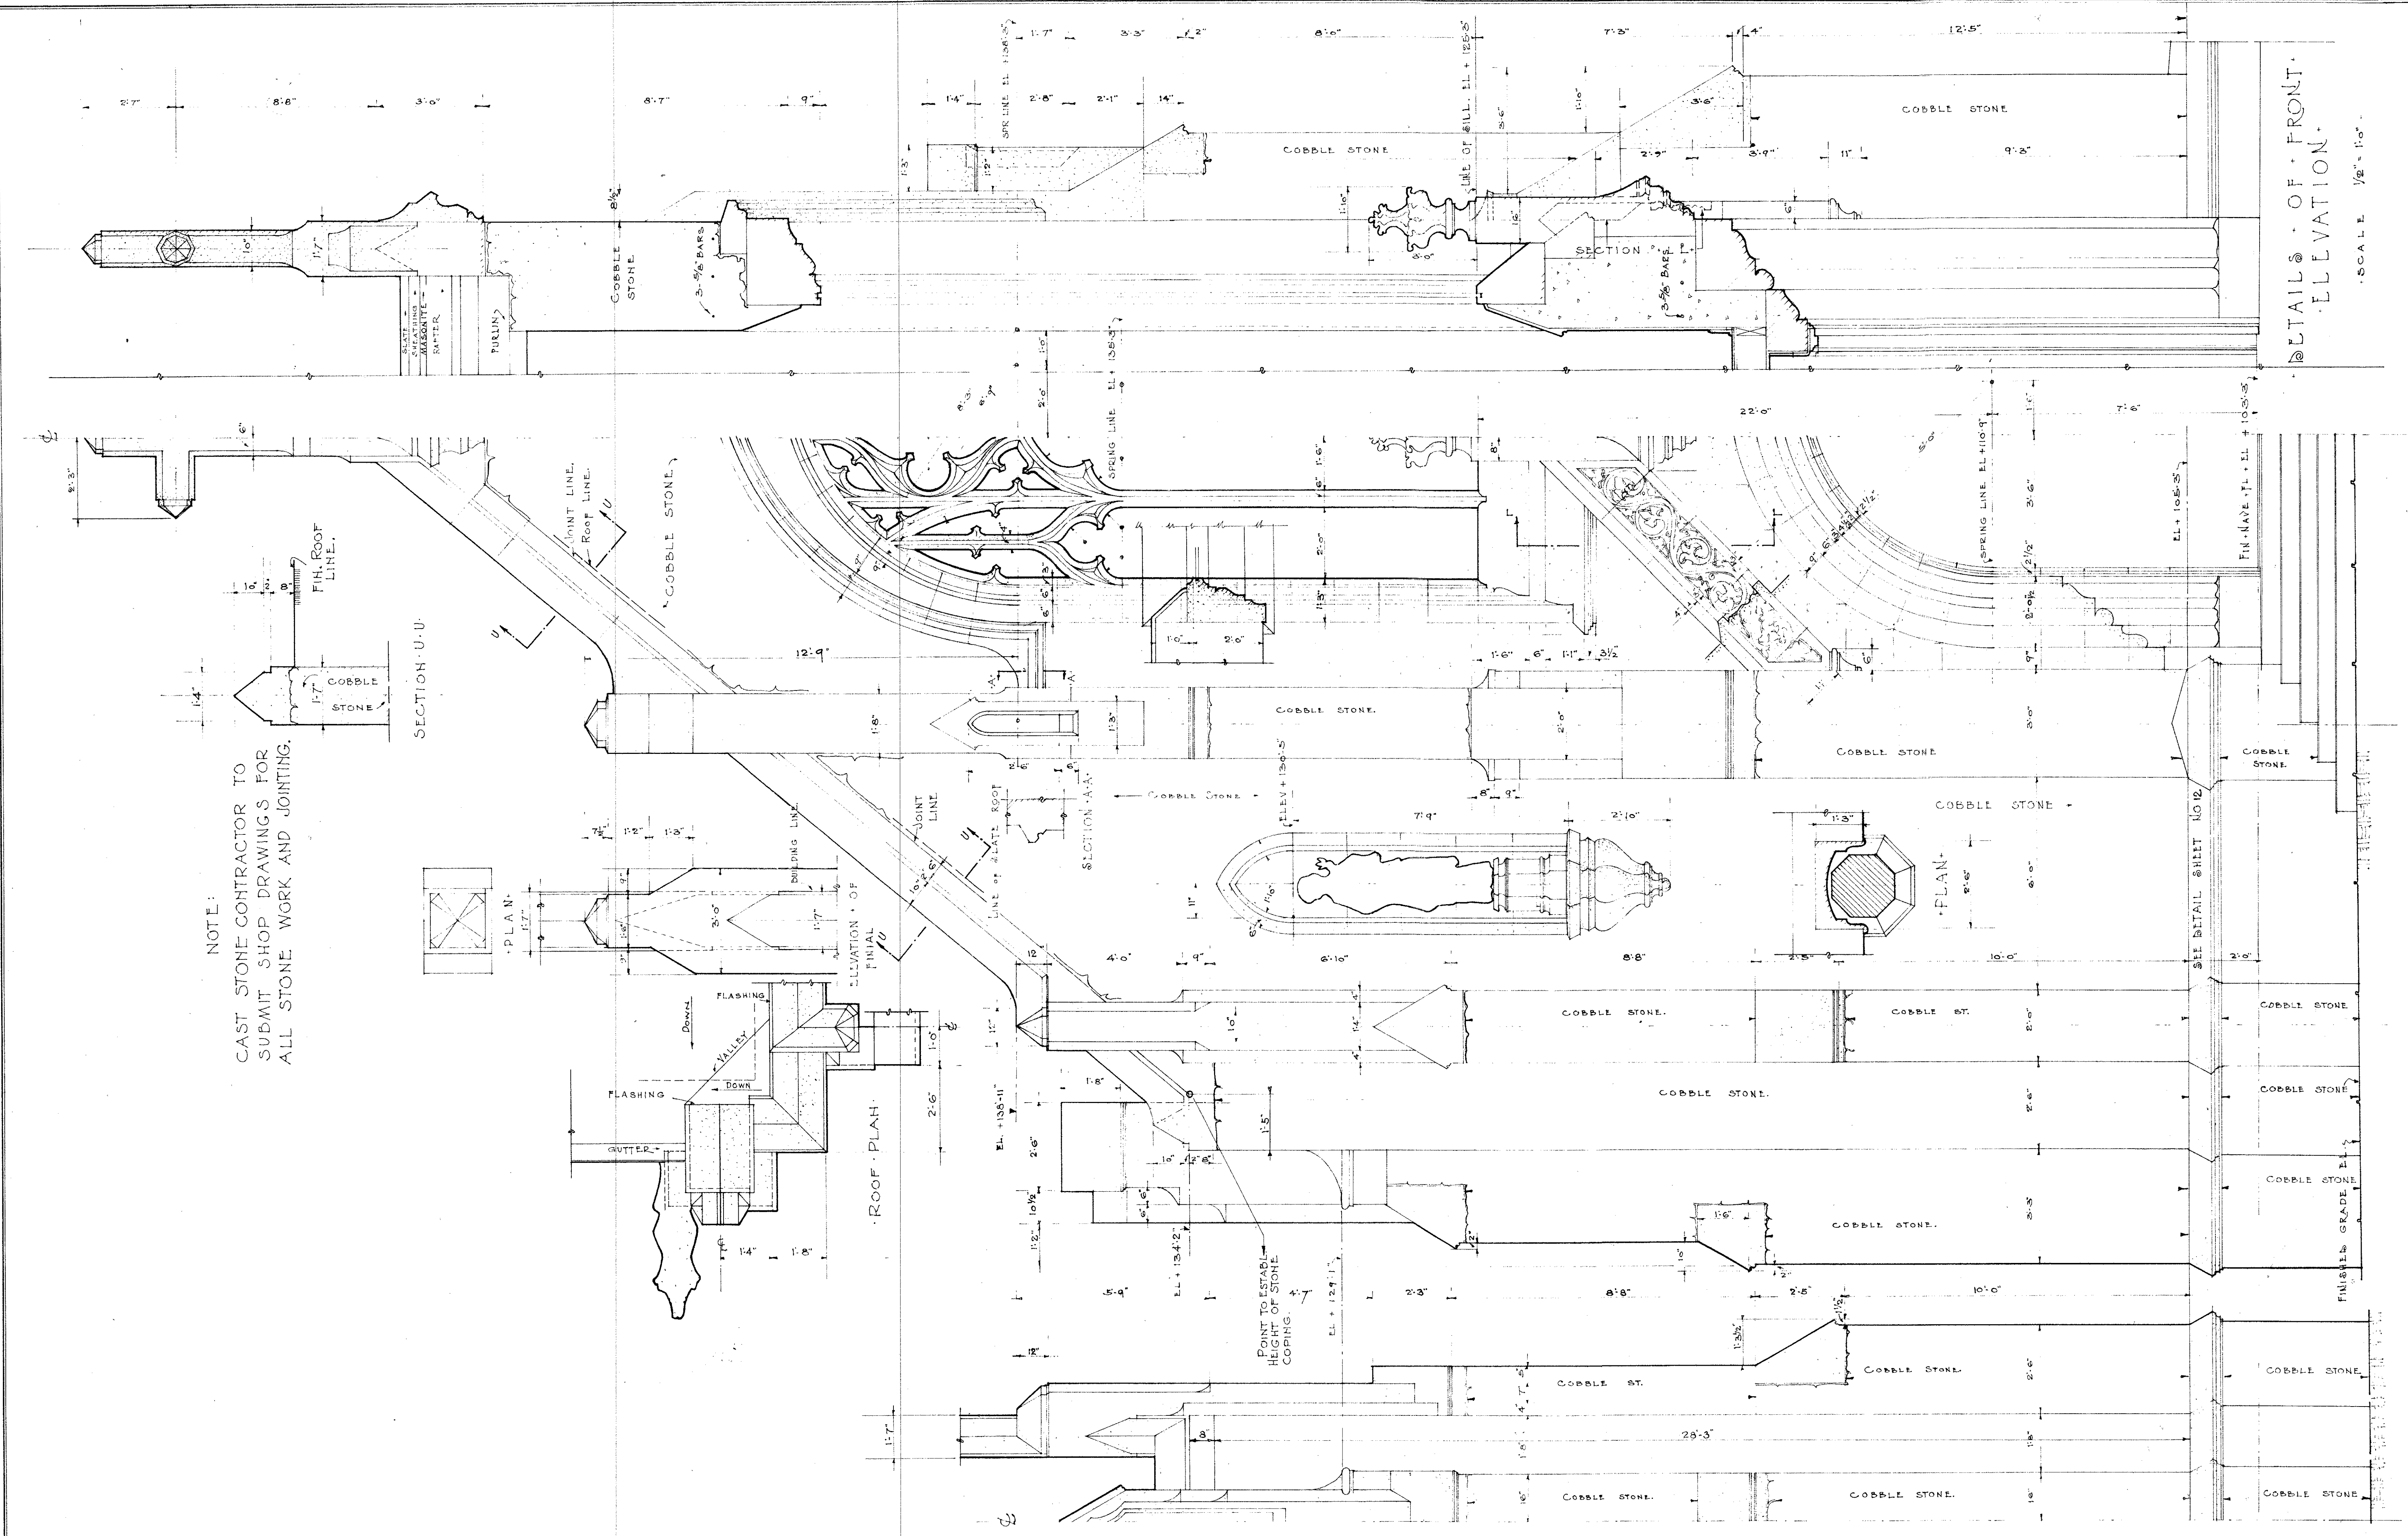

NOTE:
 CAST STONE CONTRACTOR TO
 SUBMIT SHOP DRAWINGS FOR
 ALL STONE WORK AND JOINTING.

DETAILS OF FRONT
 ELEVATION.
 SCALE 1/2" = 1'-0"

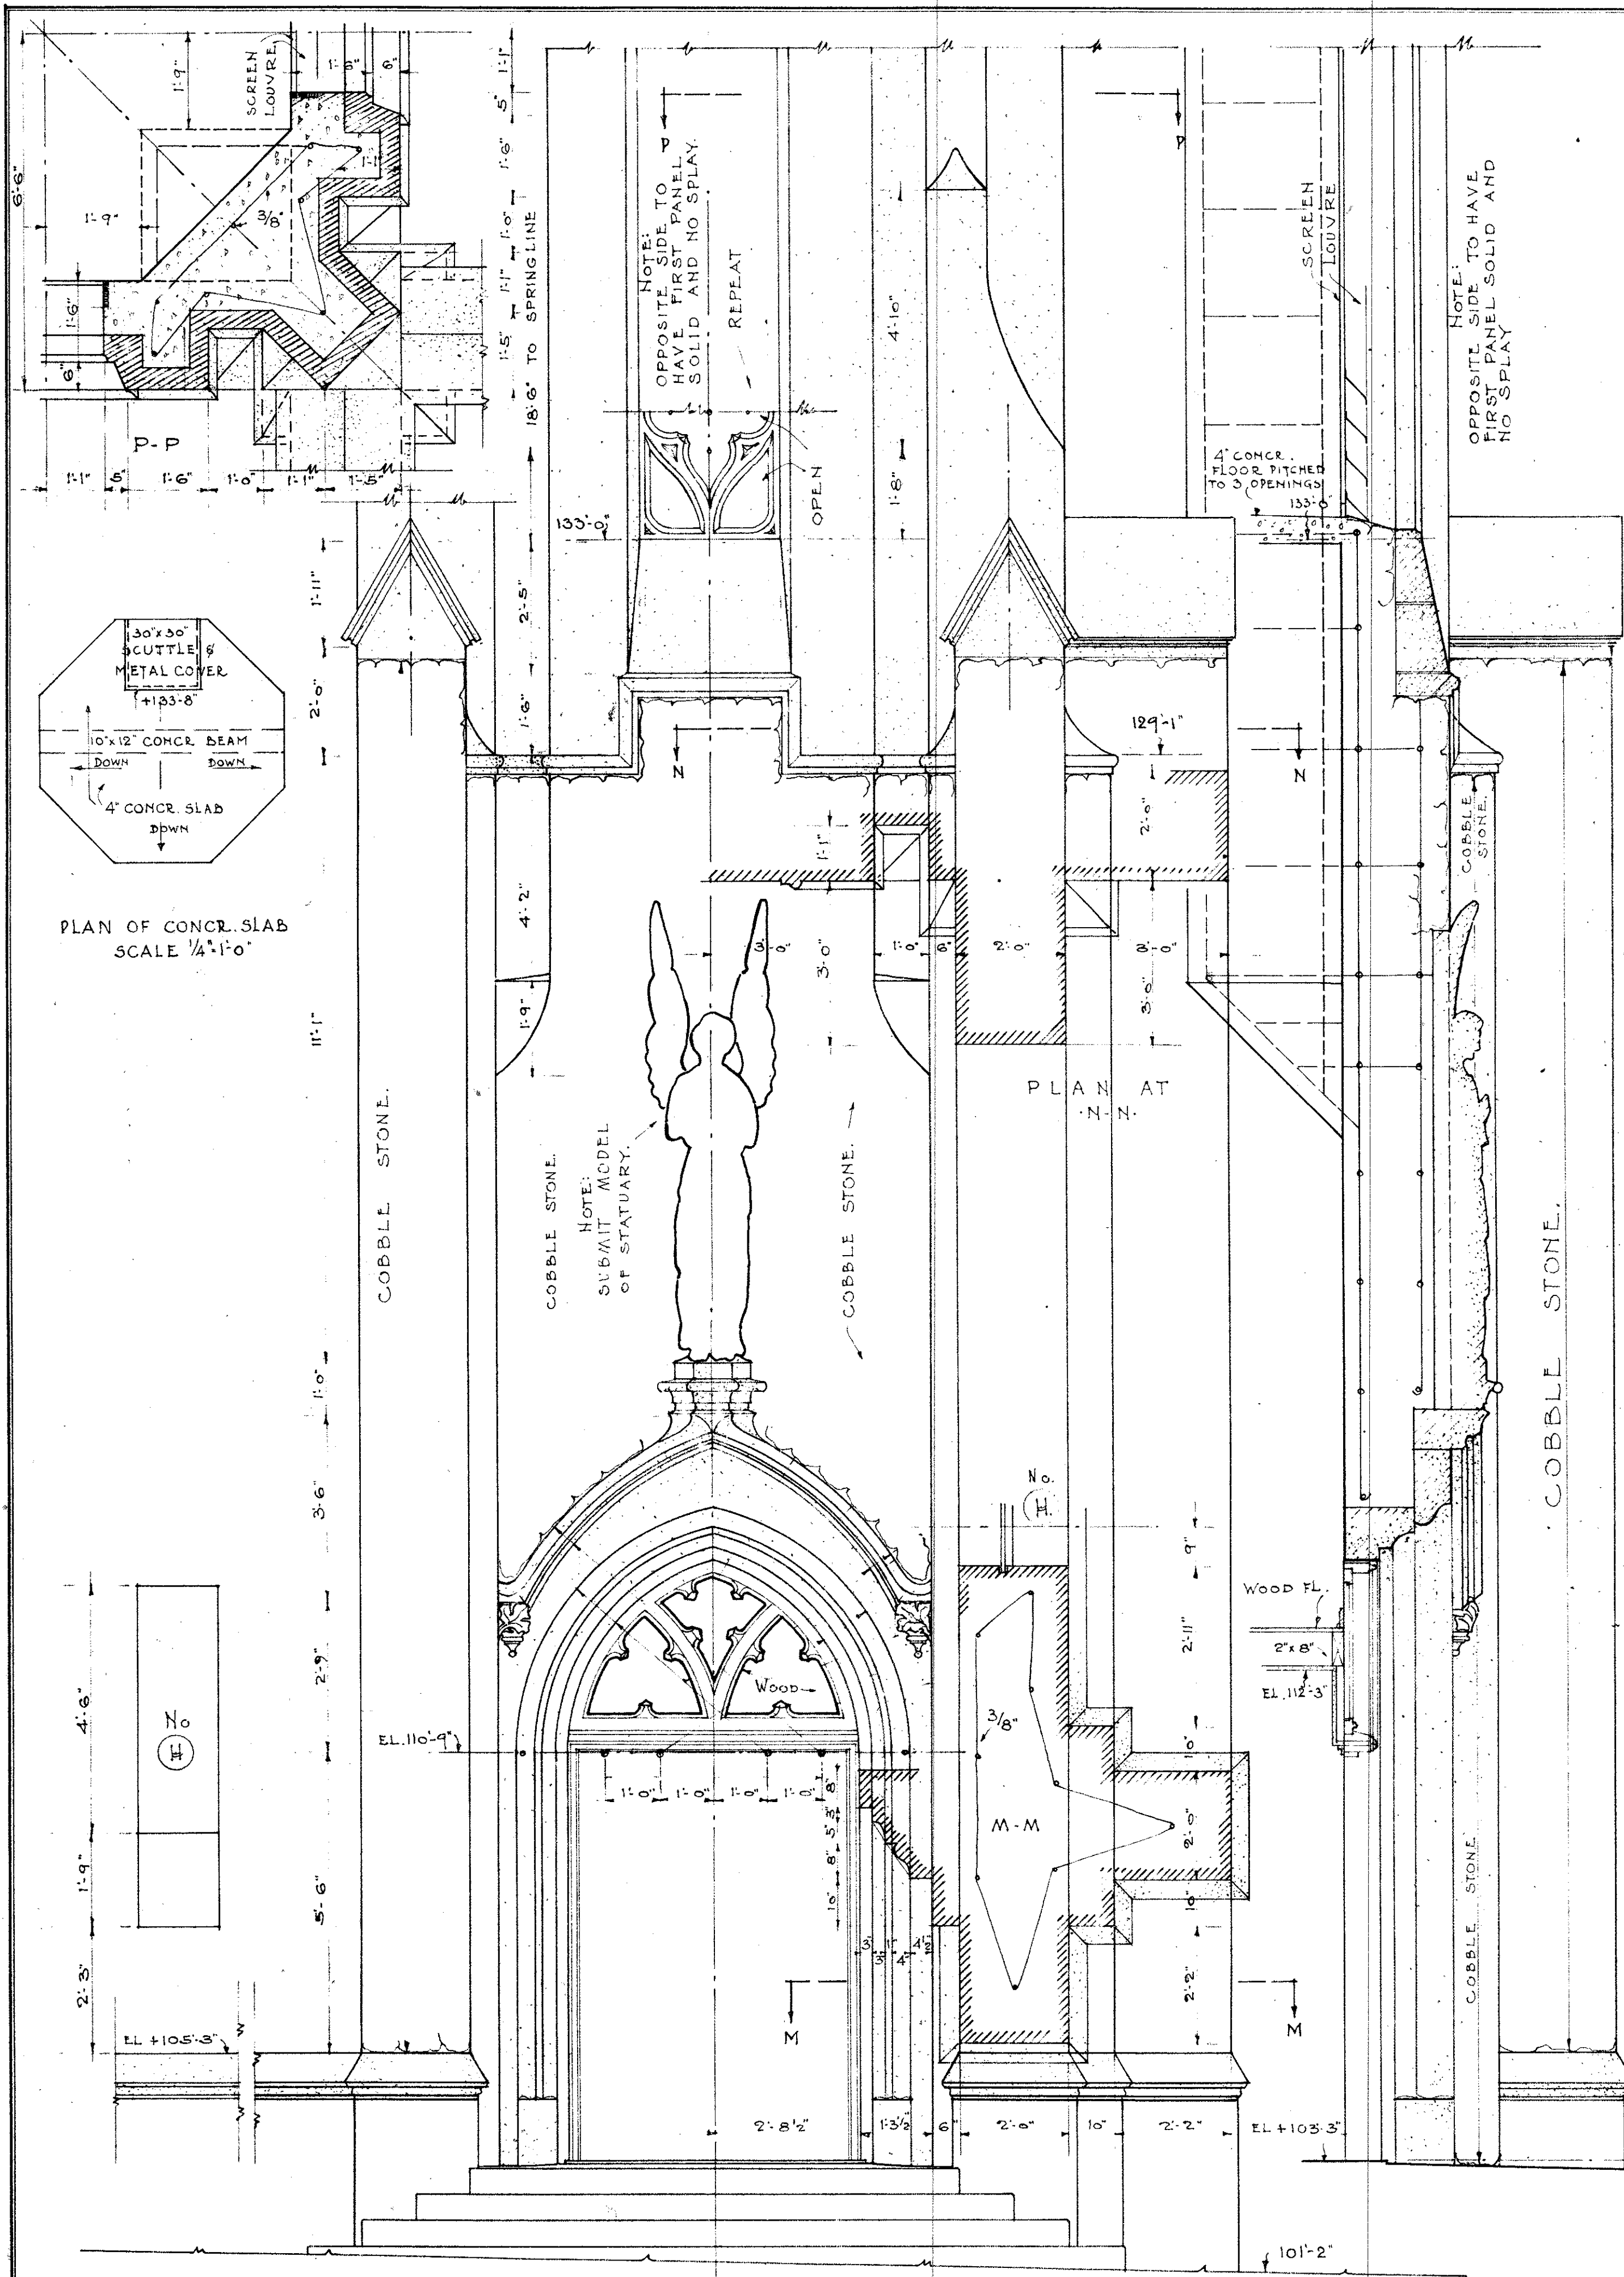

NOTE:
CAST STONE CONTRACTOR TO
SUBMIT SHOP DRAWINGS FOR
ALL STONE WORK AND JOINTING.



PLAN AT S-S


PLAN AT R-R

NOTE:
TOWER REINFORCEMENT
1/4" AND 3/8" BARS 24" O.C.
BOTH WAYS AND INSIDE
AND OUTSIDE AS SHOWN.


DETAILS
OF
TOWER

SCALE 1/2"=1'-0"

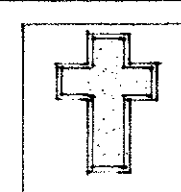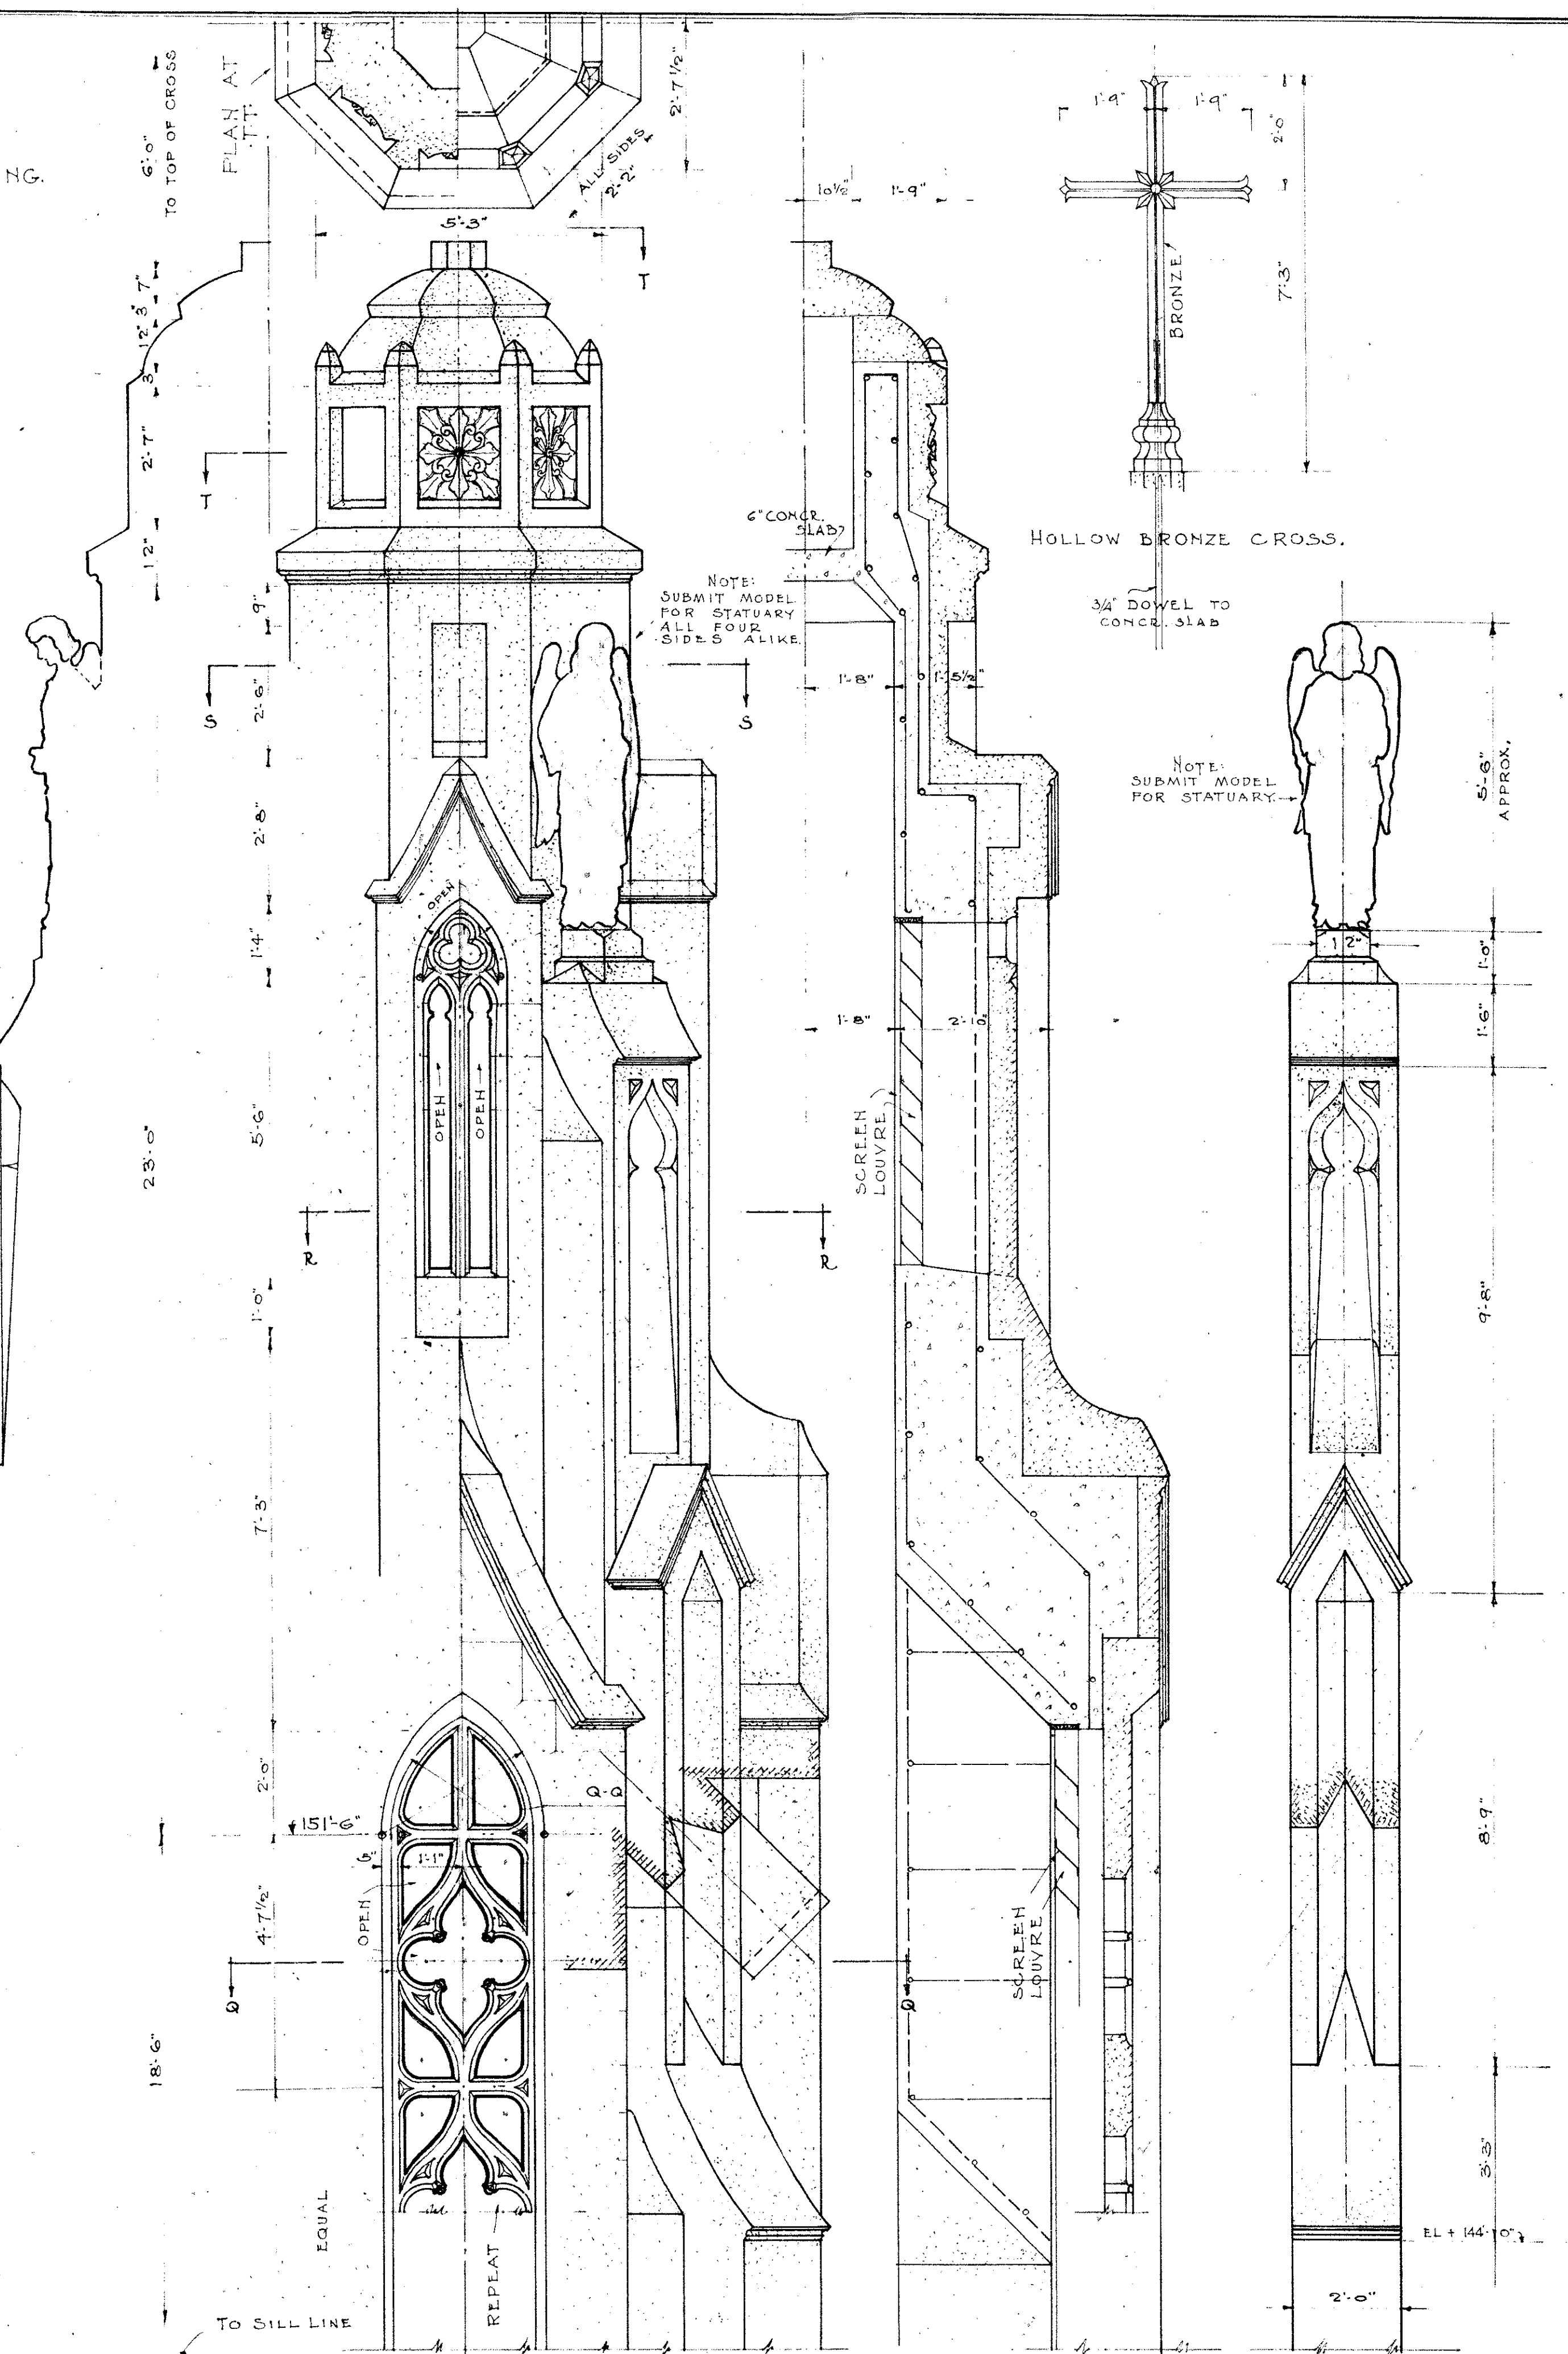


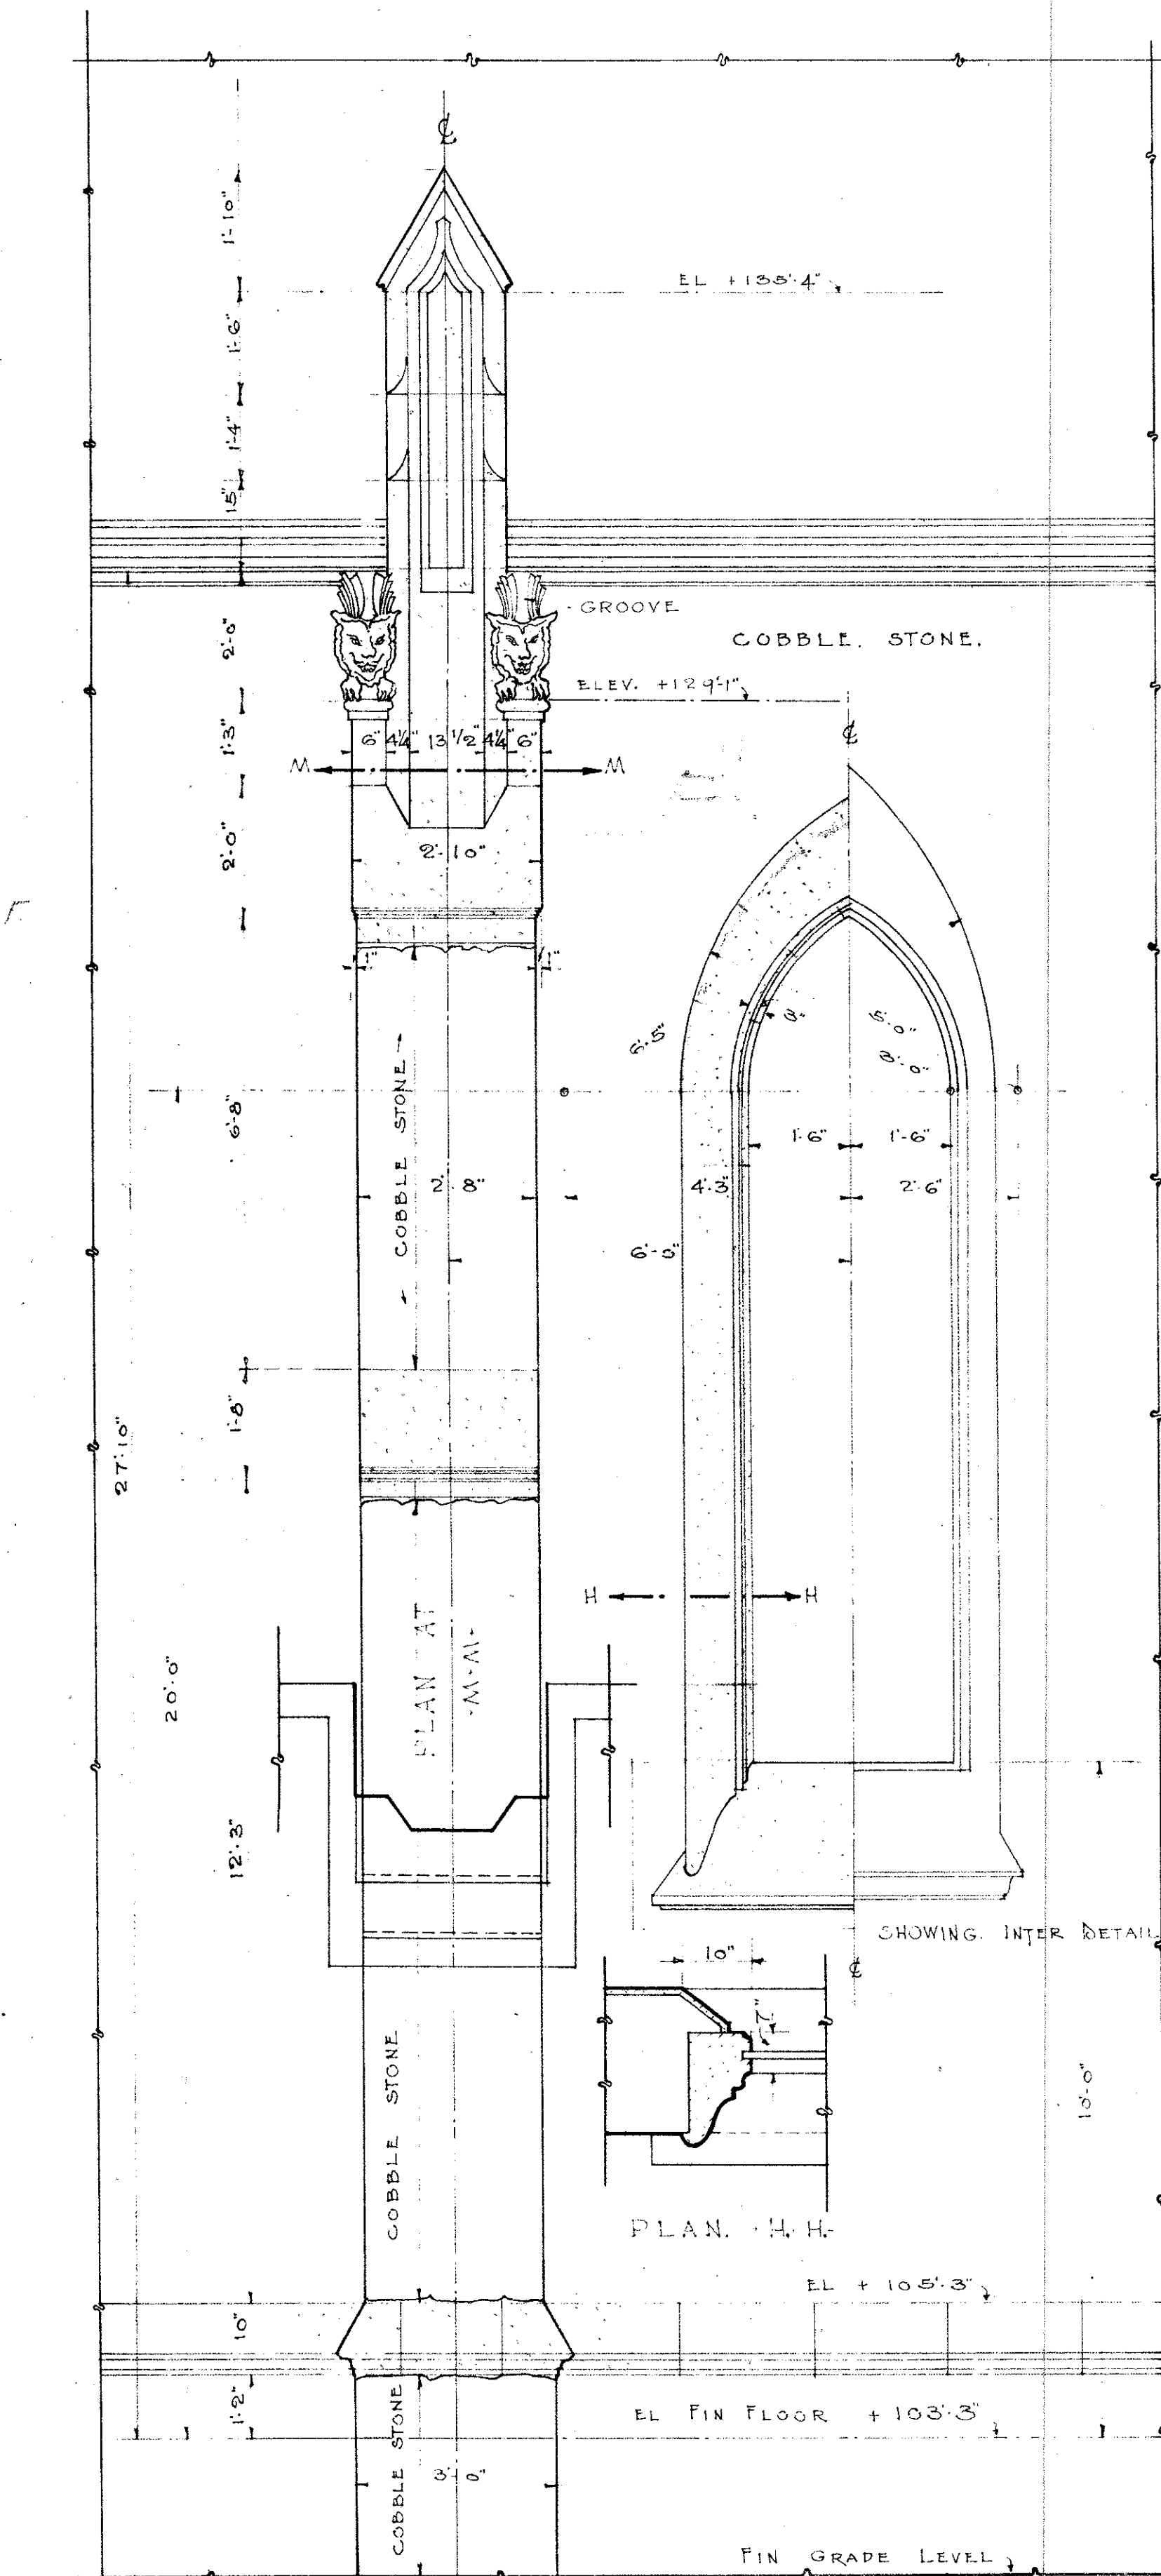





DETAIL OF EXTERIOR WALL
BUTTRESS AND WINDOW
SCALE 1/2" = 1'-0"

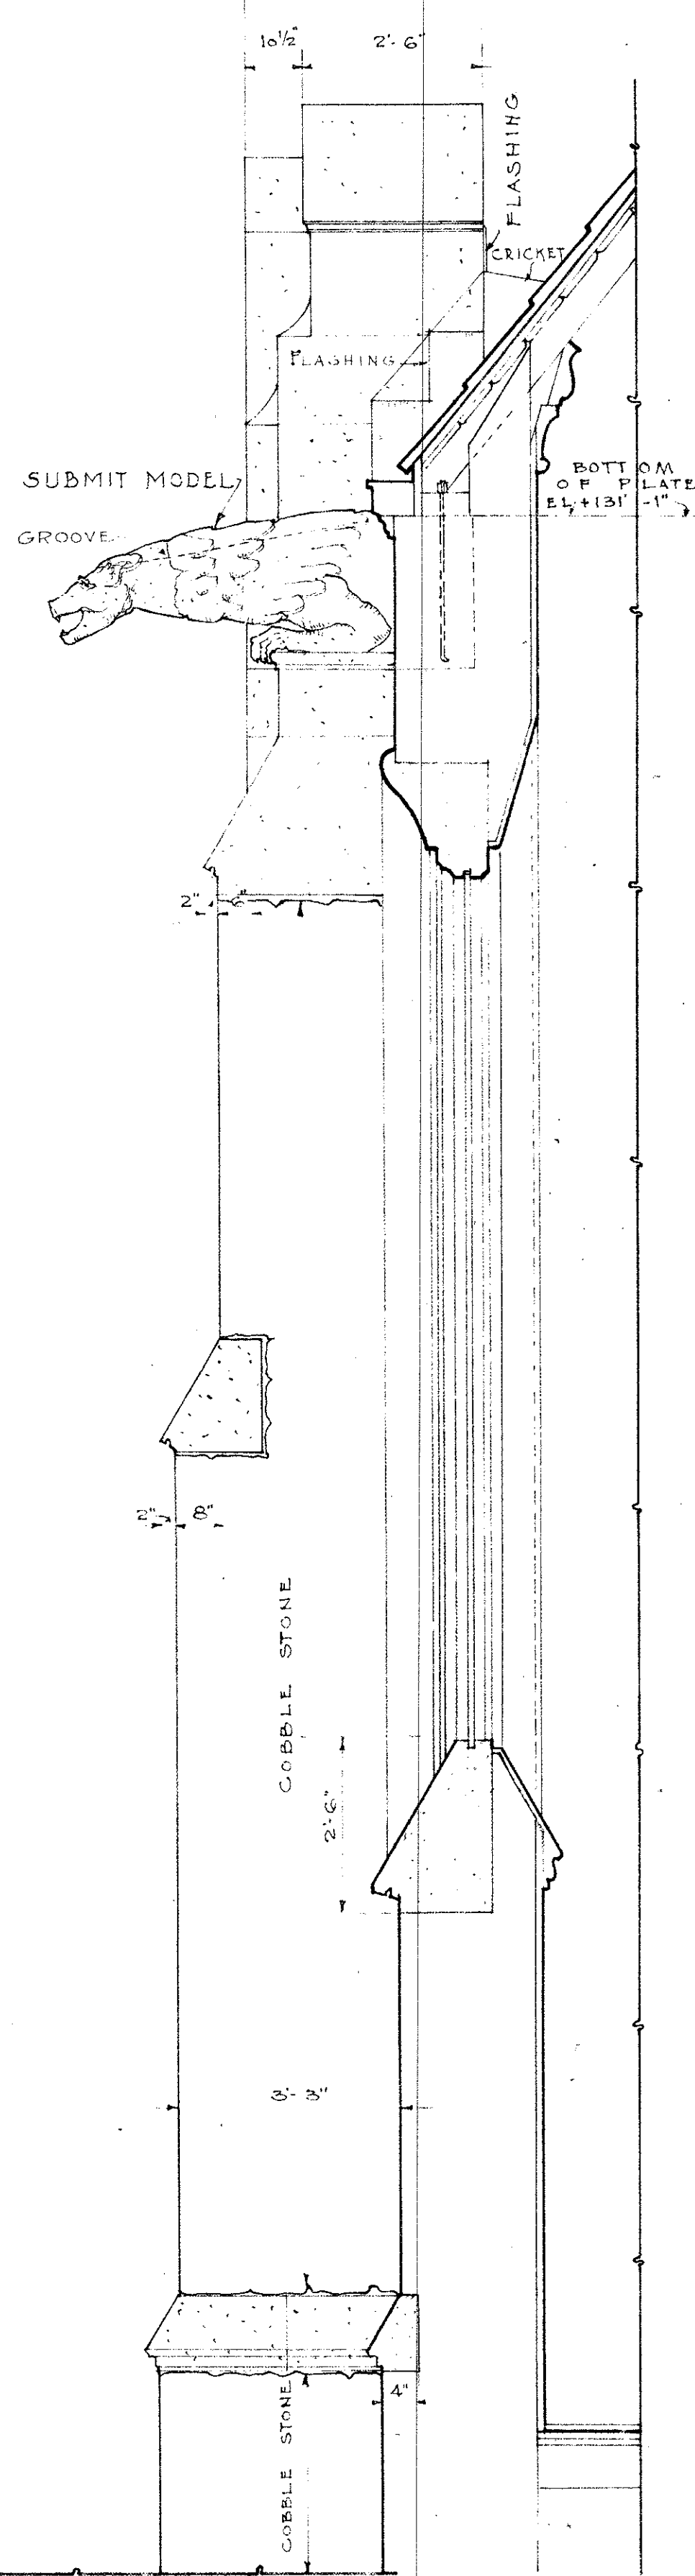



SECTION

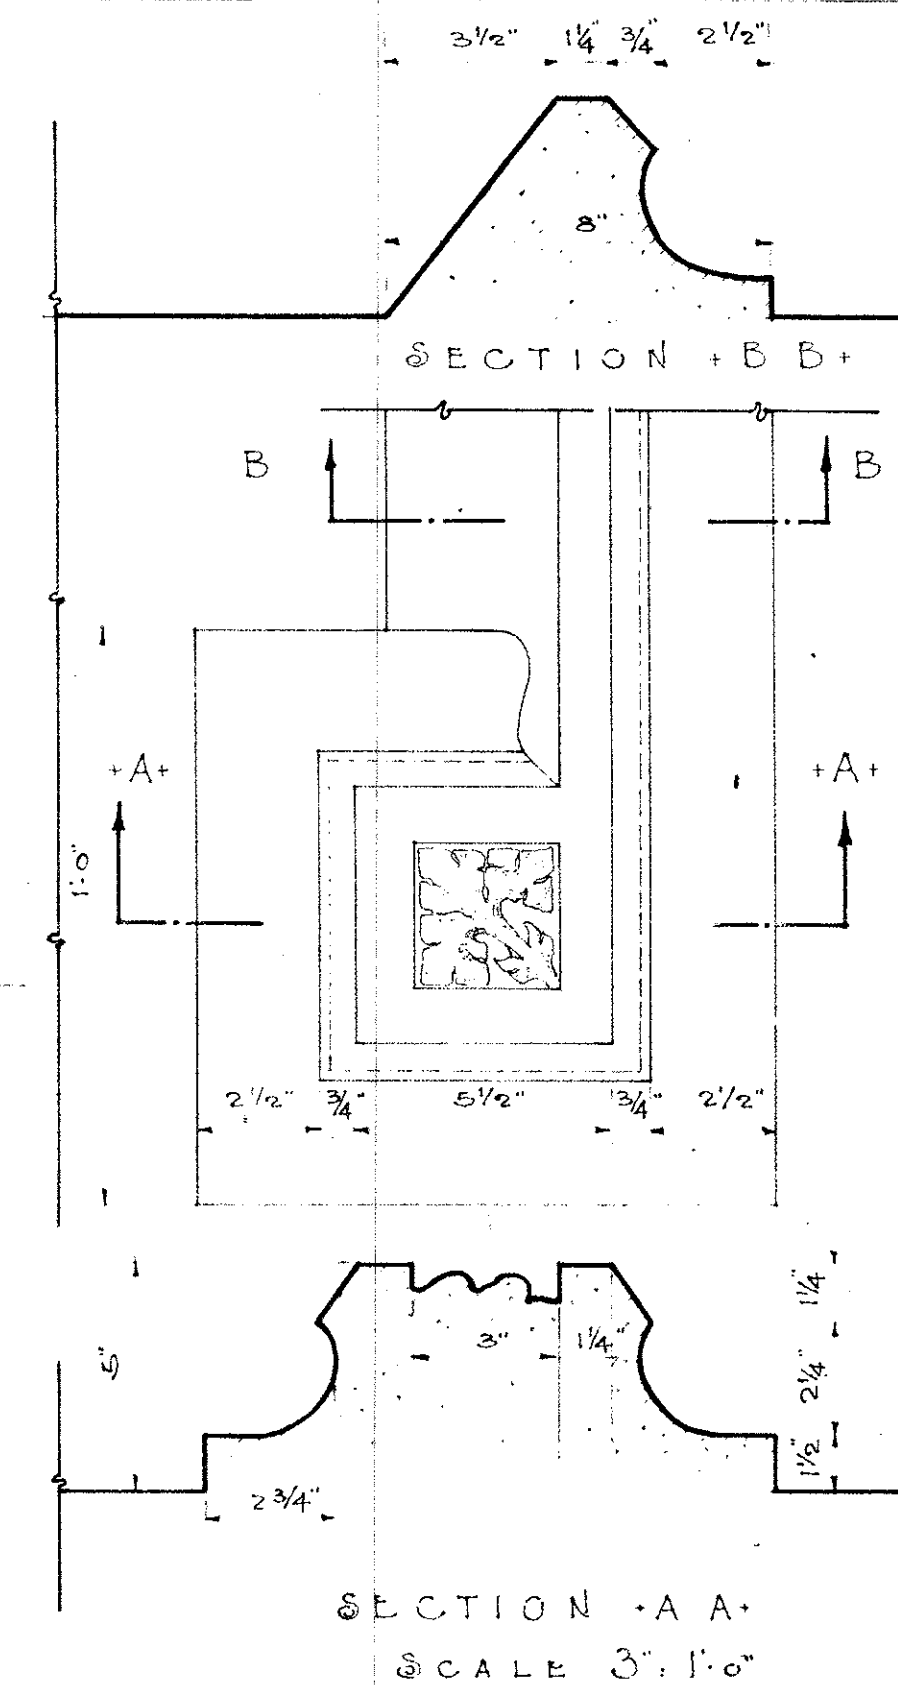


ELEVATION OF DOOR
TO SACRISTY
VESTIBULE

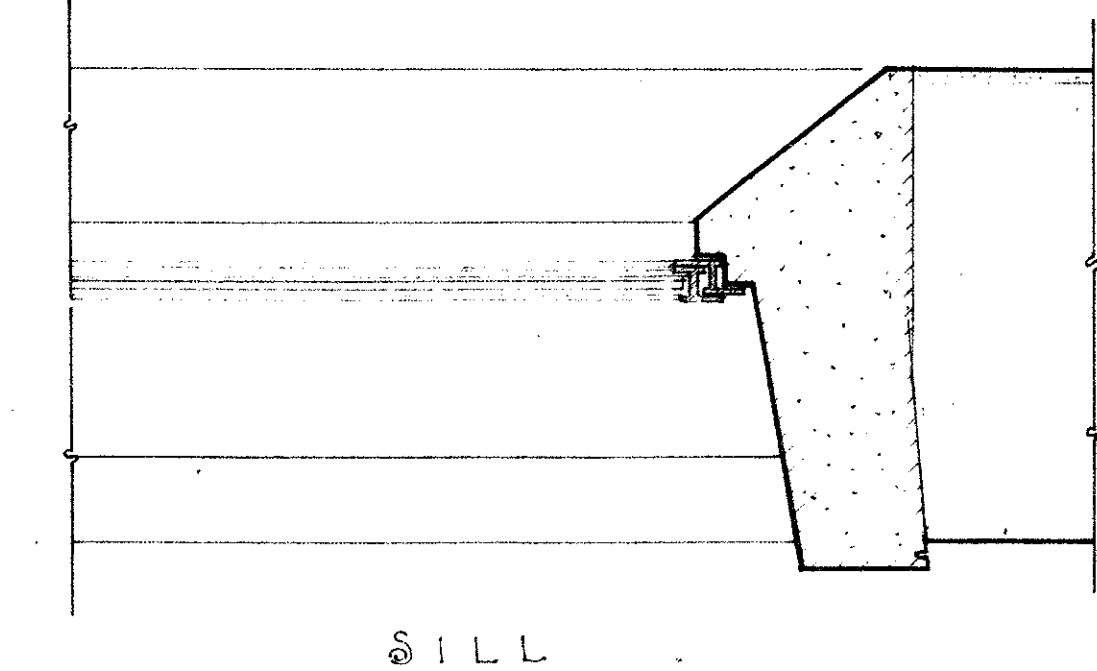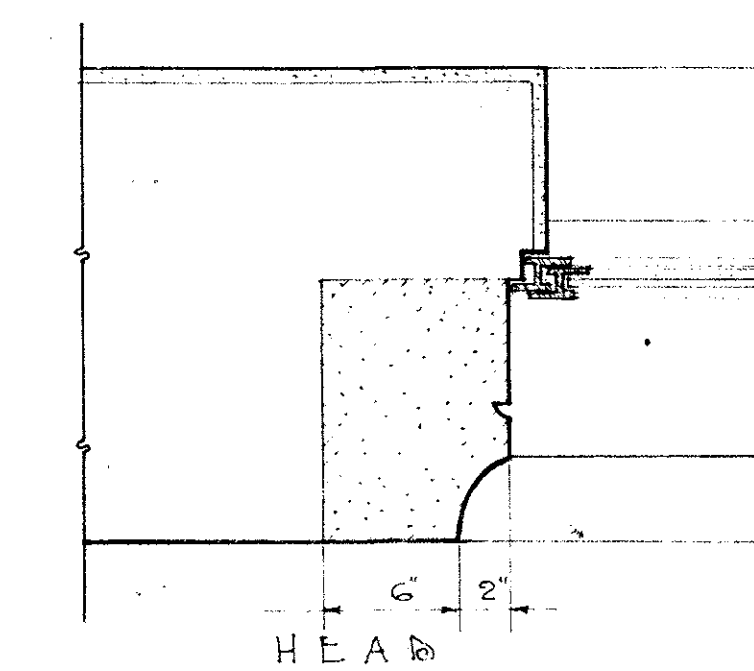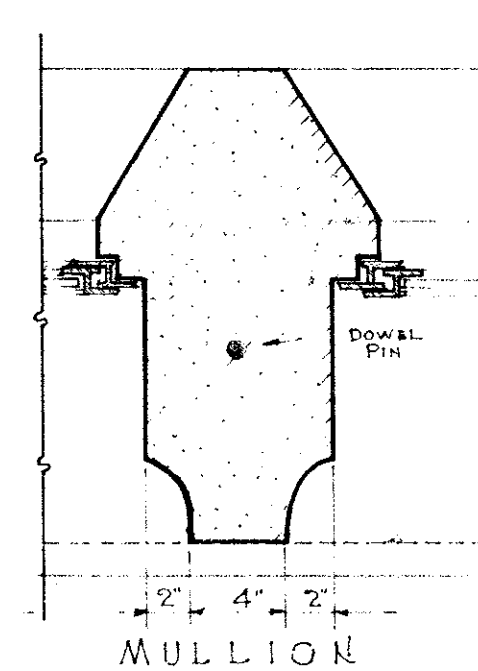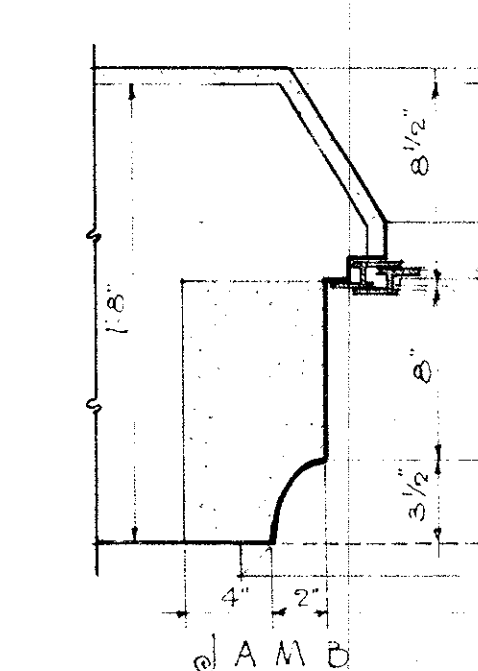

SECTIONS OF TYPICAL CASEMENT WINDOWS
SCALE 1 1/2" = 1'-0"

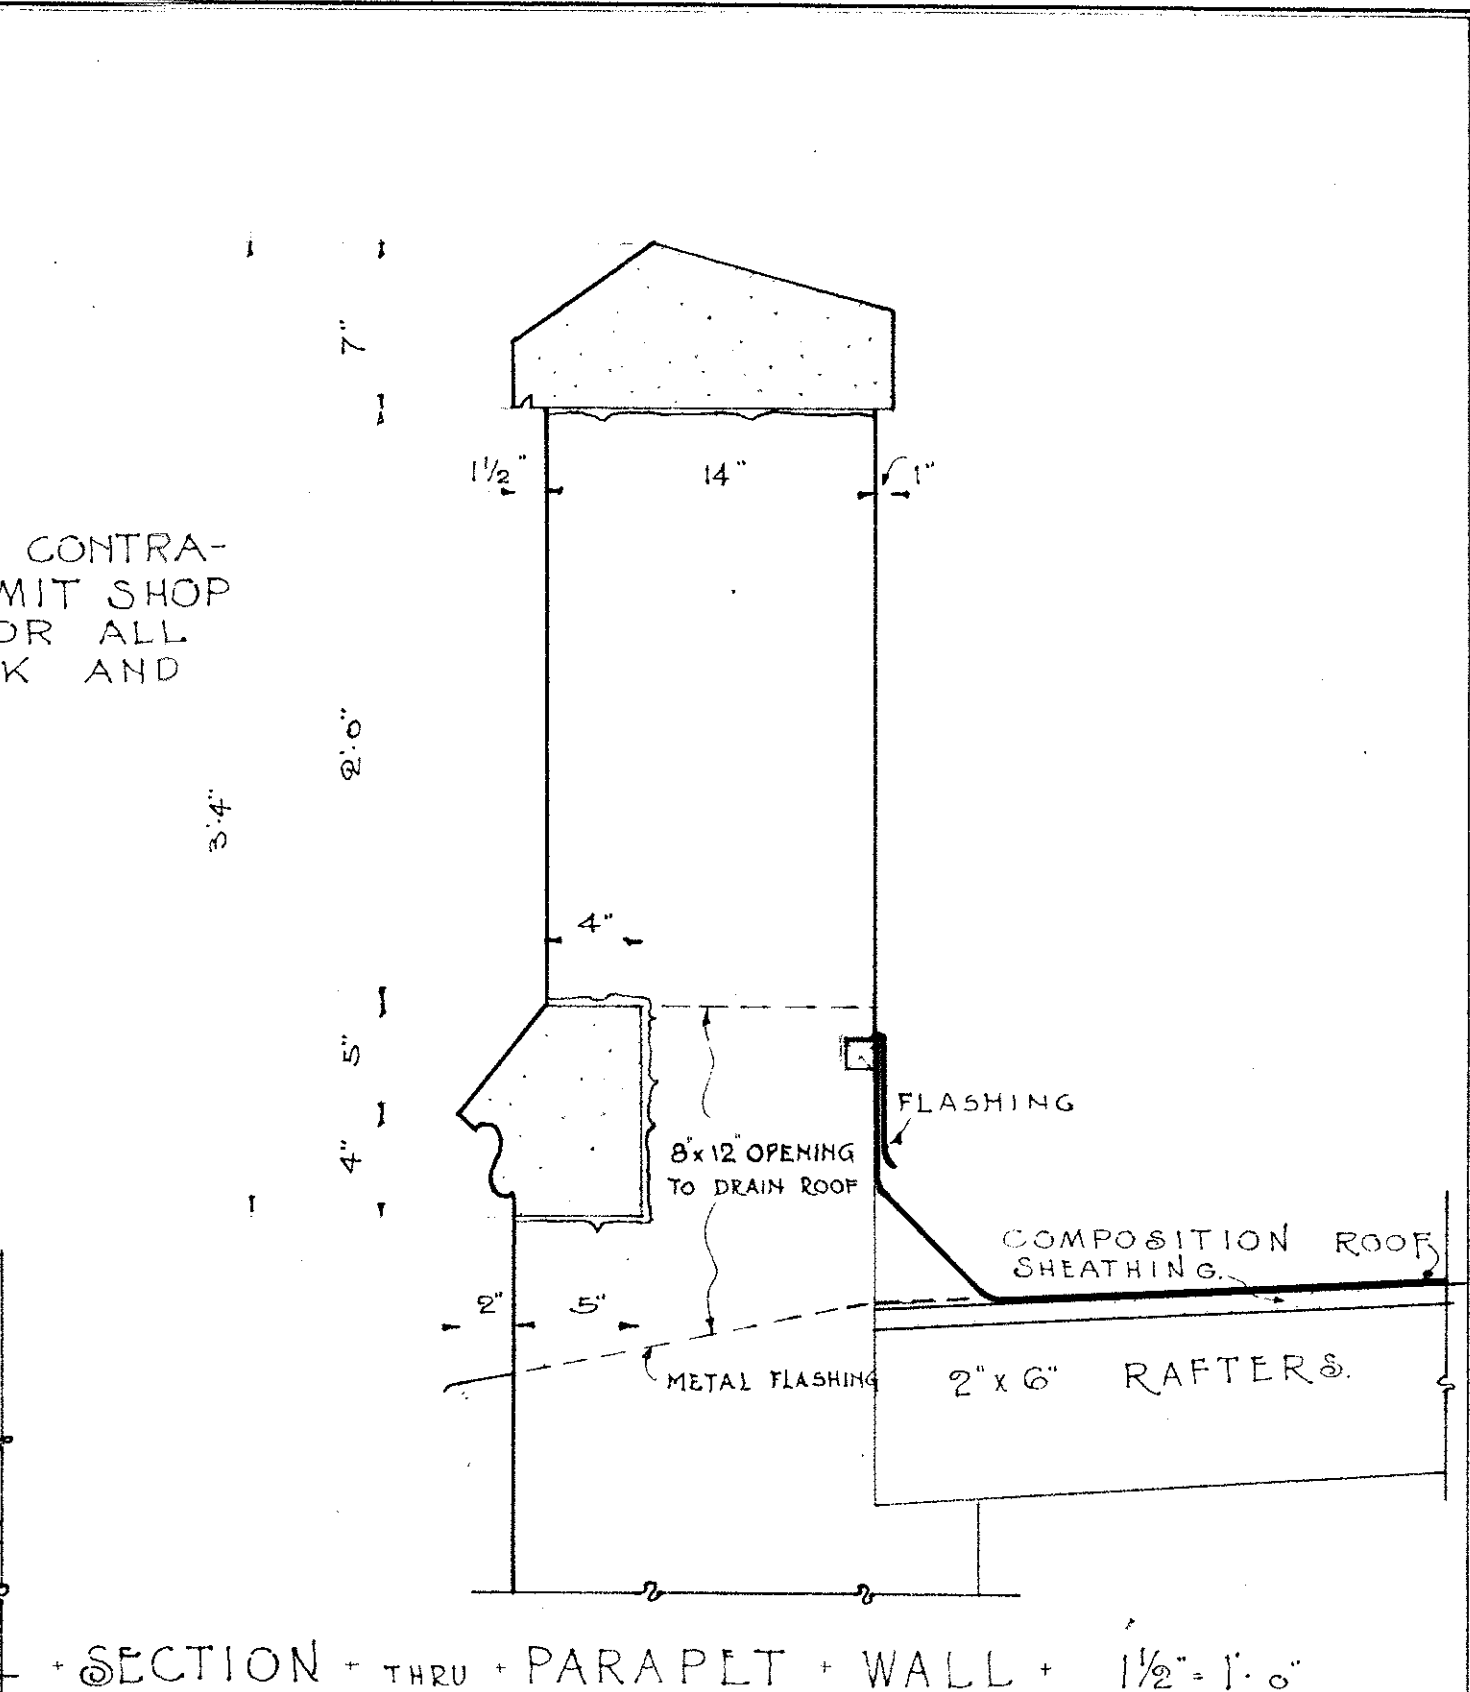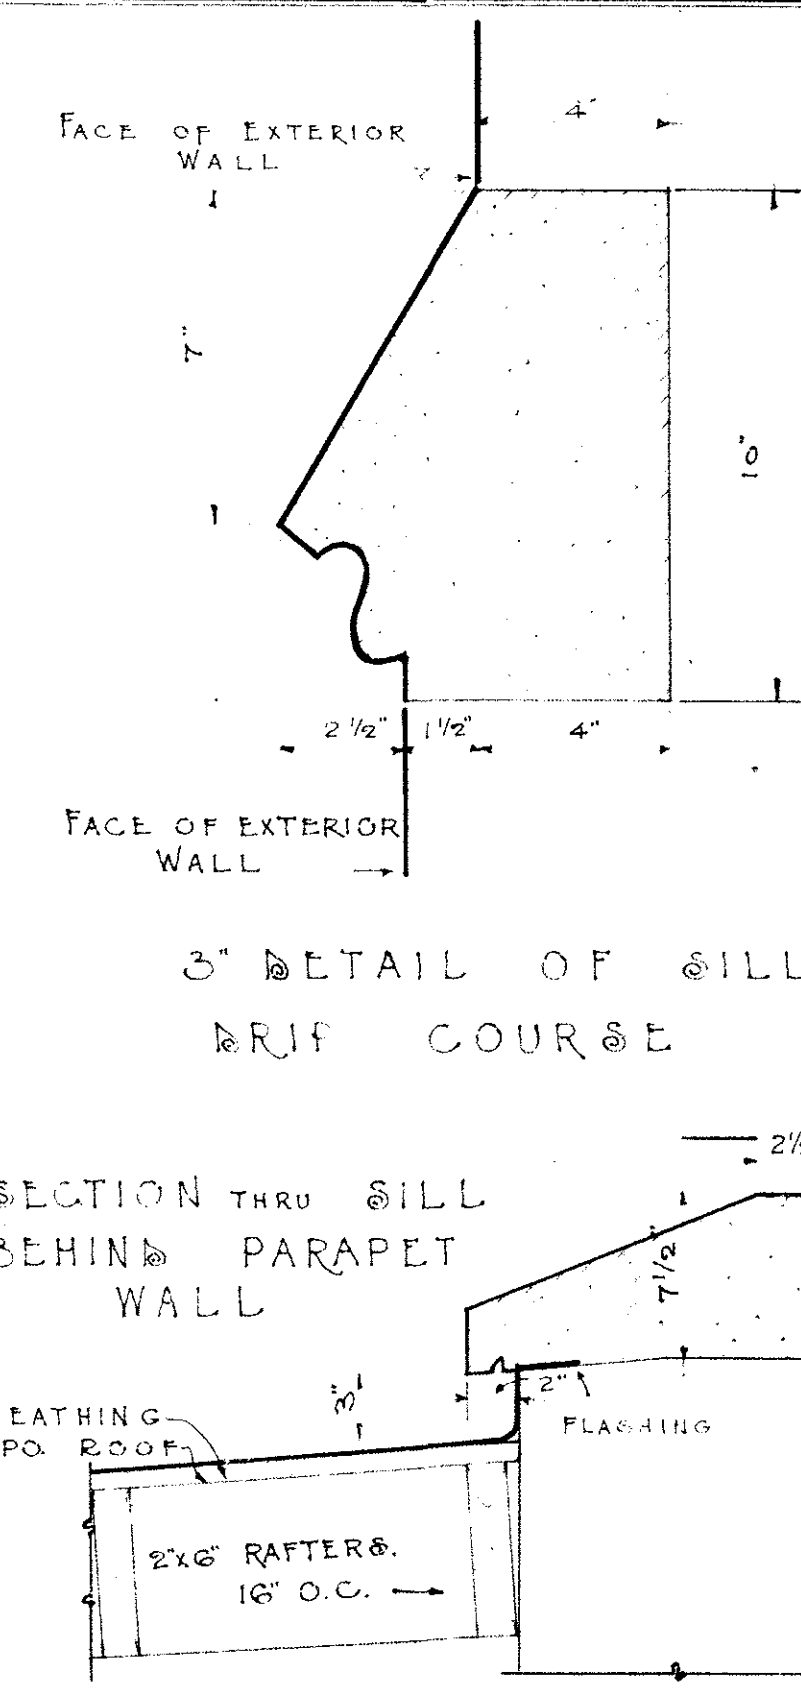



3" DETAIL OF STONE
SPANREL

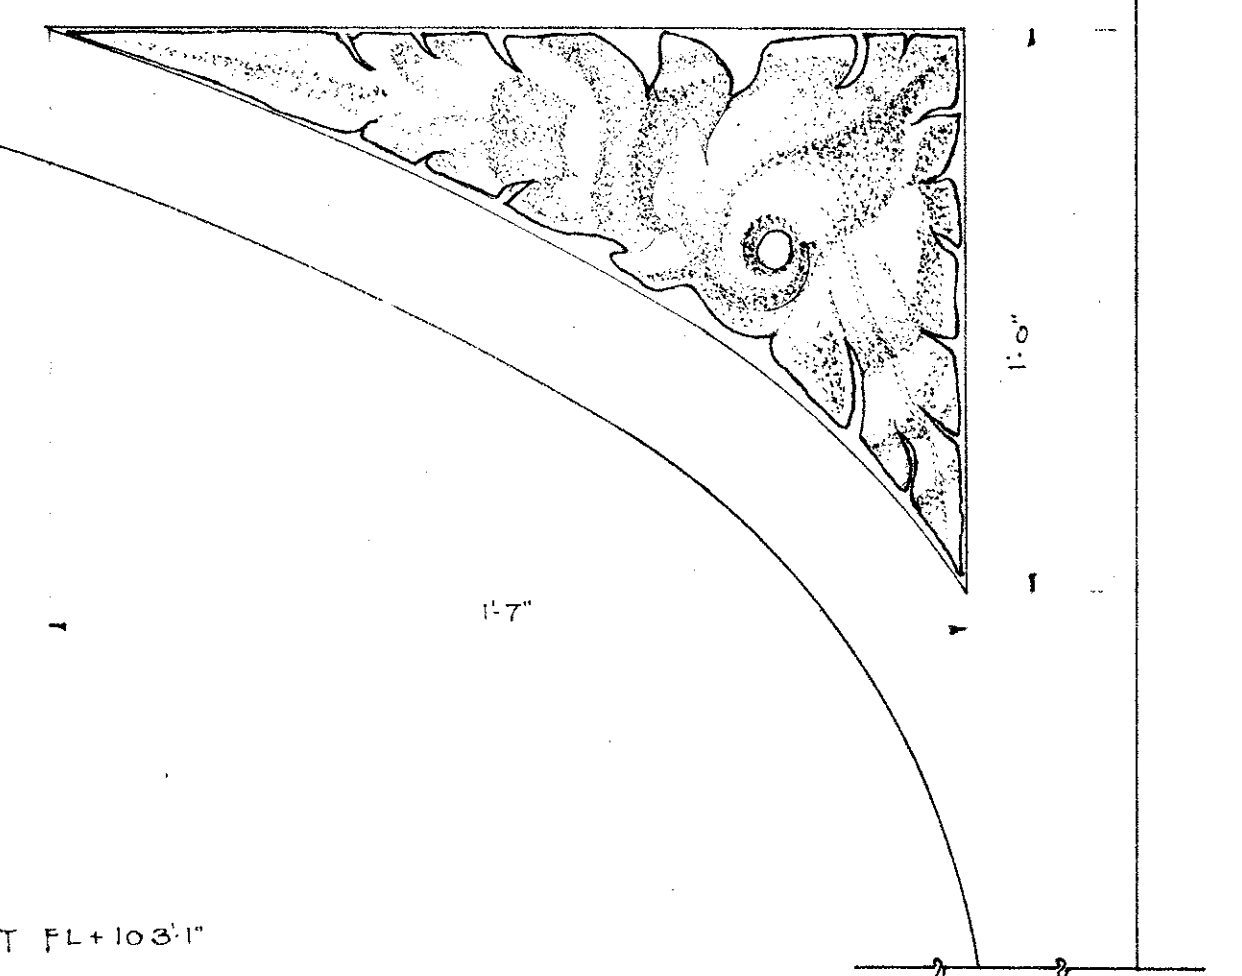




DOOR SCHEDULE					
MARK	WIDTH	HEIGHT	THICK	TYPE	REMARKS
1	7'-0"	7'-6"	2 1/2"	DOUBLE DOOR	SEE DET.
2	7'-0"	8'-6"	2 1/2"	DOUBLE DOOR	SEE DET. SHEET N ^o 2
3	3'-0"	7'-6"	1 3/4"	SINGLE DOOR	" " " "
4	5'-0"	7'-6"	2 1/2"	DOUBLE DOOR	" " " "
5	6'-0"	7'-6"	2 1/2"	DOUBLE DOOR	" " SHEET N ^o 3
6	3'-6"	8'-1 1/2"	2 1/2"	SINGLE DOOR	" " " "
7	3'-6"	8'-0"	1 3/4"	" "	" " " "
8	3'-6"	8'-0"	1 3/4"	" "	" " " "
9	3'-0"	8'-0"	1 3/4"	" "	ONE PANEL
10	2'-6"	8'-0"	1 3/4"	" "	" " " "
11	2'-6"	8'-0"	1 3/4"	" "	" " " "
12-16	2'-6"	6'-8"	1 3/8"	" "	" " " "
13-15	2'-6"	6'-8"	1 3/8"	" "	ONE PANEL (IN BASEM.)

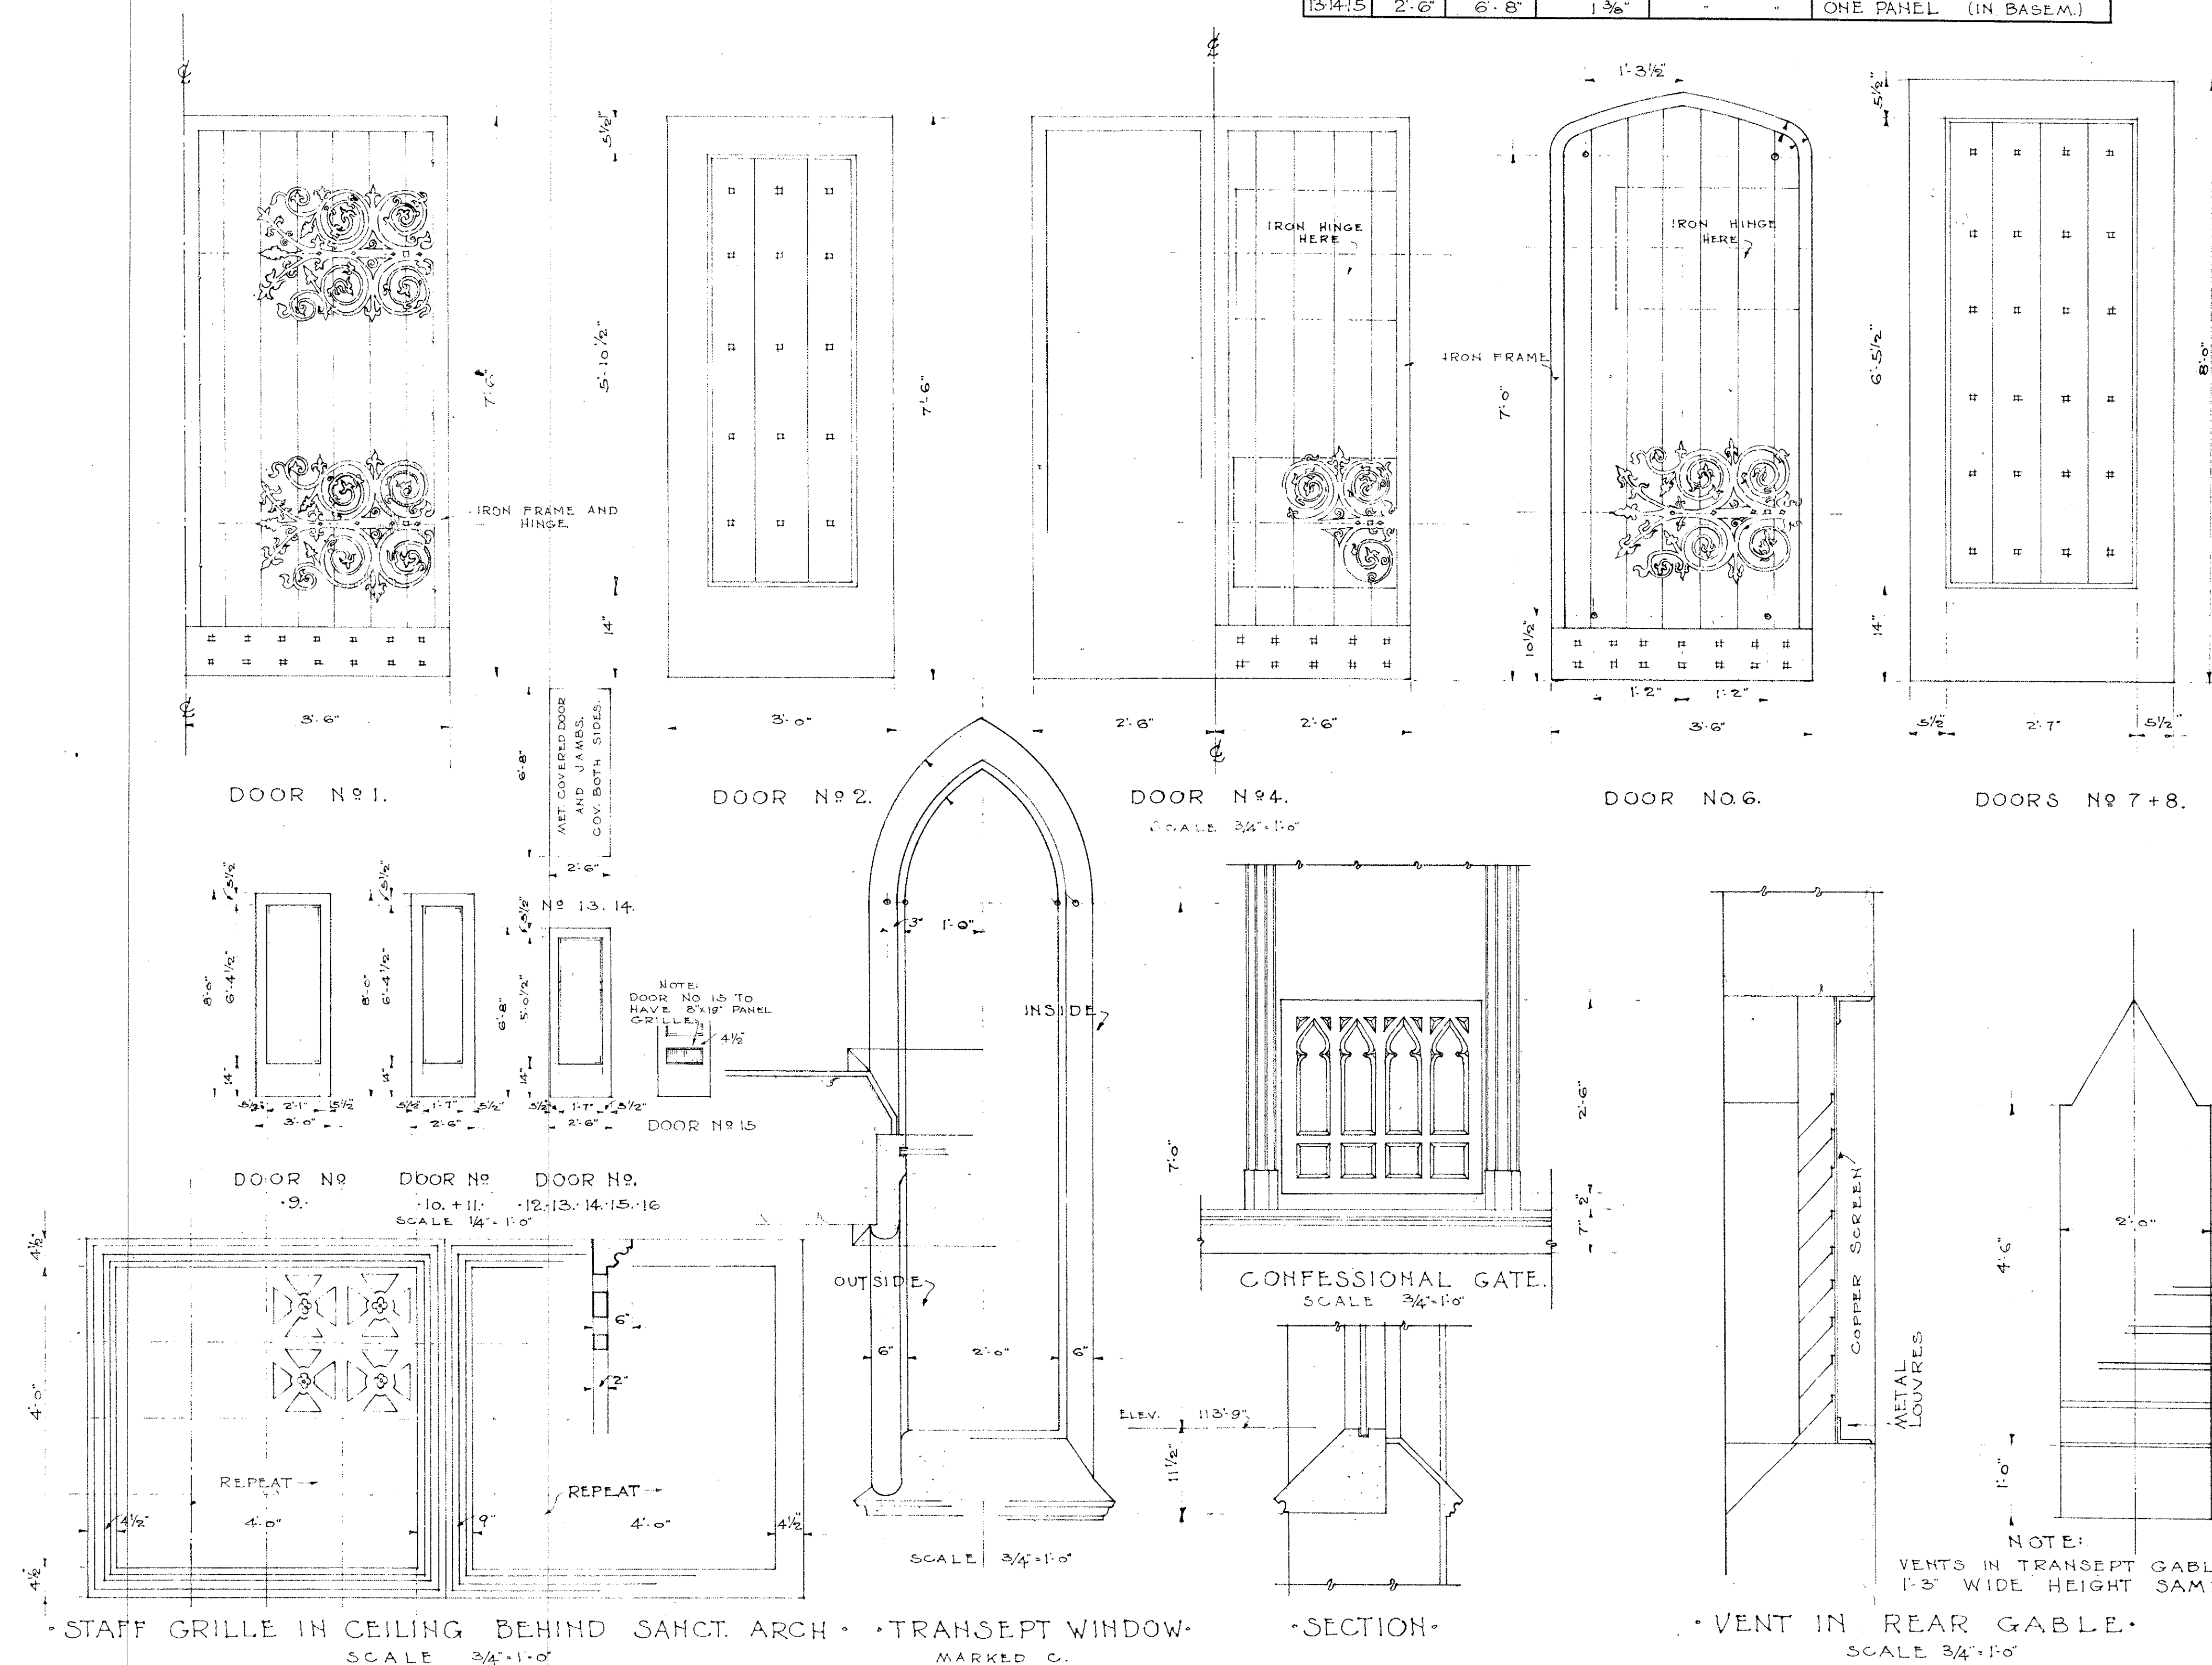


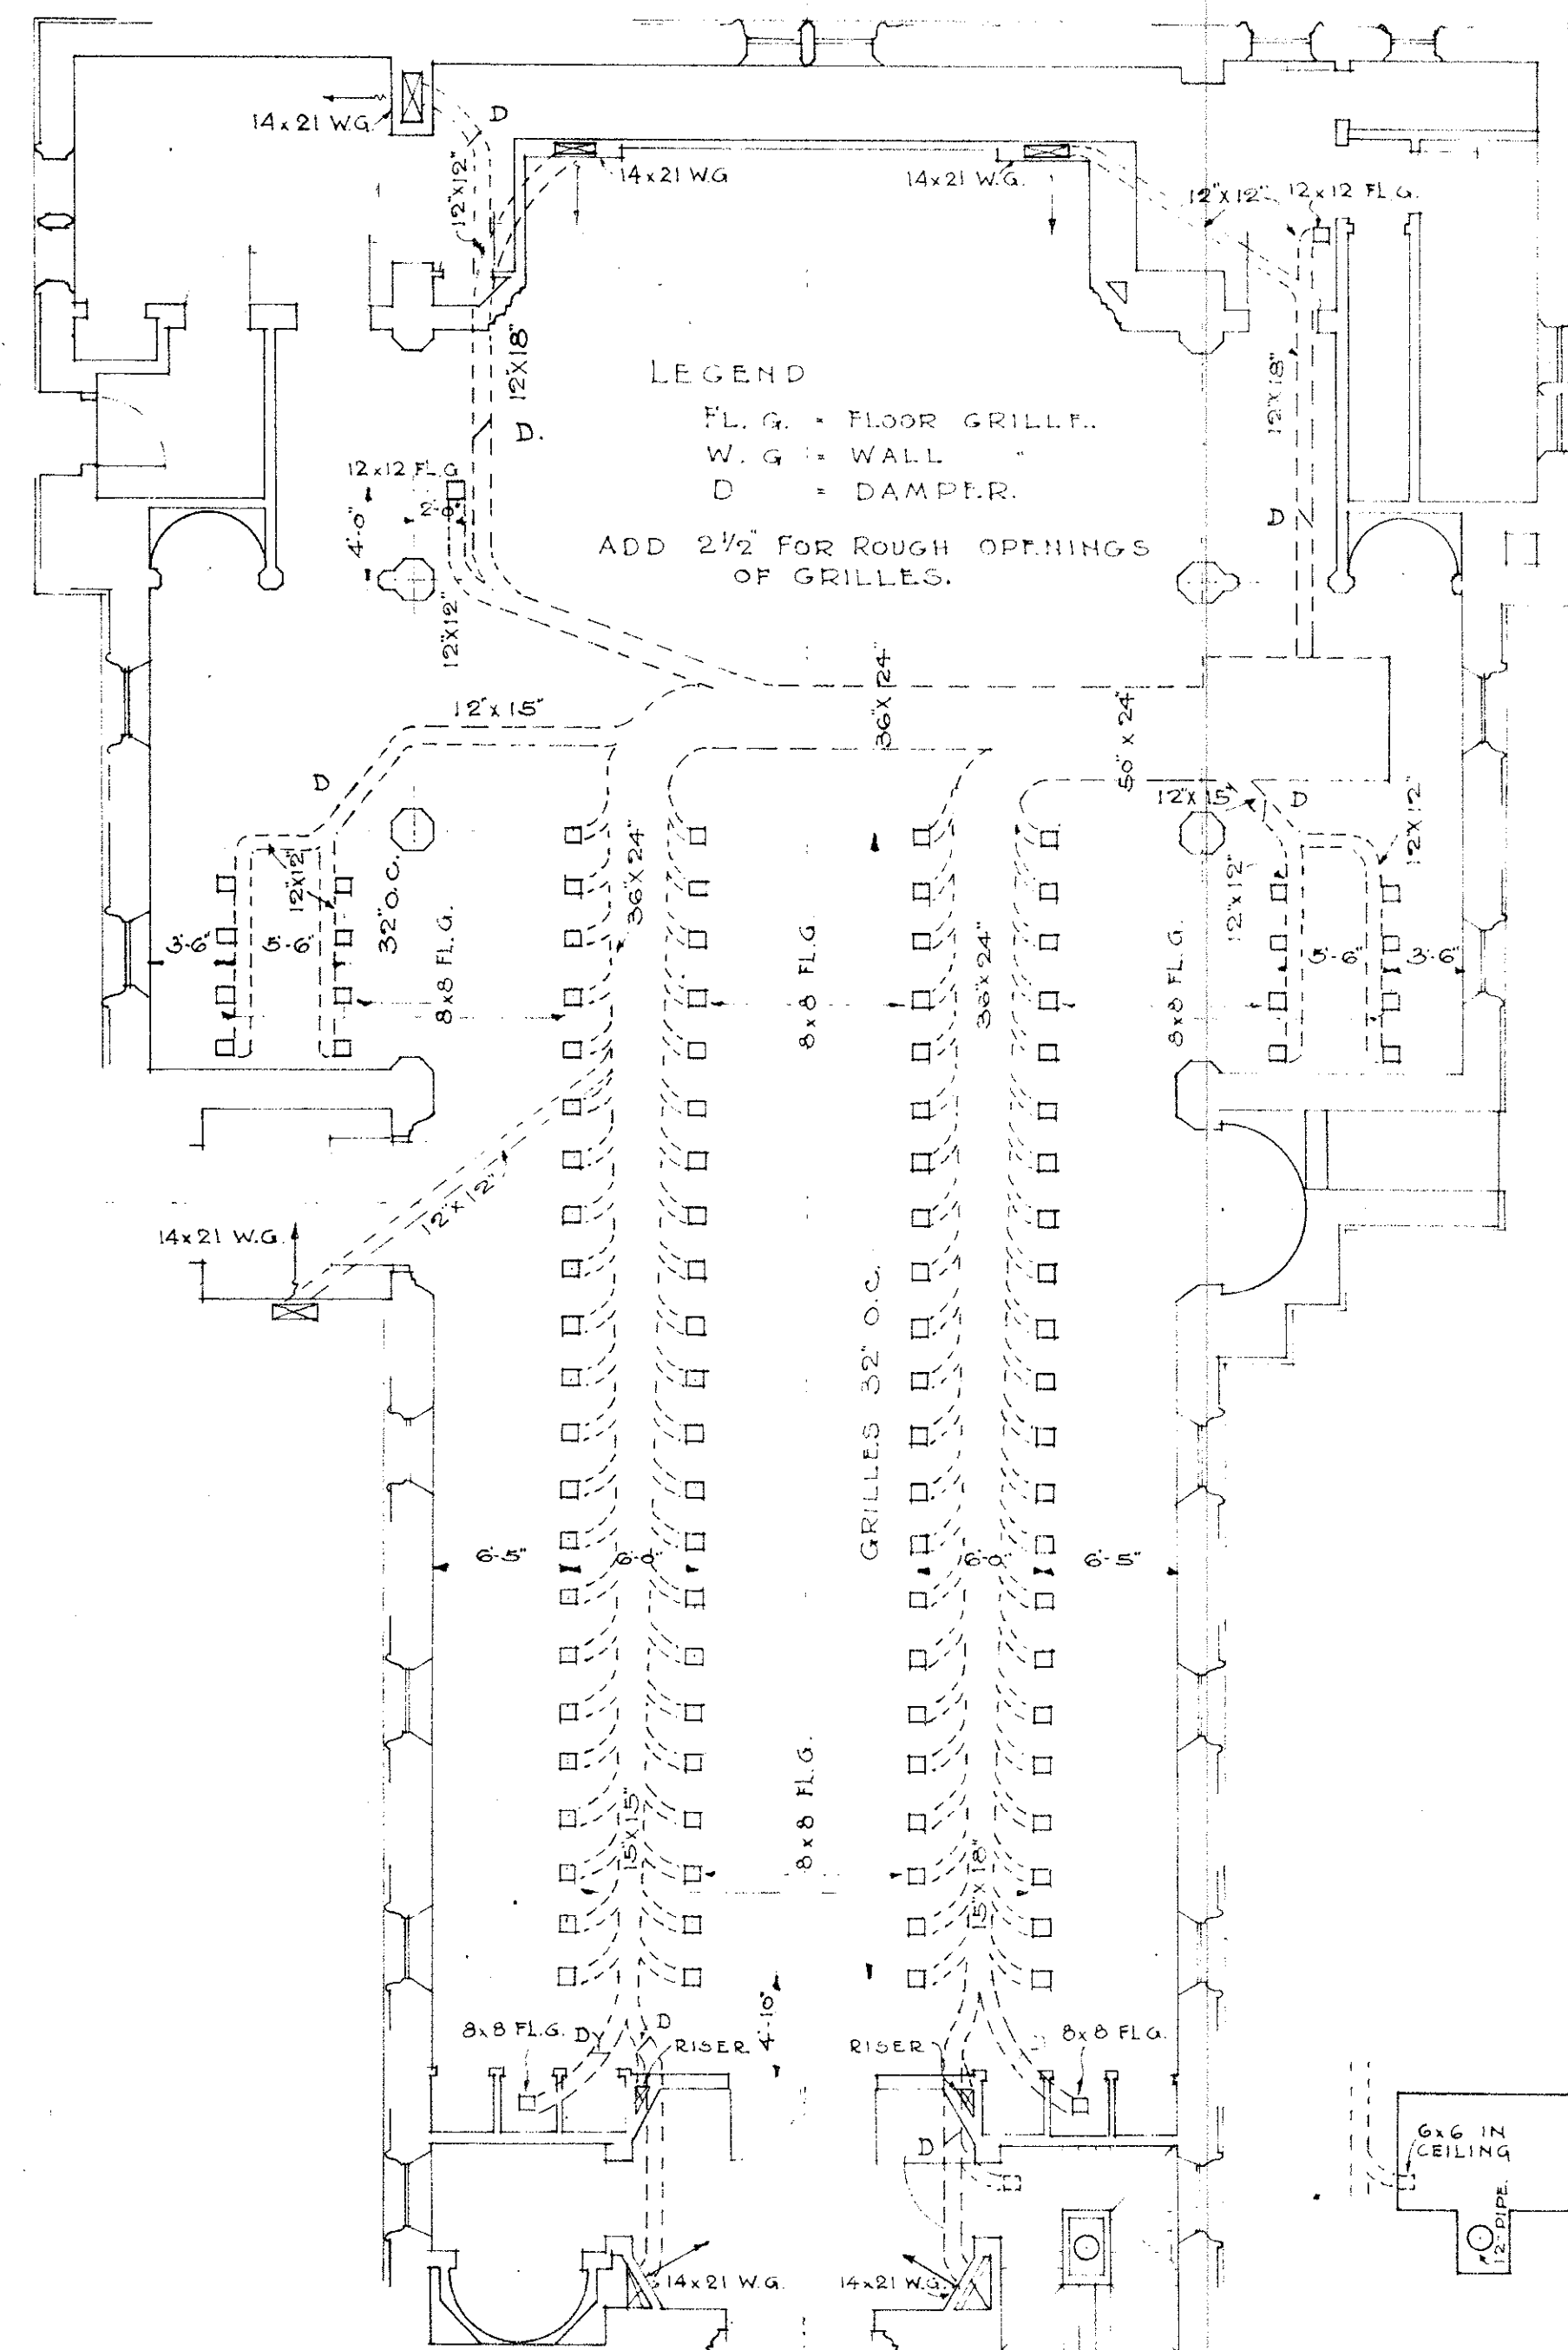

HEATING LAYOUT FOR FIRST FLOOR

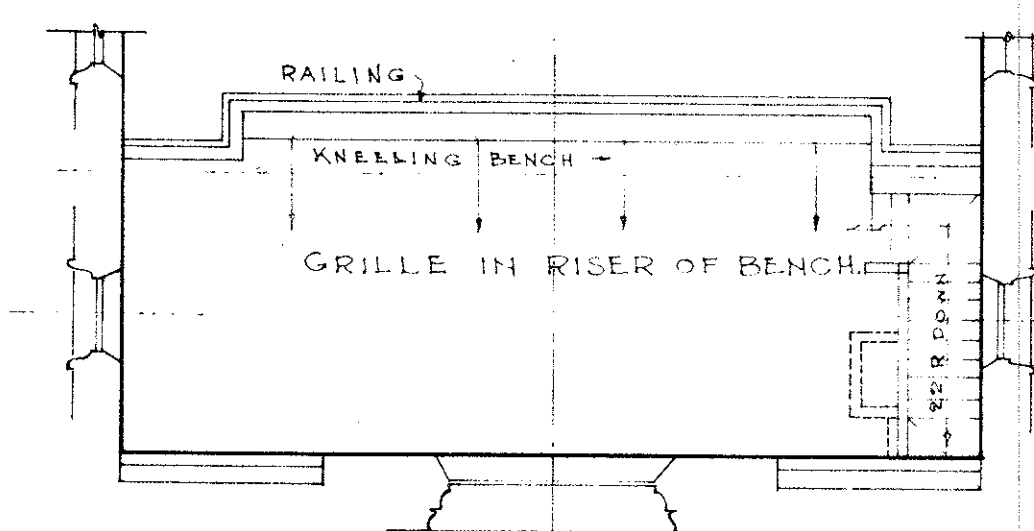


HEATING LAYOUT FOR BALCONY
PLAN OF BALCONY

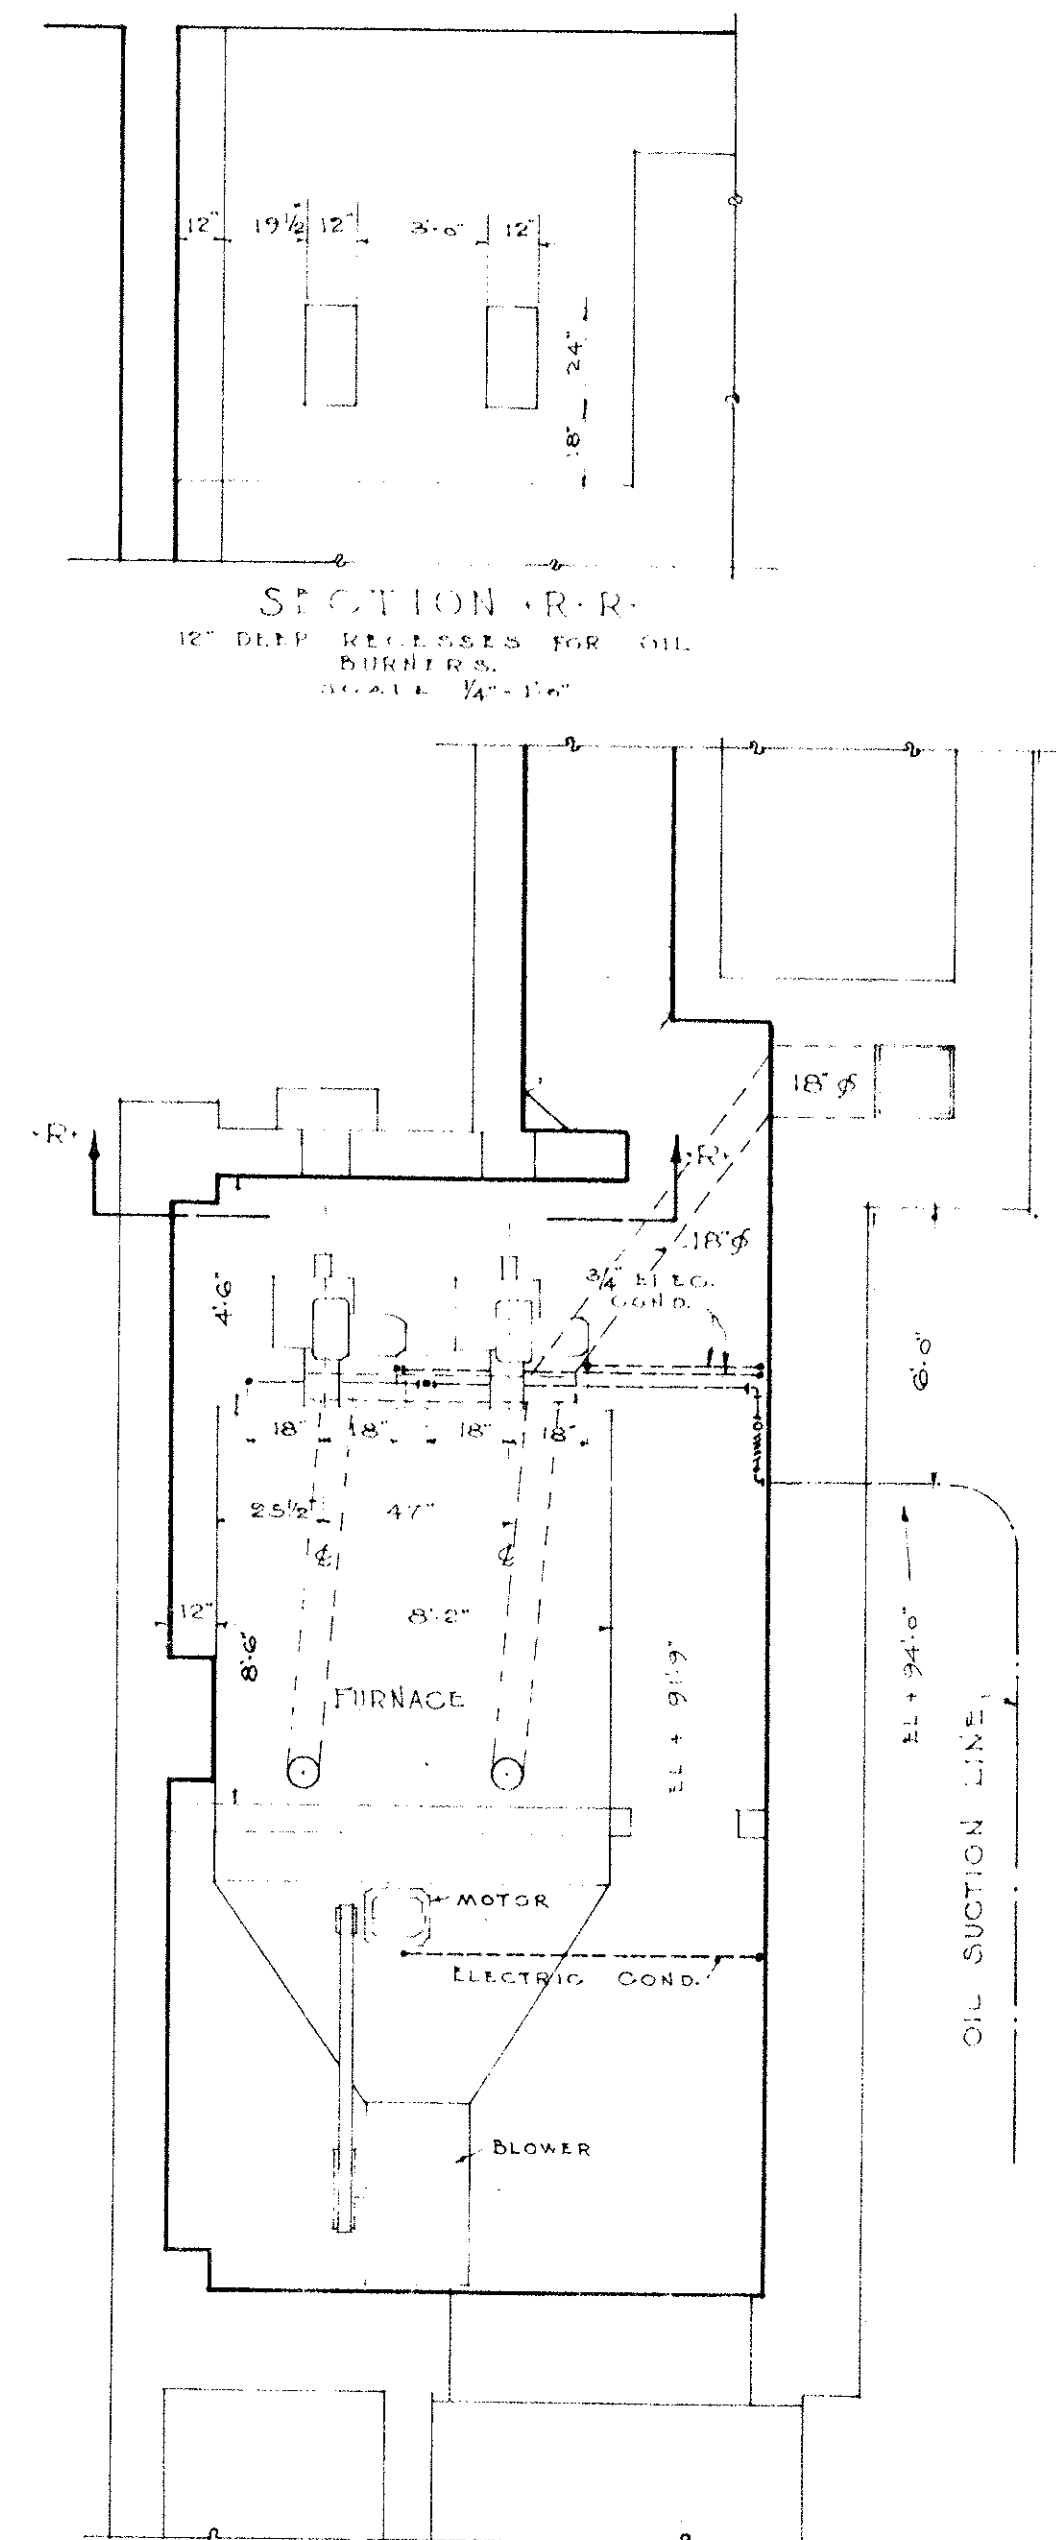

PLAN OF HEATER ROOM
SHOWING POSITION OF
FURNACE AND FANS.
SCALE 1/4\"/>

PLAN OF BLOWER ROOM
IN BASEMENT.

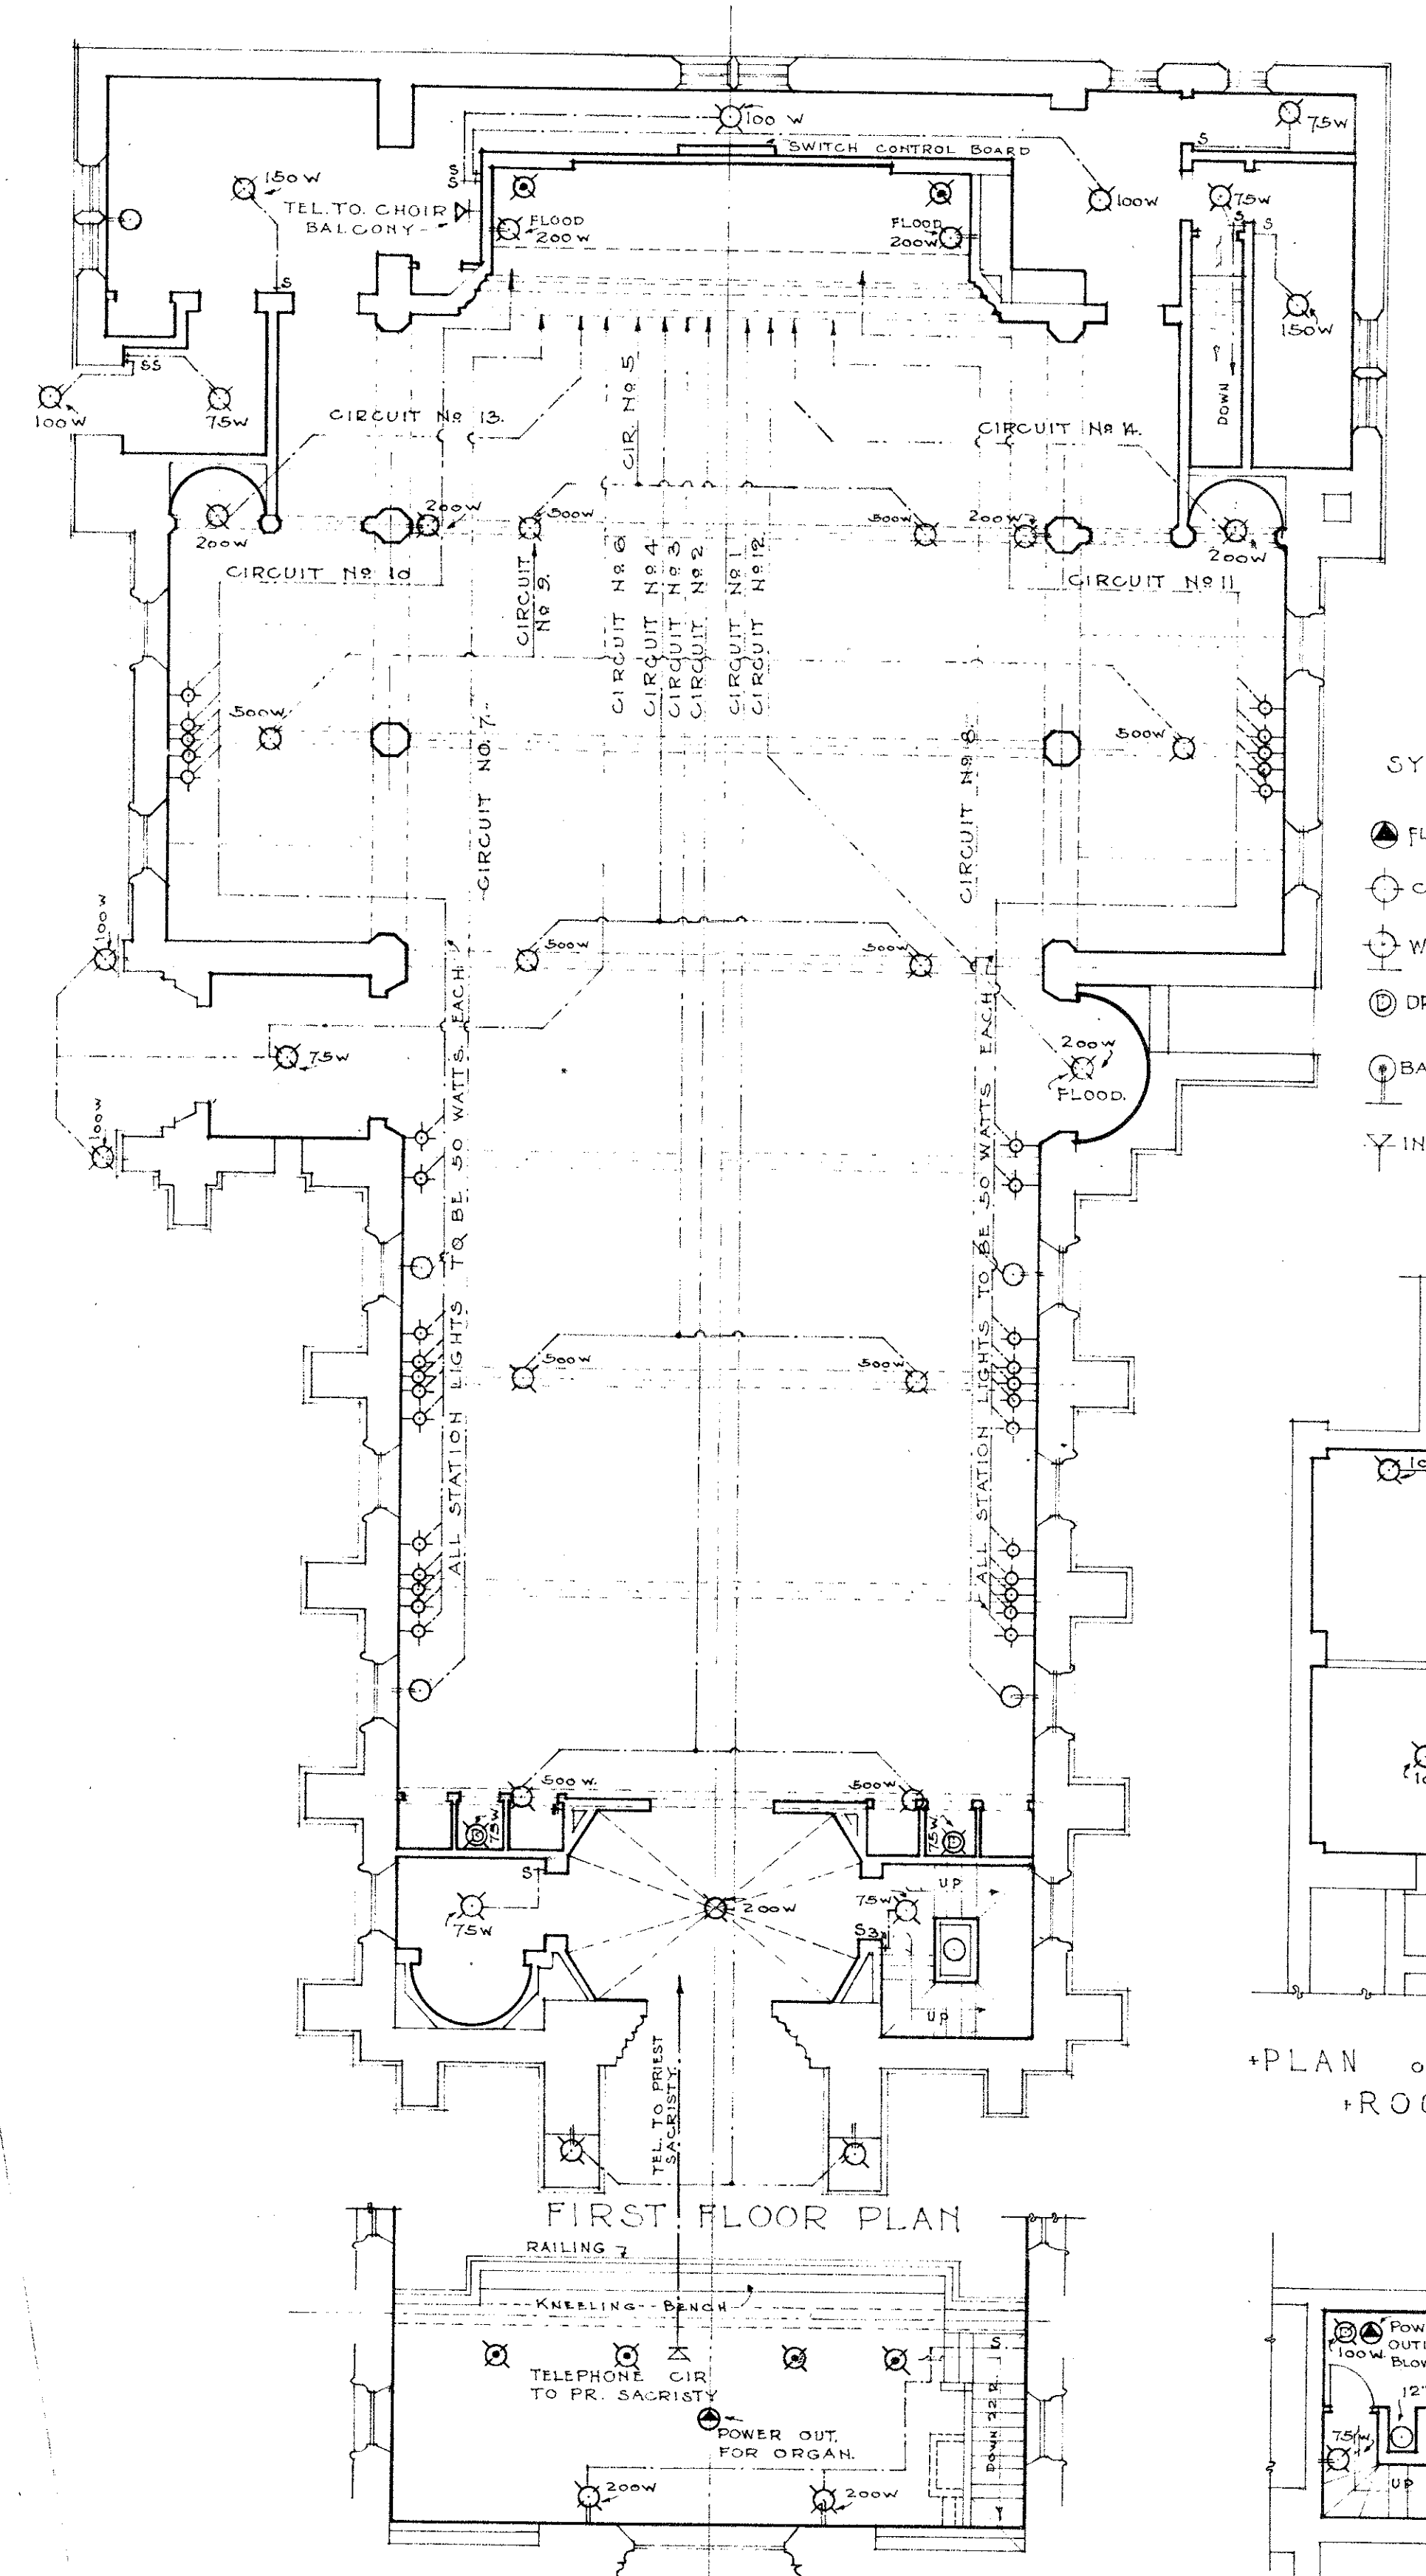

FIRST FLOOR PLAN

PLAN OF BALCONY
ELECTRICAL LAYOUT

PLAN OF HEATER
ROOM

PLAN OF BLOWER
ROOM

